

QUORUM DR.



MARCEY ST.

FACTORY STREET

BELT LINE ROAD

ST. LOUIS & SOUTHWESTERN RAILROAD

DALLAS PARKWAY

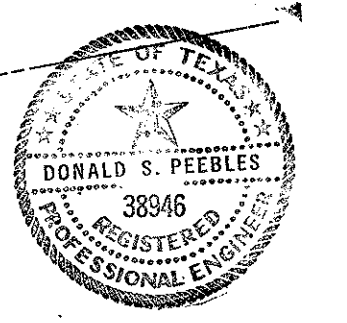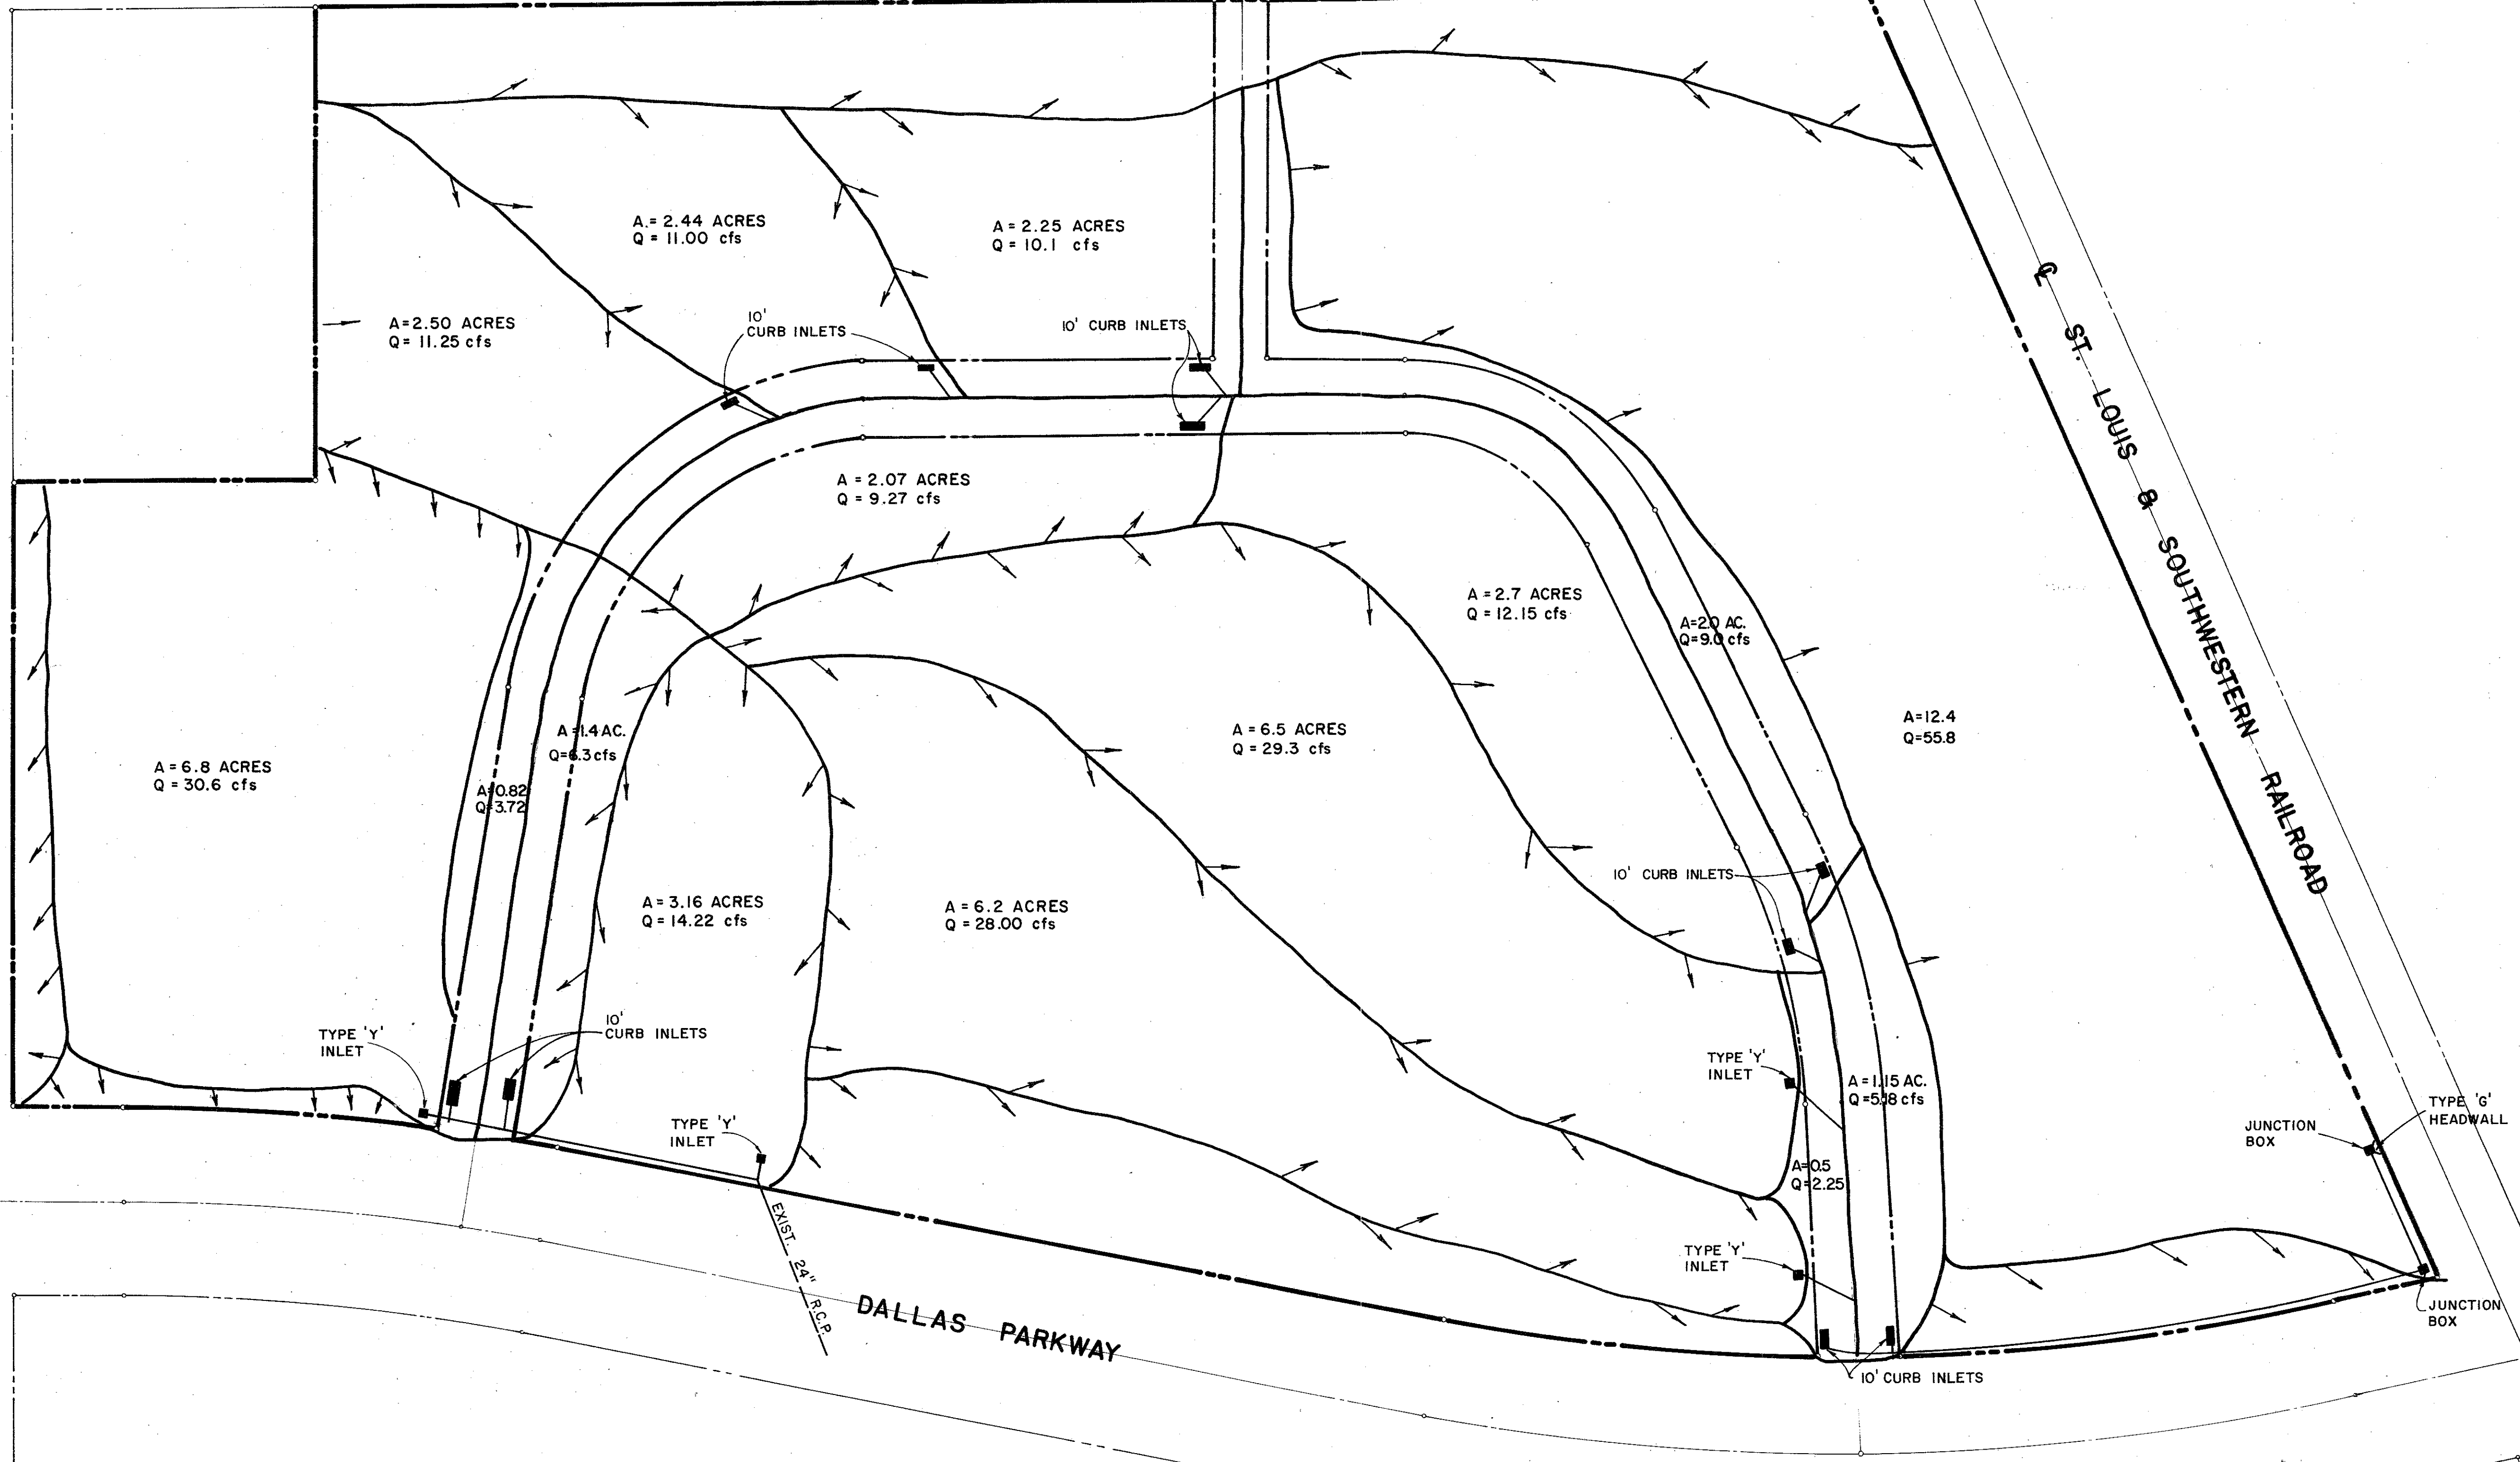

SCALE: 1"=100'

DRAINAGE PLAN

QUORUM NORTH  
CITY OF ADDISON, TEXAS

**Graham Associates, Inc.**  
CONSULTING ENGINEERS & PLANNERS

Drawn By: G. A. I. Sheet 4 Of 19

Date  
9-79  
File  
314-1441