

PROJECT DIRECTORY

CITY MANAGER
5300 BELTLINE ROAD, ADDISON, TEXAS 75001
RON WHITEHEAD

PARKS AND RECREATION DEPARTMENT
P.O. BOX 144 ADDISON, TEXAS 75001
450 7000 450 2869
SLADE STRICKLAND, DIRECTOR
ROBERT WOOD, ASSISTANT DIRECTOR

MEP
ARJO ENGINEERS
1222 MERIT DRIVE, SUITE 250
233 4478
BILL HOVSE NIELS FALLISGAARD

**STRUCTURAL/
CIVIL**
BROCKETTE, DAVIS, DRAKE
3535 TRAVIS, SUITE 100
522 9540
BOB WILLIAMS




FOUNTAINS
FANTASTIC FOUNTAINS
2019 ALSACE DRIVE, P.O. BOX 11077 CARROLLTON, TEXAS 75007
242 7803
BERNIE HEMINGWAY

IRRIGATION
TERRY LITTLE
2300 HIGHLAND VILLAGE ROAD, SUITE 250 HIGHLAND VILLAGE, TEXAS 75067
317 3170
TERRY LITTLE

INDEX TO DRAWINGS

SHEET NO.	TITLE
LC-1	INDEX TO DRAWINGS/ OVERALL SITE PLAN
LC-2	EXISTING CONDITIONS, UTILITY, & DEMOLITION PLAN
LC-3	LAYOUT PLAN
LC-4	GRADING PLAN
LC-5	SITE FURNISHING PLAN
LC-6	MAIN FOUNTAIN LAYOUT PLAN
LC-7	MAIN FOUNTAIN DETAILS
LC-8	MAIN FOUNTAIN DETAILS
LC-9	MAIN FOUNTAIN FOUNDATION PLAN
LC-10	MAIN FOUNTAIN ELEVATIONS
LC-11	SECONDARY FOUNTAIN DETAILS
LC-12	PAVING & SURFACING DETAILS
LC-13	COLUMN & DEDICATION PLAQUE
LC-14	PARK SIGNAGE DETAILS
LC-15	SITE FURNISHING DETAILS
LC-16	SITE FURNISHING DETAILS
E-1	ELECTRICAL PLAN
E-2	ELECTRICAL SCHEDULE & DETAILS
M-1	MECHANICAL PLAN
M-2	SECONDARY & MAIN FOUNTAIN MECHANICAL PLANS
M-3	FOUNTAIN MECHANICAL
L-1	LANDSCAPE PLAN
L-2	LANDSCAPE DETAILS
IR-1	IRRIGATION PLAN
IR-2	IRRIGATION DETAILS

LOCATION MAP

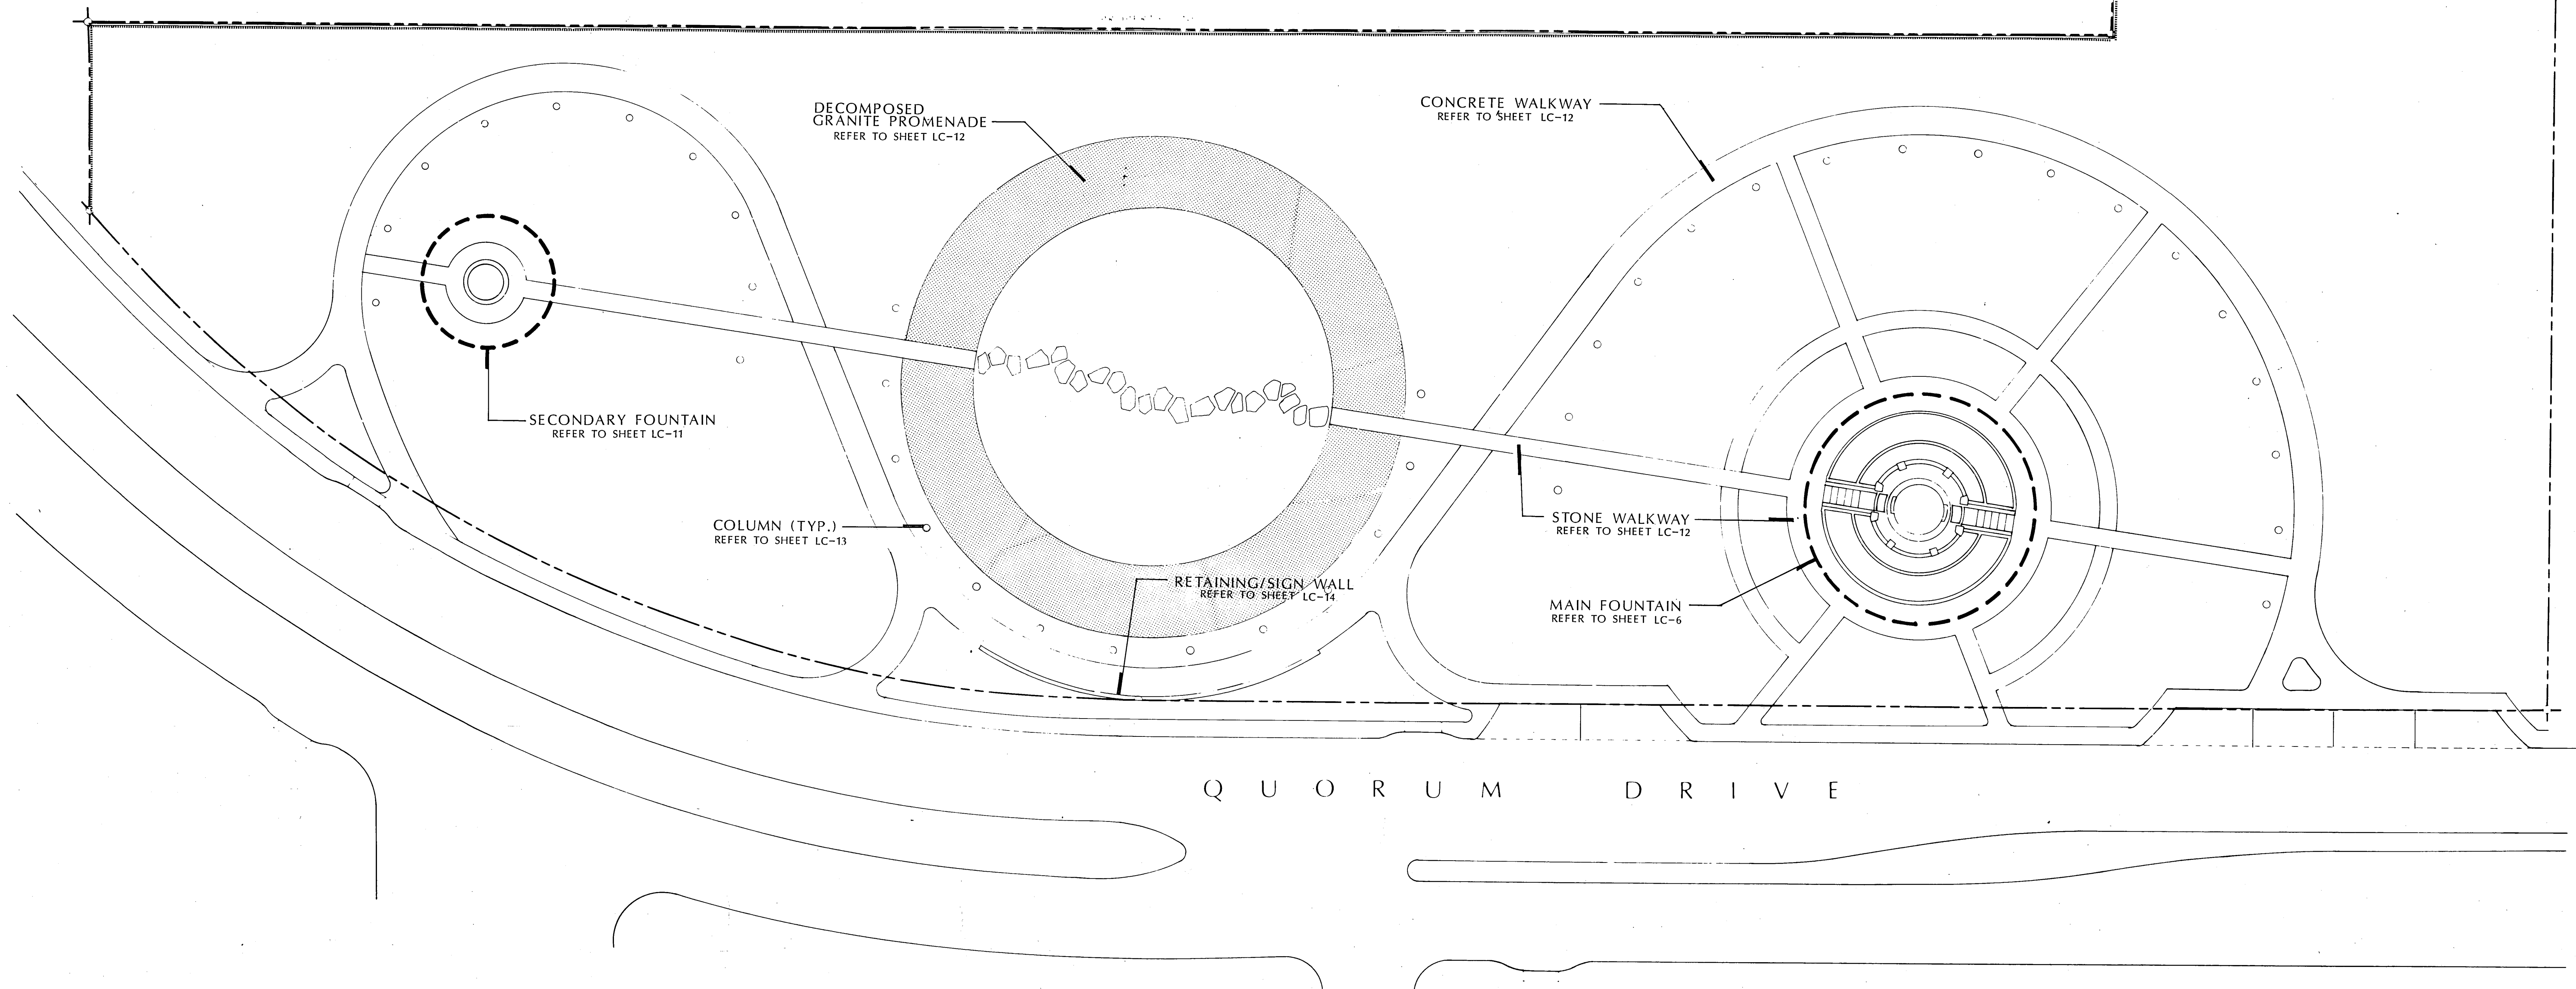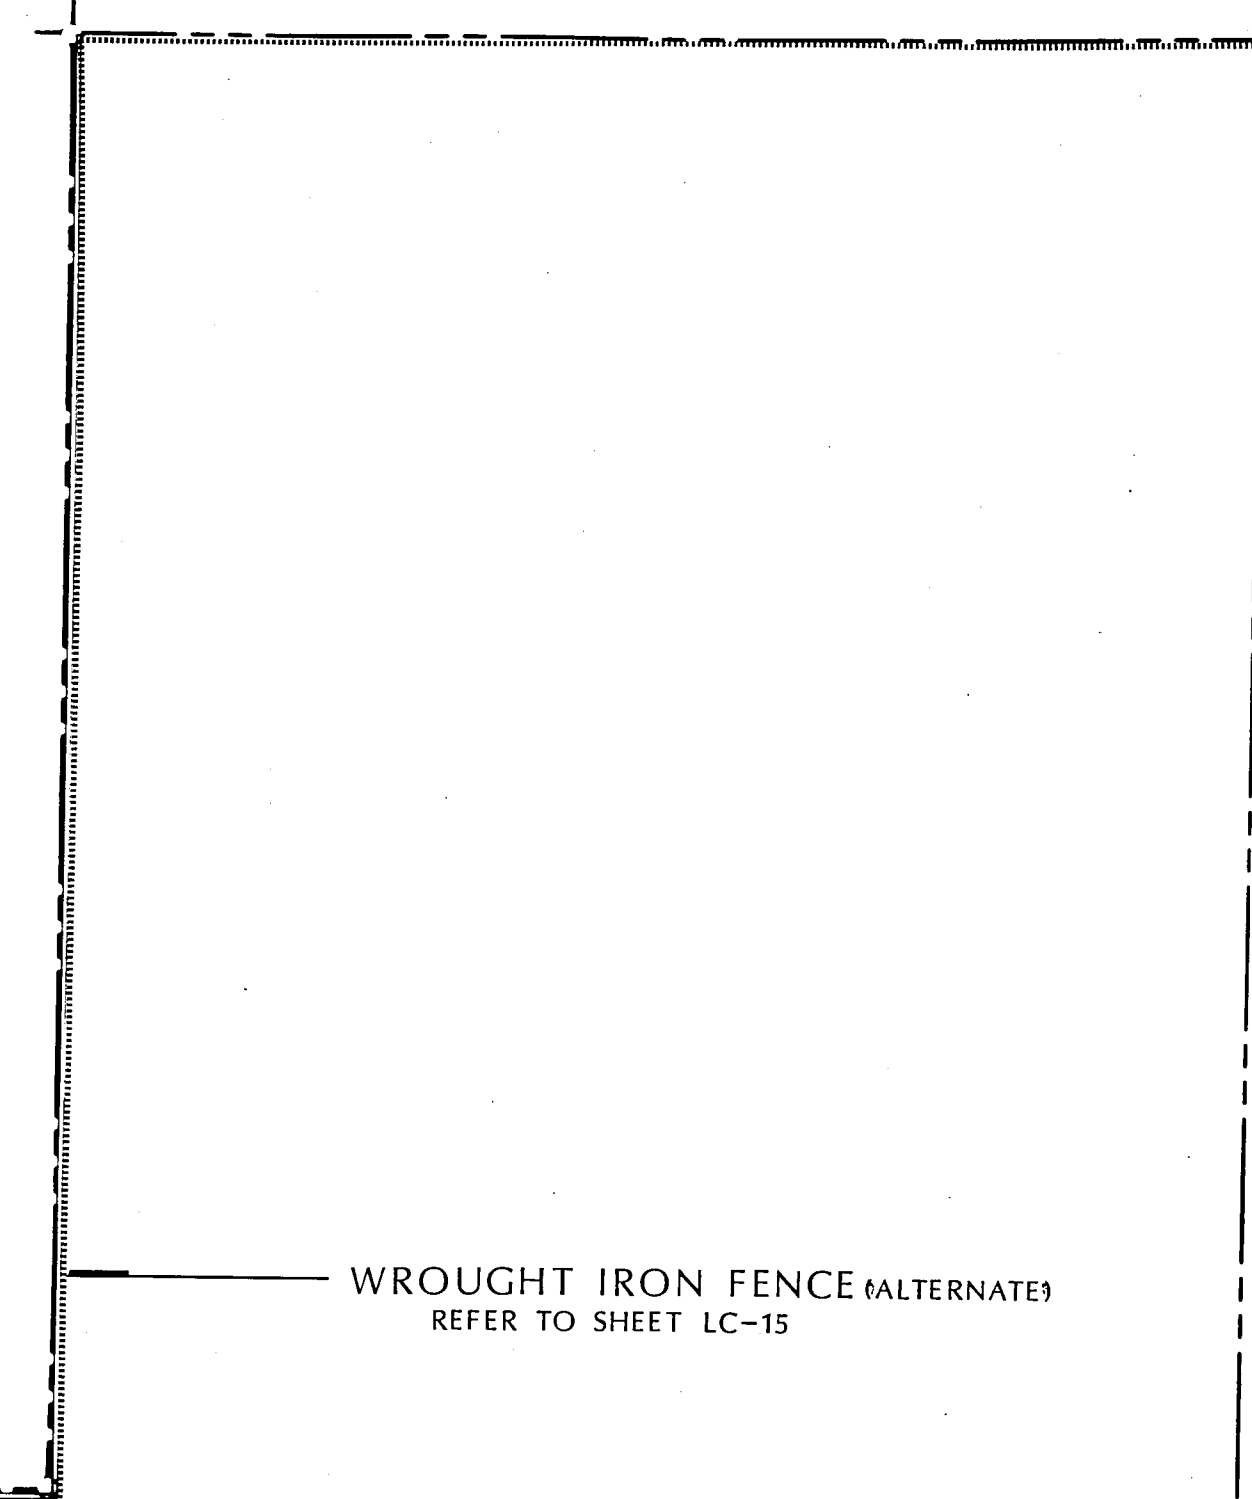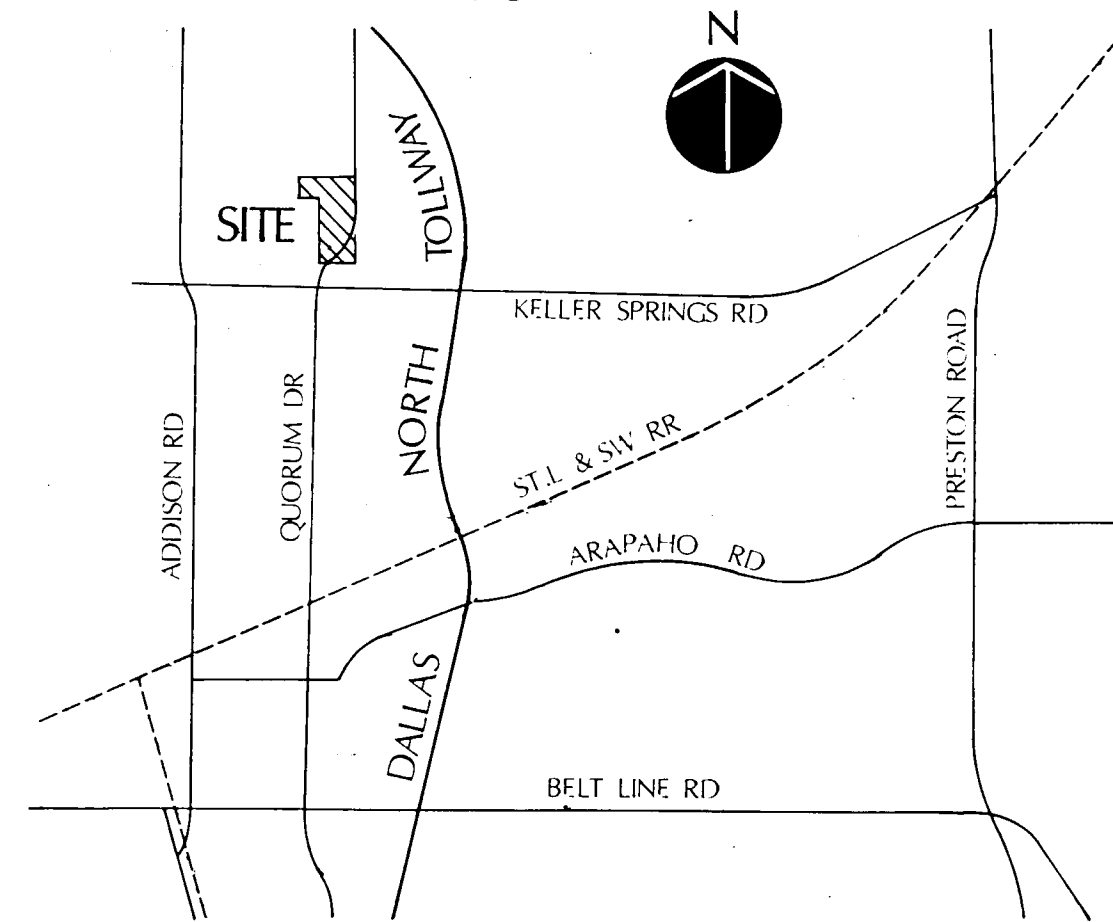

MESA
DESIGN GROUP

INDEX TO DRAWINGS/
OVERALL SITE PLAN

QUORUM PARK
ADDISON, TEXAS

ADDISON
TOWN OF



DATE	12/12/89
ISSUED	29 JAN. 1990

PROJECT NO.	88019
DRAWN BY	SG
CHECKED BY	SG
SCALE	
SHEET NO.	LC-1