




GLENN CURTISS STREET

REMOVE CURB INLET TOP AND REPLACE WITH MULTIPLE GRATE INLET TOP AND FRAME. SUBMIT SHOP DRAWINGS TO ENGINEER FOR APPROVAL.

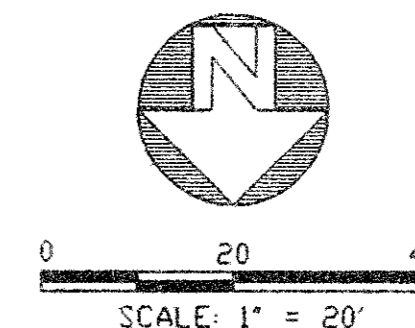

- LEGEND**
- WV = WATER VALVE
 - FH = FIRE HYDRANT
 - MH = MANHOLE
 - GAS = LONE STAR GAS LINE
 - STS = STORM SEWER
 - W = WATERLINE
 - PP = POWER POLE
 - TEL = TELEPHONE LINE MARKER
 - SS = SANITARY SEWER
 - OE = OVERHEAD ELECTRIC

ADDISON ROAD

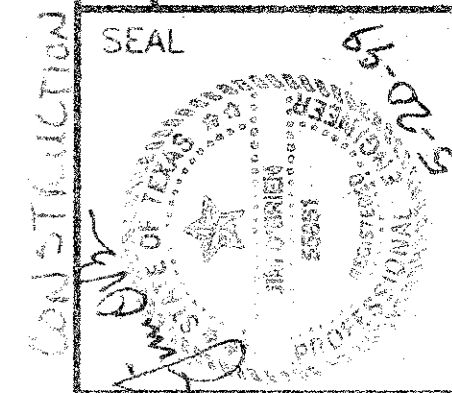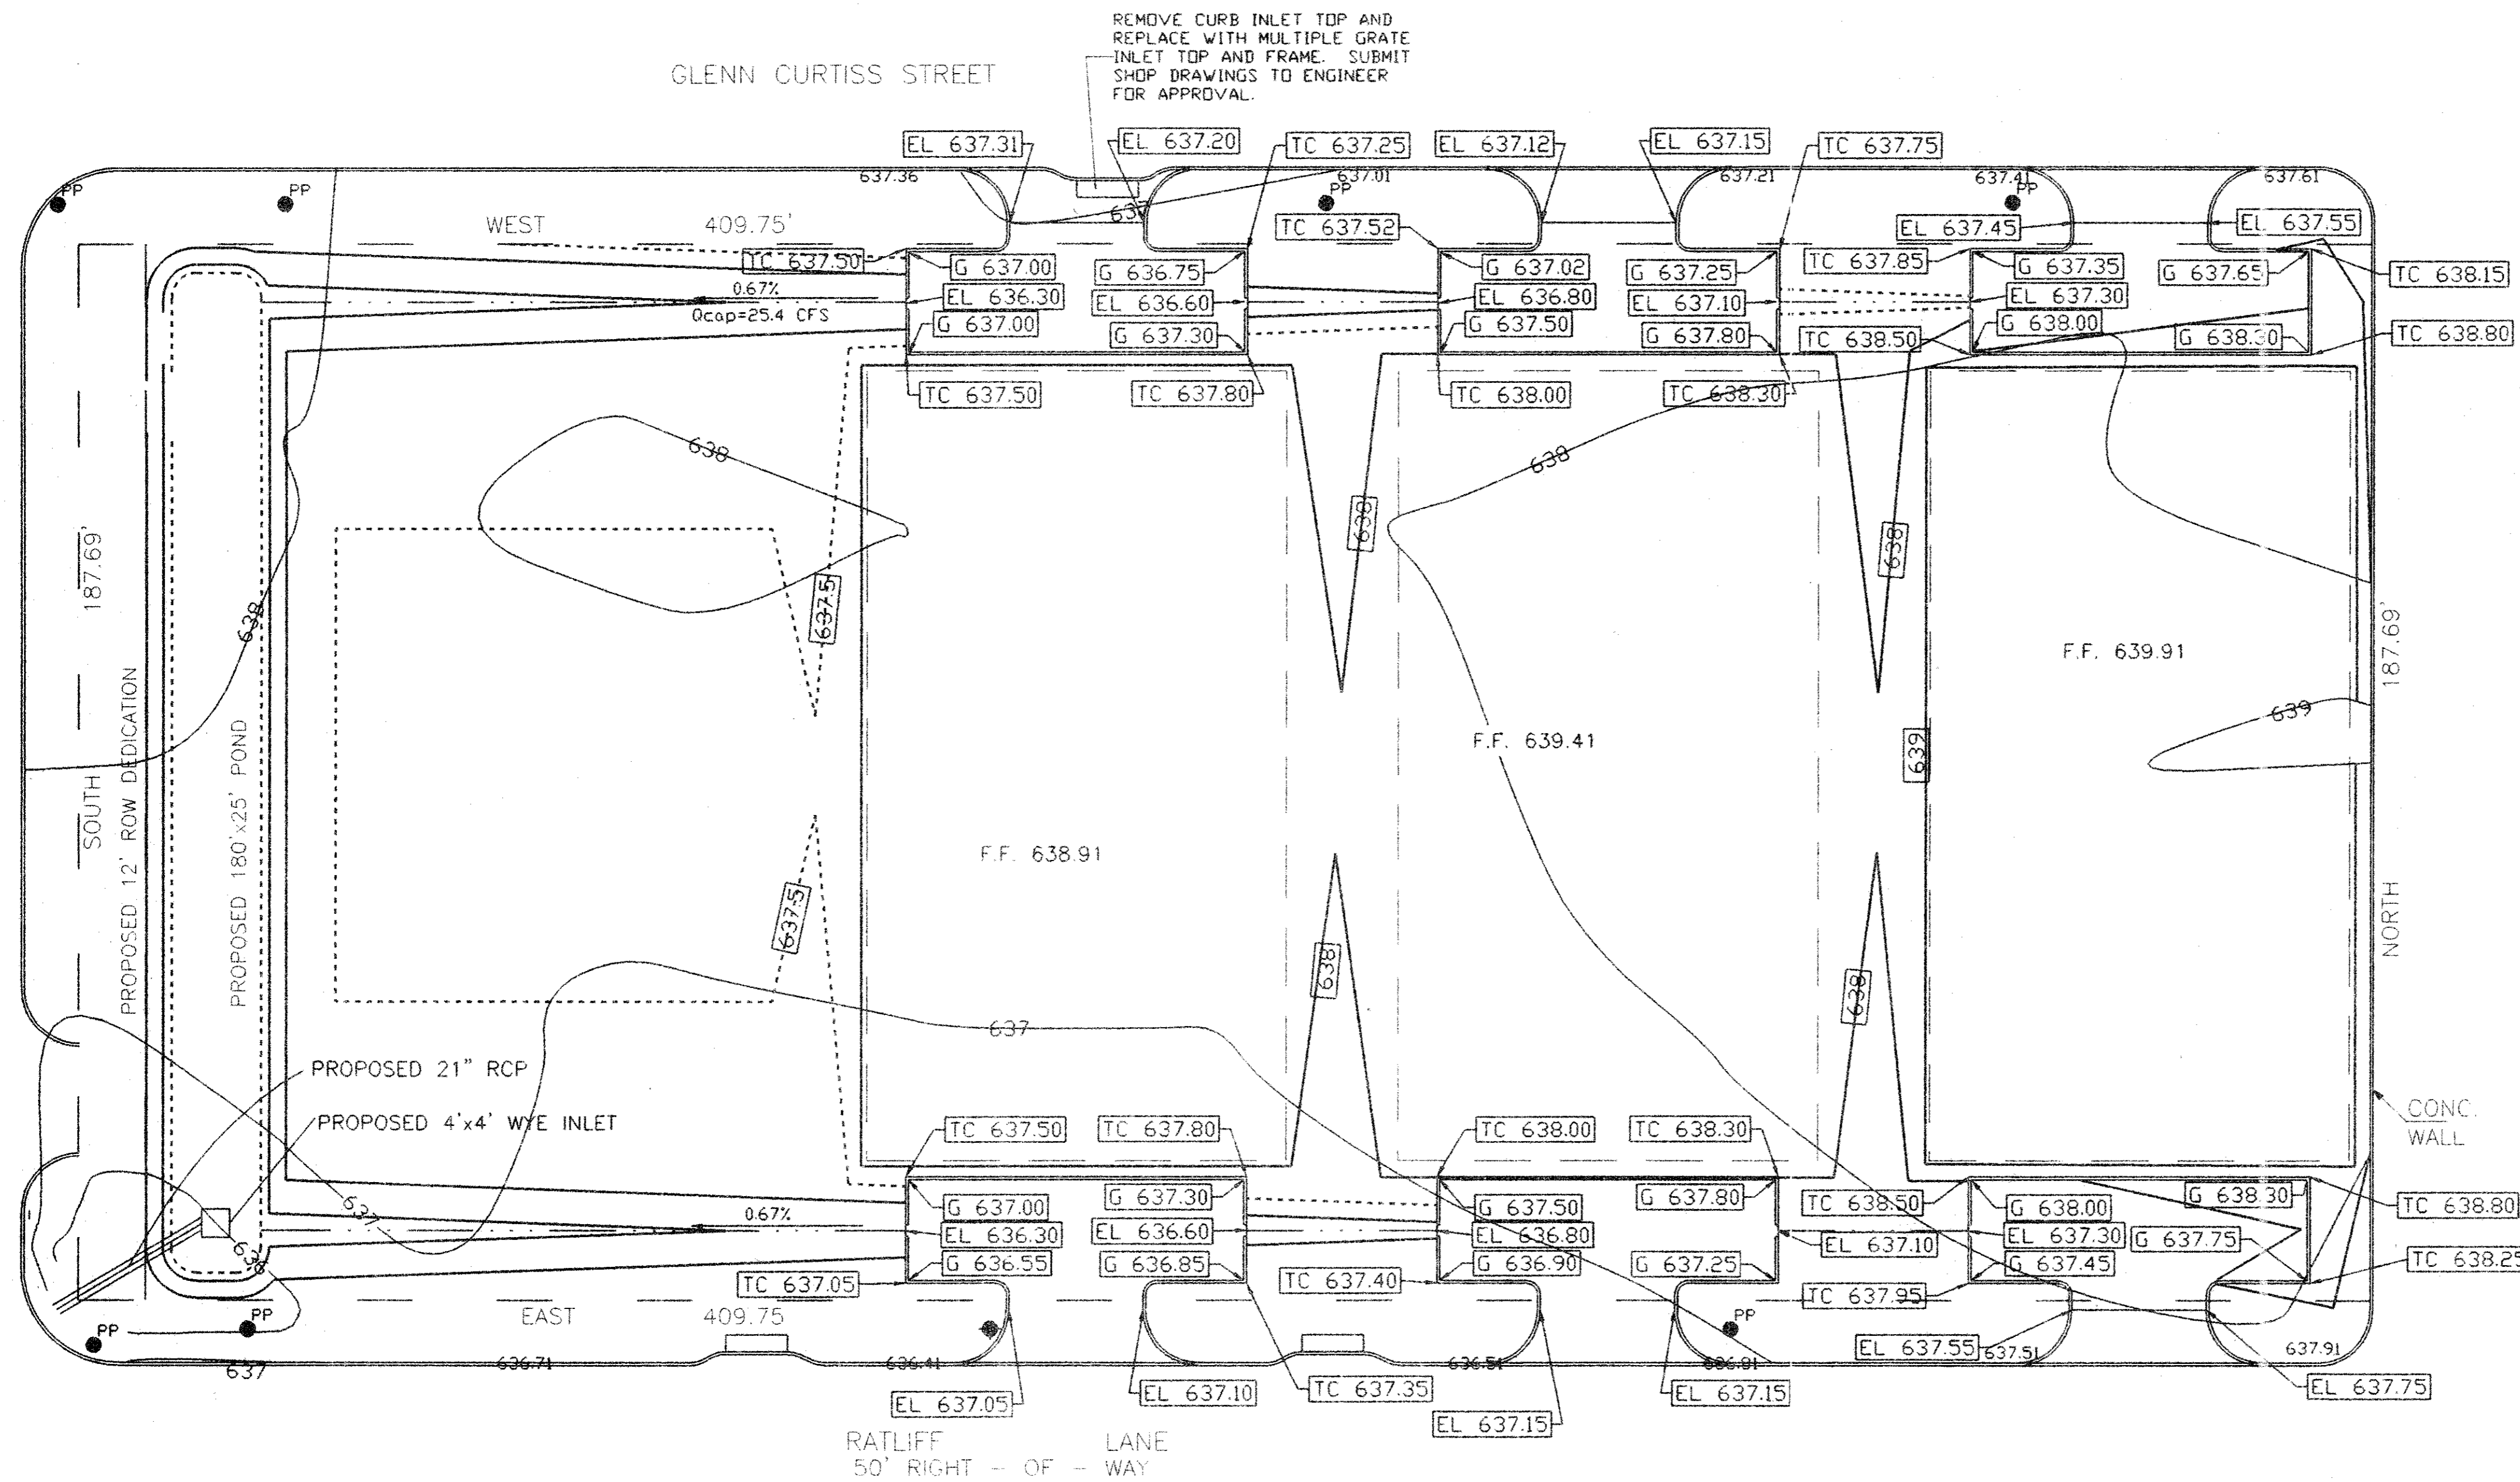

O'Brien Engineering
 12016 Bee Street, Suite 202
 Farmers Branch, TX 75234
 PH: 872 241-0335
 FX: 872 241-0370

PREPARED BY:
 PROJECT:
 FACILITIES:
GRADING PLAN

DESIGNED BY: O.E.
 DRAWN BY: O.E.
 NOTE AND REVISIONS:
 5/10/99 - ADDED GRADING/PAVING FOR BLDGS. 2 & 3

ADDISON, TX