


SHEET INDEX
SCALE: N.T.S.


COVER	--
A1.00	KEY PLAN / OVERALL MASTER PLAN
A2.01	ENLARGED PLAN - PART 1
A2.02	ENLARGED PLAN - PART 2
A2.03	ENLARGED PLAN - PART 3
A2.04	ENLARGED PLAN - PART 4
A3.01	PHOTOMETRIC PLAN - PART 1
A3.02	PHOTOMETRIC PLAN - PART 2
A3.03	PHOTOMETRIC PLAN - PART 3
A3.04	PHOTOMETRIC PLAN - PART 4
A3.10	PHOTOMETRIC INFORMATION

Addison![®]

Gensler
5430 LBJ Freeway
Suite 400
Dallas TX 75240
Telephone 214.273.1500
Facsimile 214.273.1505

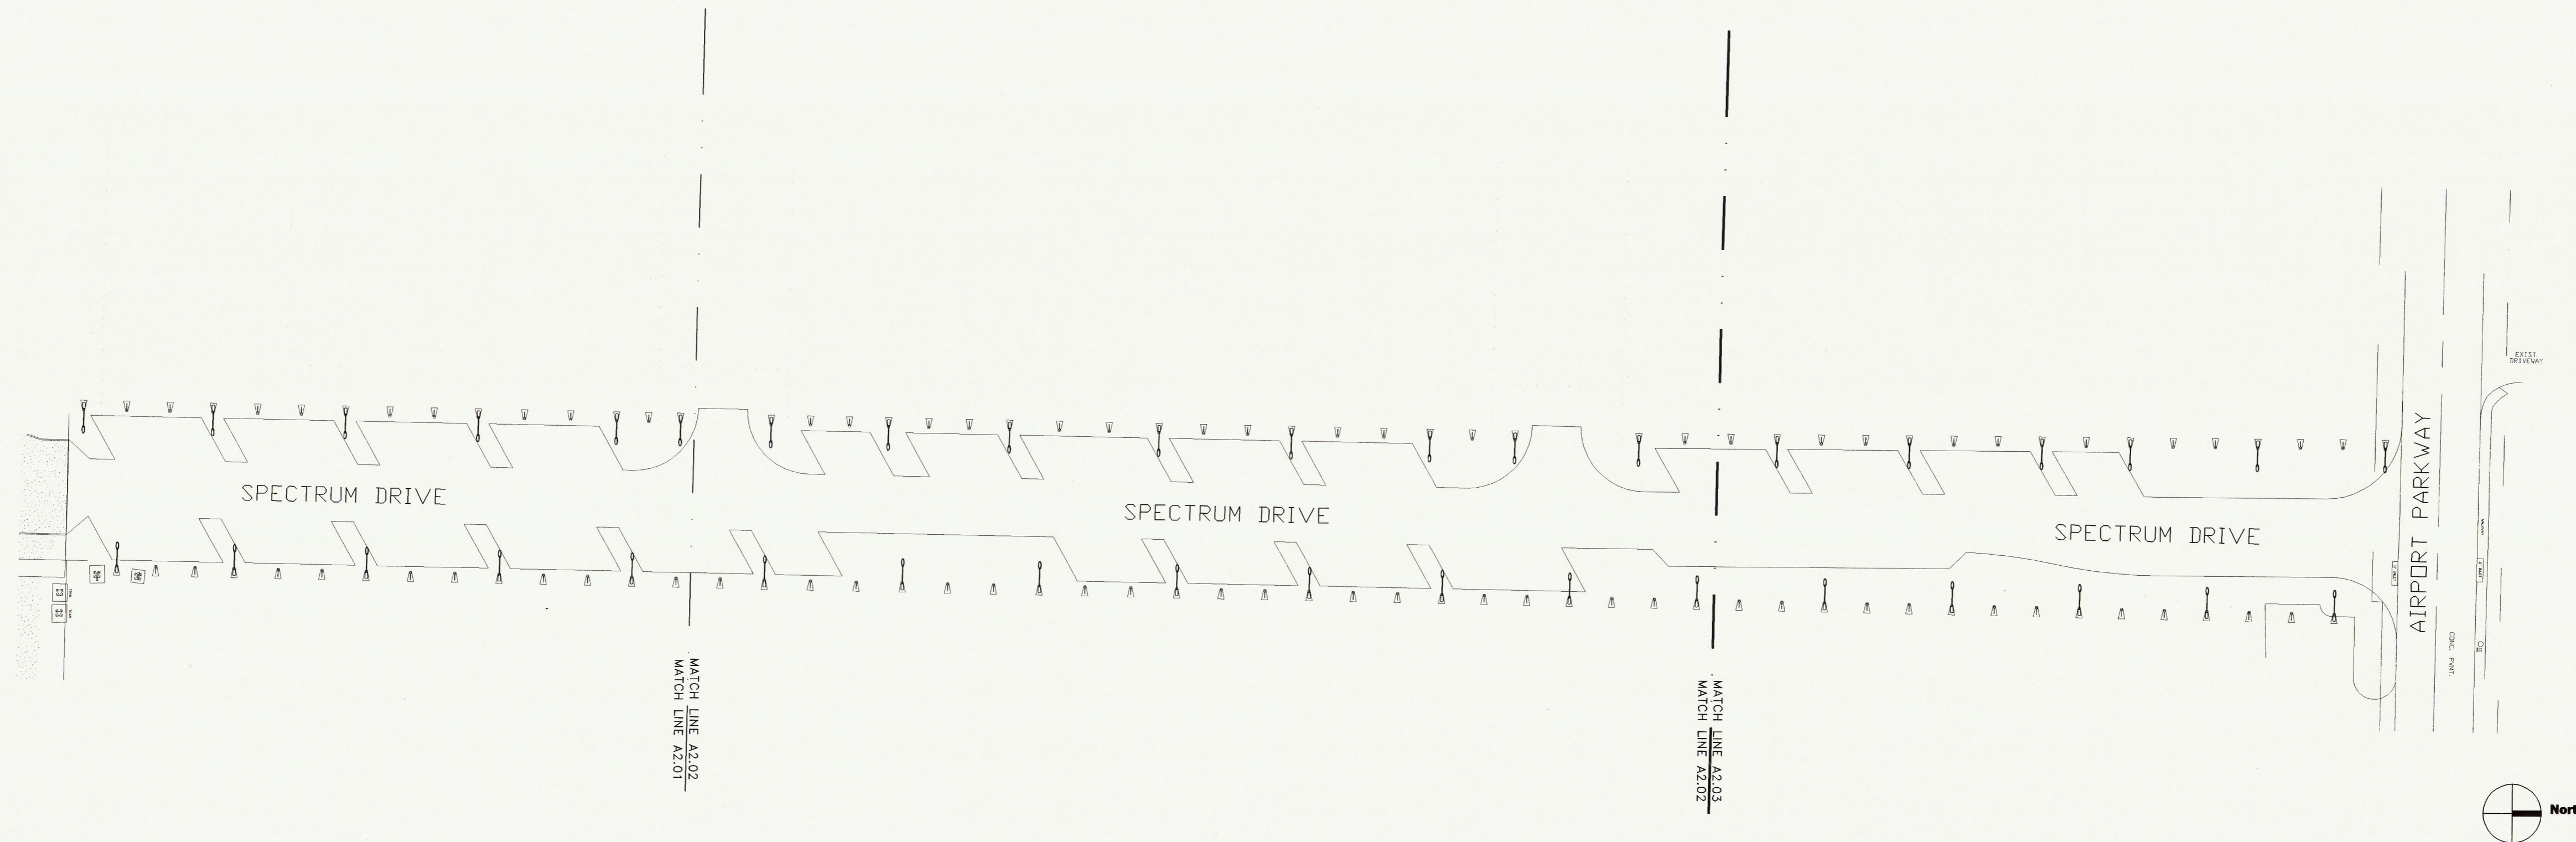

OVERALL STREET PLAN **01**
SCALE: 1" = 50'-0"

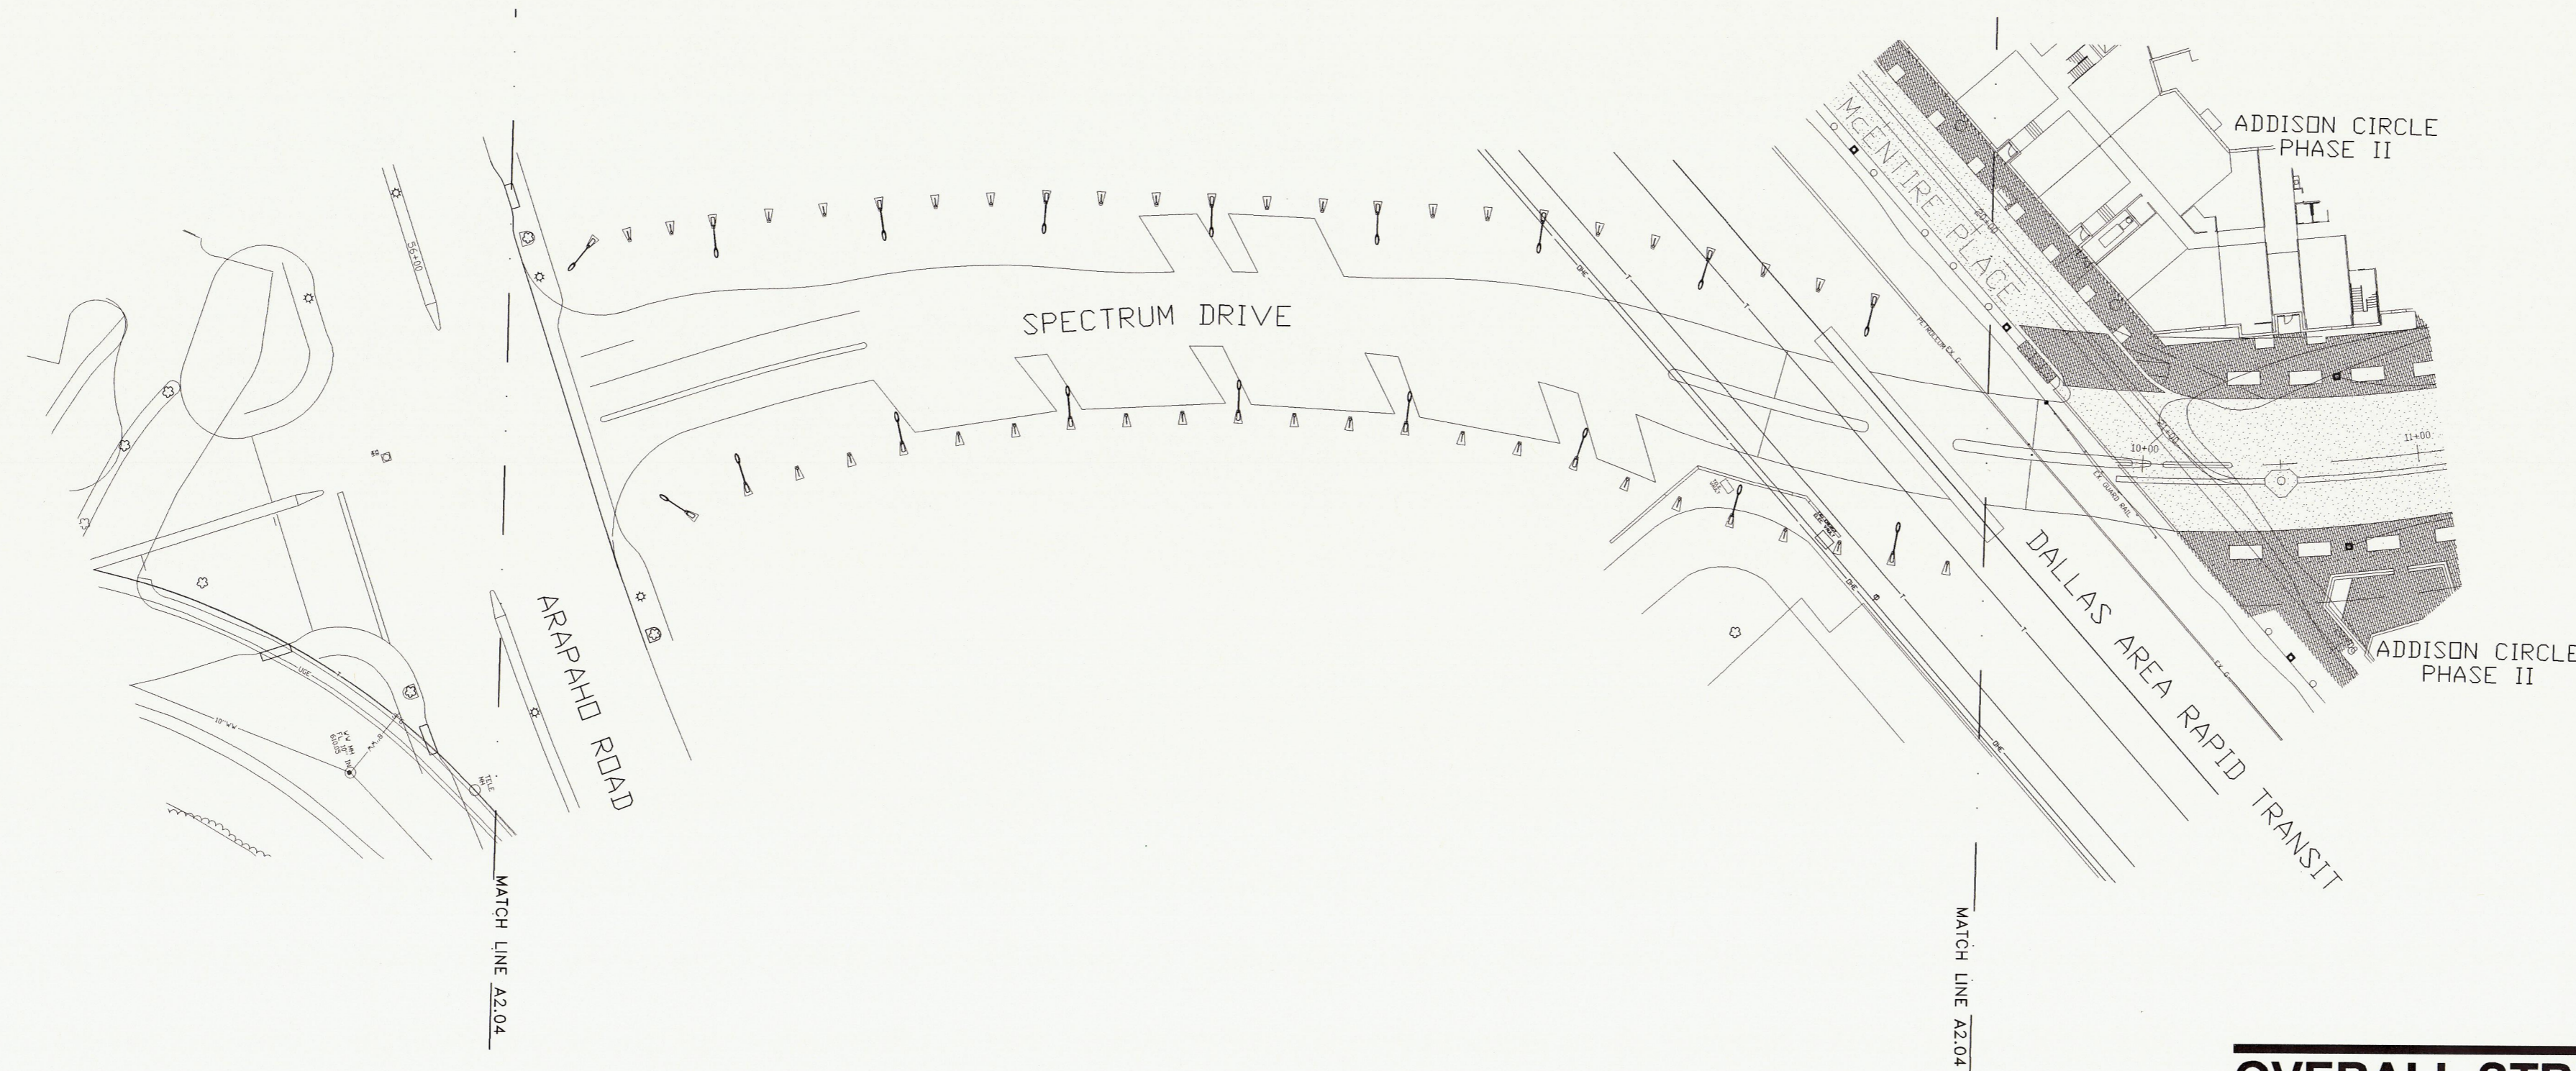

OVERALL STREET PLAN **02**
SCALE: 1" = 50'-0"

Issue	Date & Issue Description	By	Check
01	01/19/04 TOWN OFFICIALS REVIEW	RML	DB

Seal/Signature

 
Project Name
**TOWN OF ADDISON
LIGHTING MASTER PLAN - SPECTRUM DRIVE**

Project Number
27.3053.000

CAD File Name
K:27.3053.000/CAD/SHEETS/S-1-00.dwg

Description
LIGHTING PLAN
OVERALL MASTER PLAN

Scale



A1.00

©2003 Gensler