


Addison!®

**Gensler** Dallas  
 5430 LBJ Freeway  
 Suite 400  
 TX 75240  
 Telephone 214.273.1500  
 Facsimile 214.273.1505

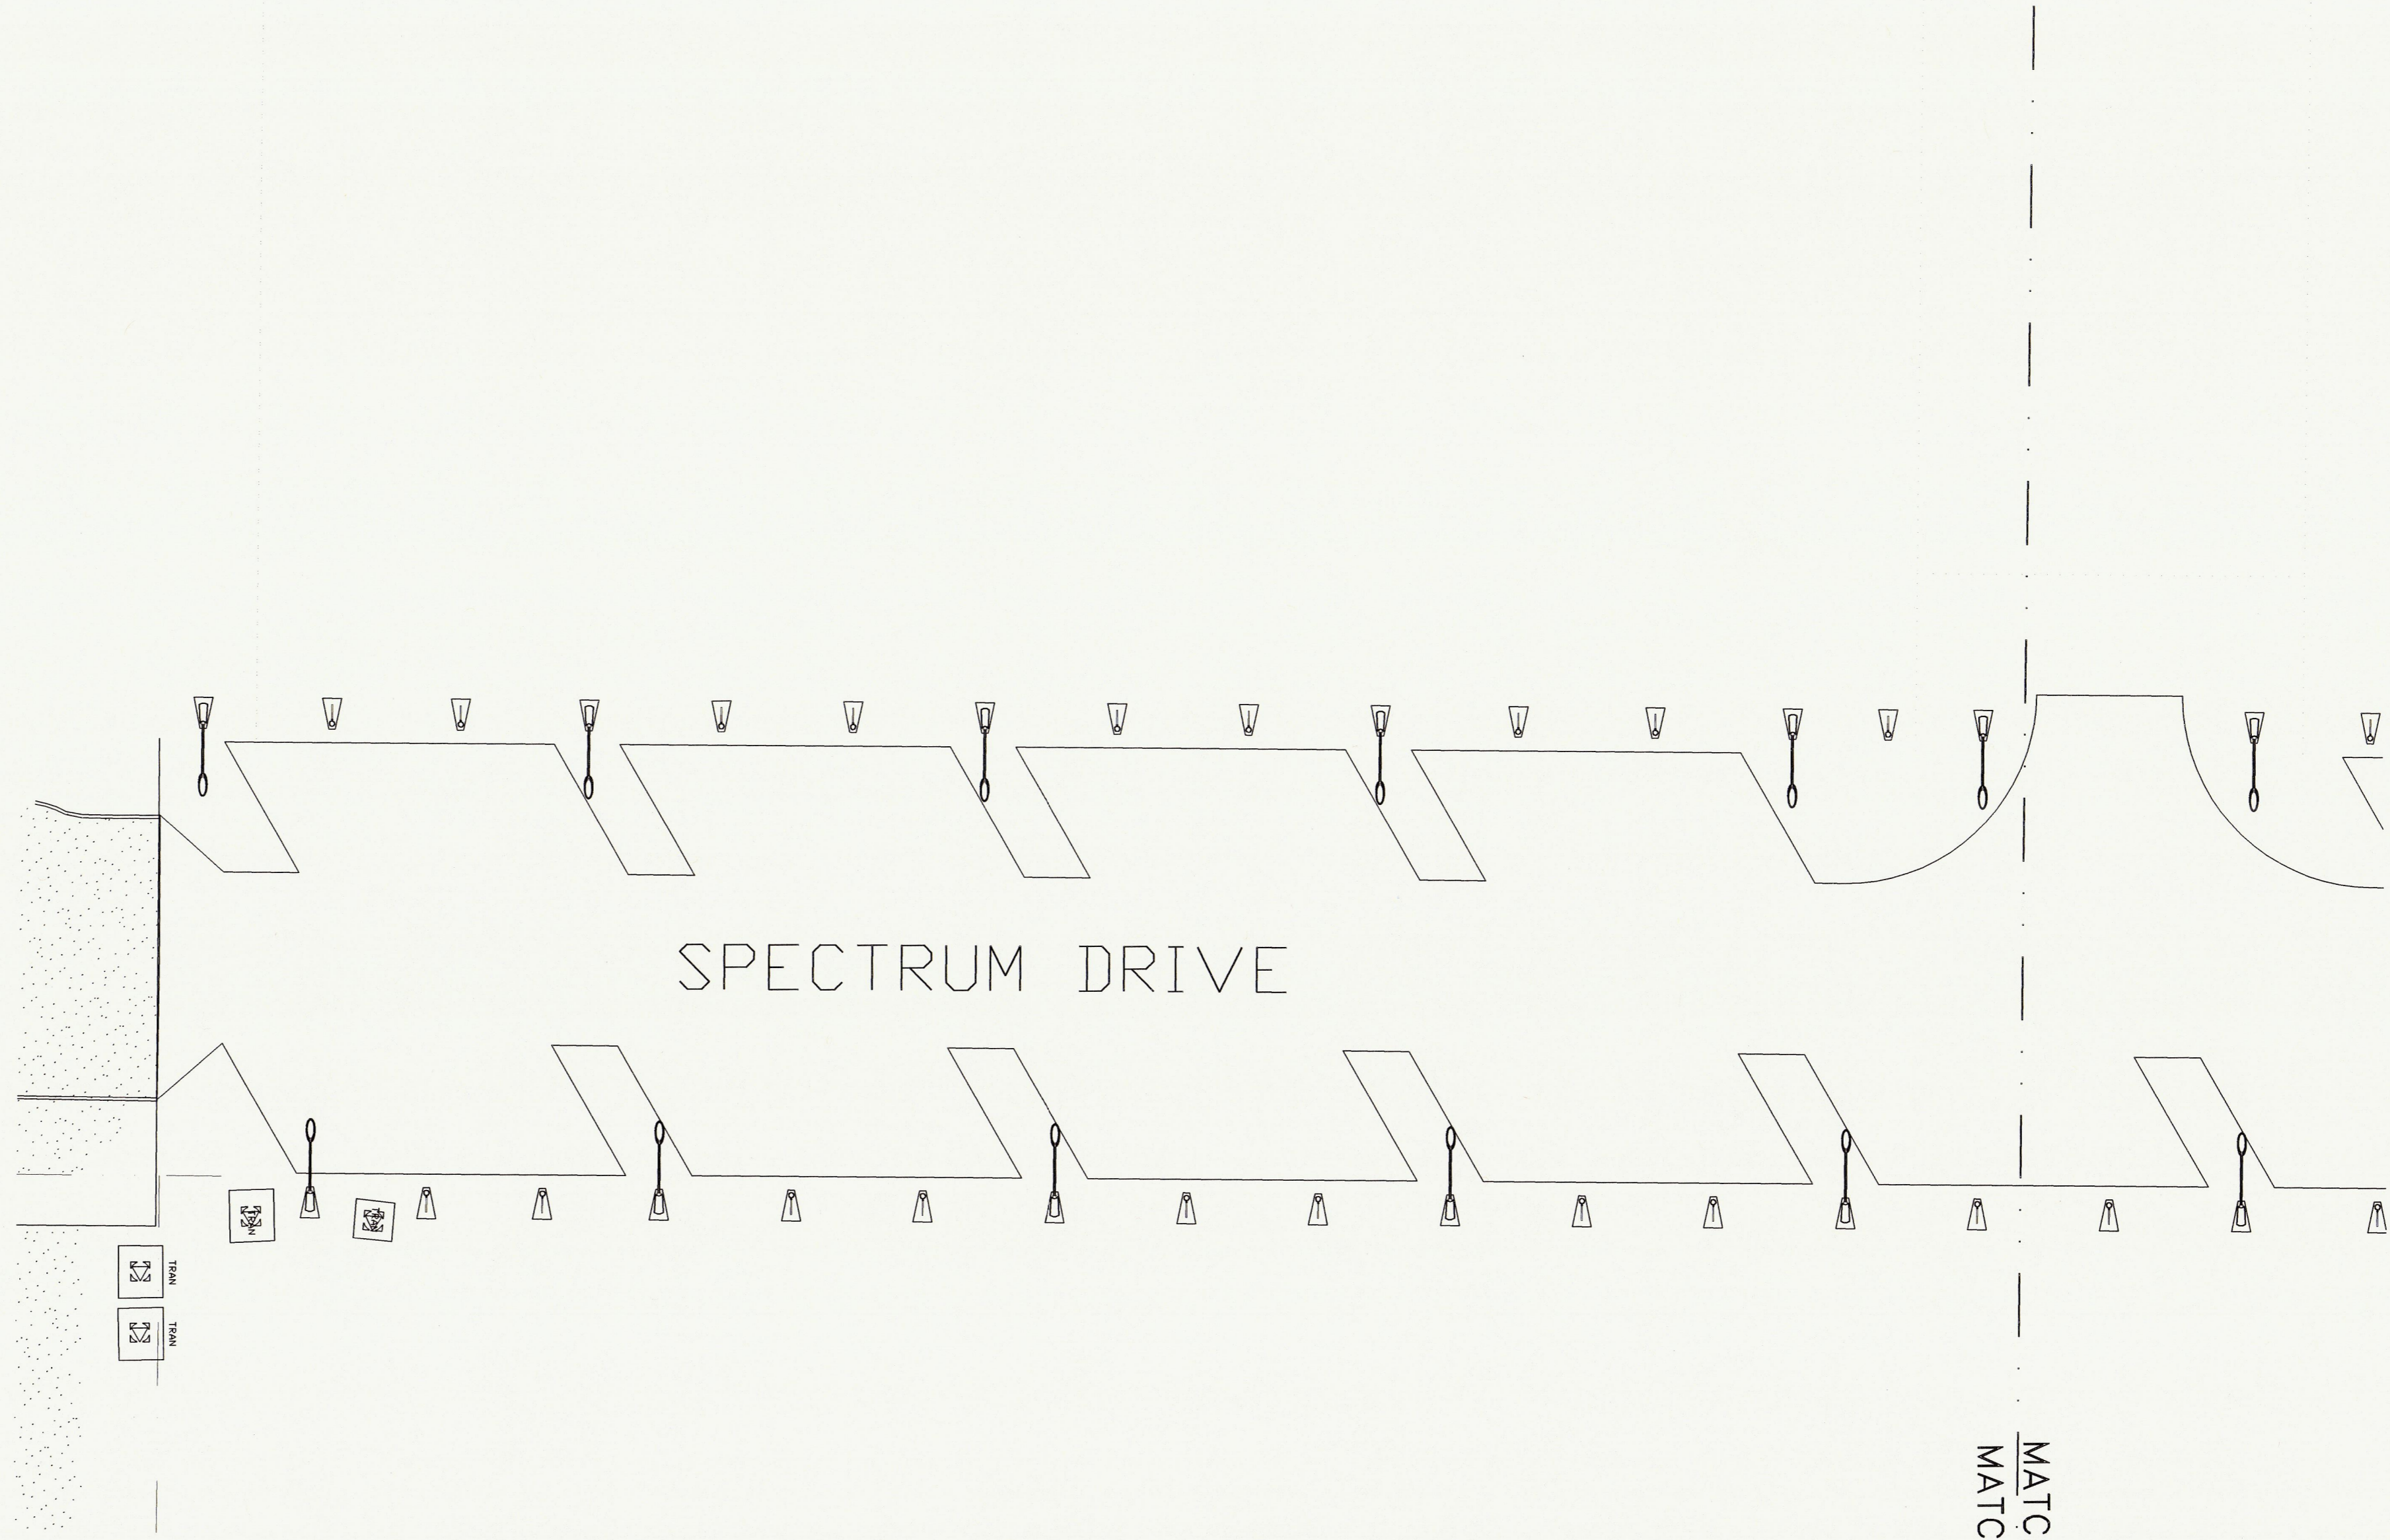

MATCH LINE A2.02  
 MATCH LINE A2.01

Issue	Date & Issue Description	By	Check
01	01/19/04 TOWN OFFICIALS REVIEW	RML	DB

Seal/Signature

 
Project Name  
 TOWN OF ADDISON  
 LIGHTING MASTER PLAN - SPECTRUM DRIVE

Project Number  
 27.3053.000

CAD File Name  
 K:27.3053.000/CAD/SHEETS/S-2-01.dwg

Description  
 LIGHTING PLAN  
 PART ONE

Scale



**A2.01**

**ENLARGED PLAN - PART 1**  
 SCALE: 1" = 20'-0"

**01**

© 2003 Gensler