


Addison!®

Gensler
 5430 LBJ Freeway
 Suite 400
 Dallas TX 75240
 Telephone 214.273.1500
 Facsimile 214.273.1505

Issue	Date & Issue Description	By	Check
01	01/19/04 TOWN OFFICIALS REVIEW	RML	DB

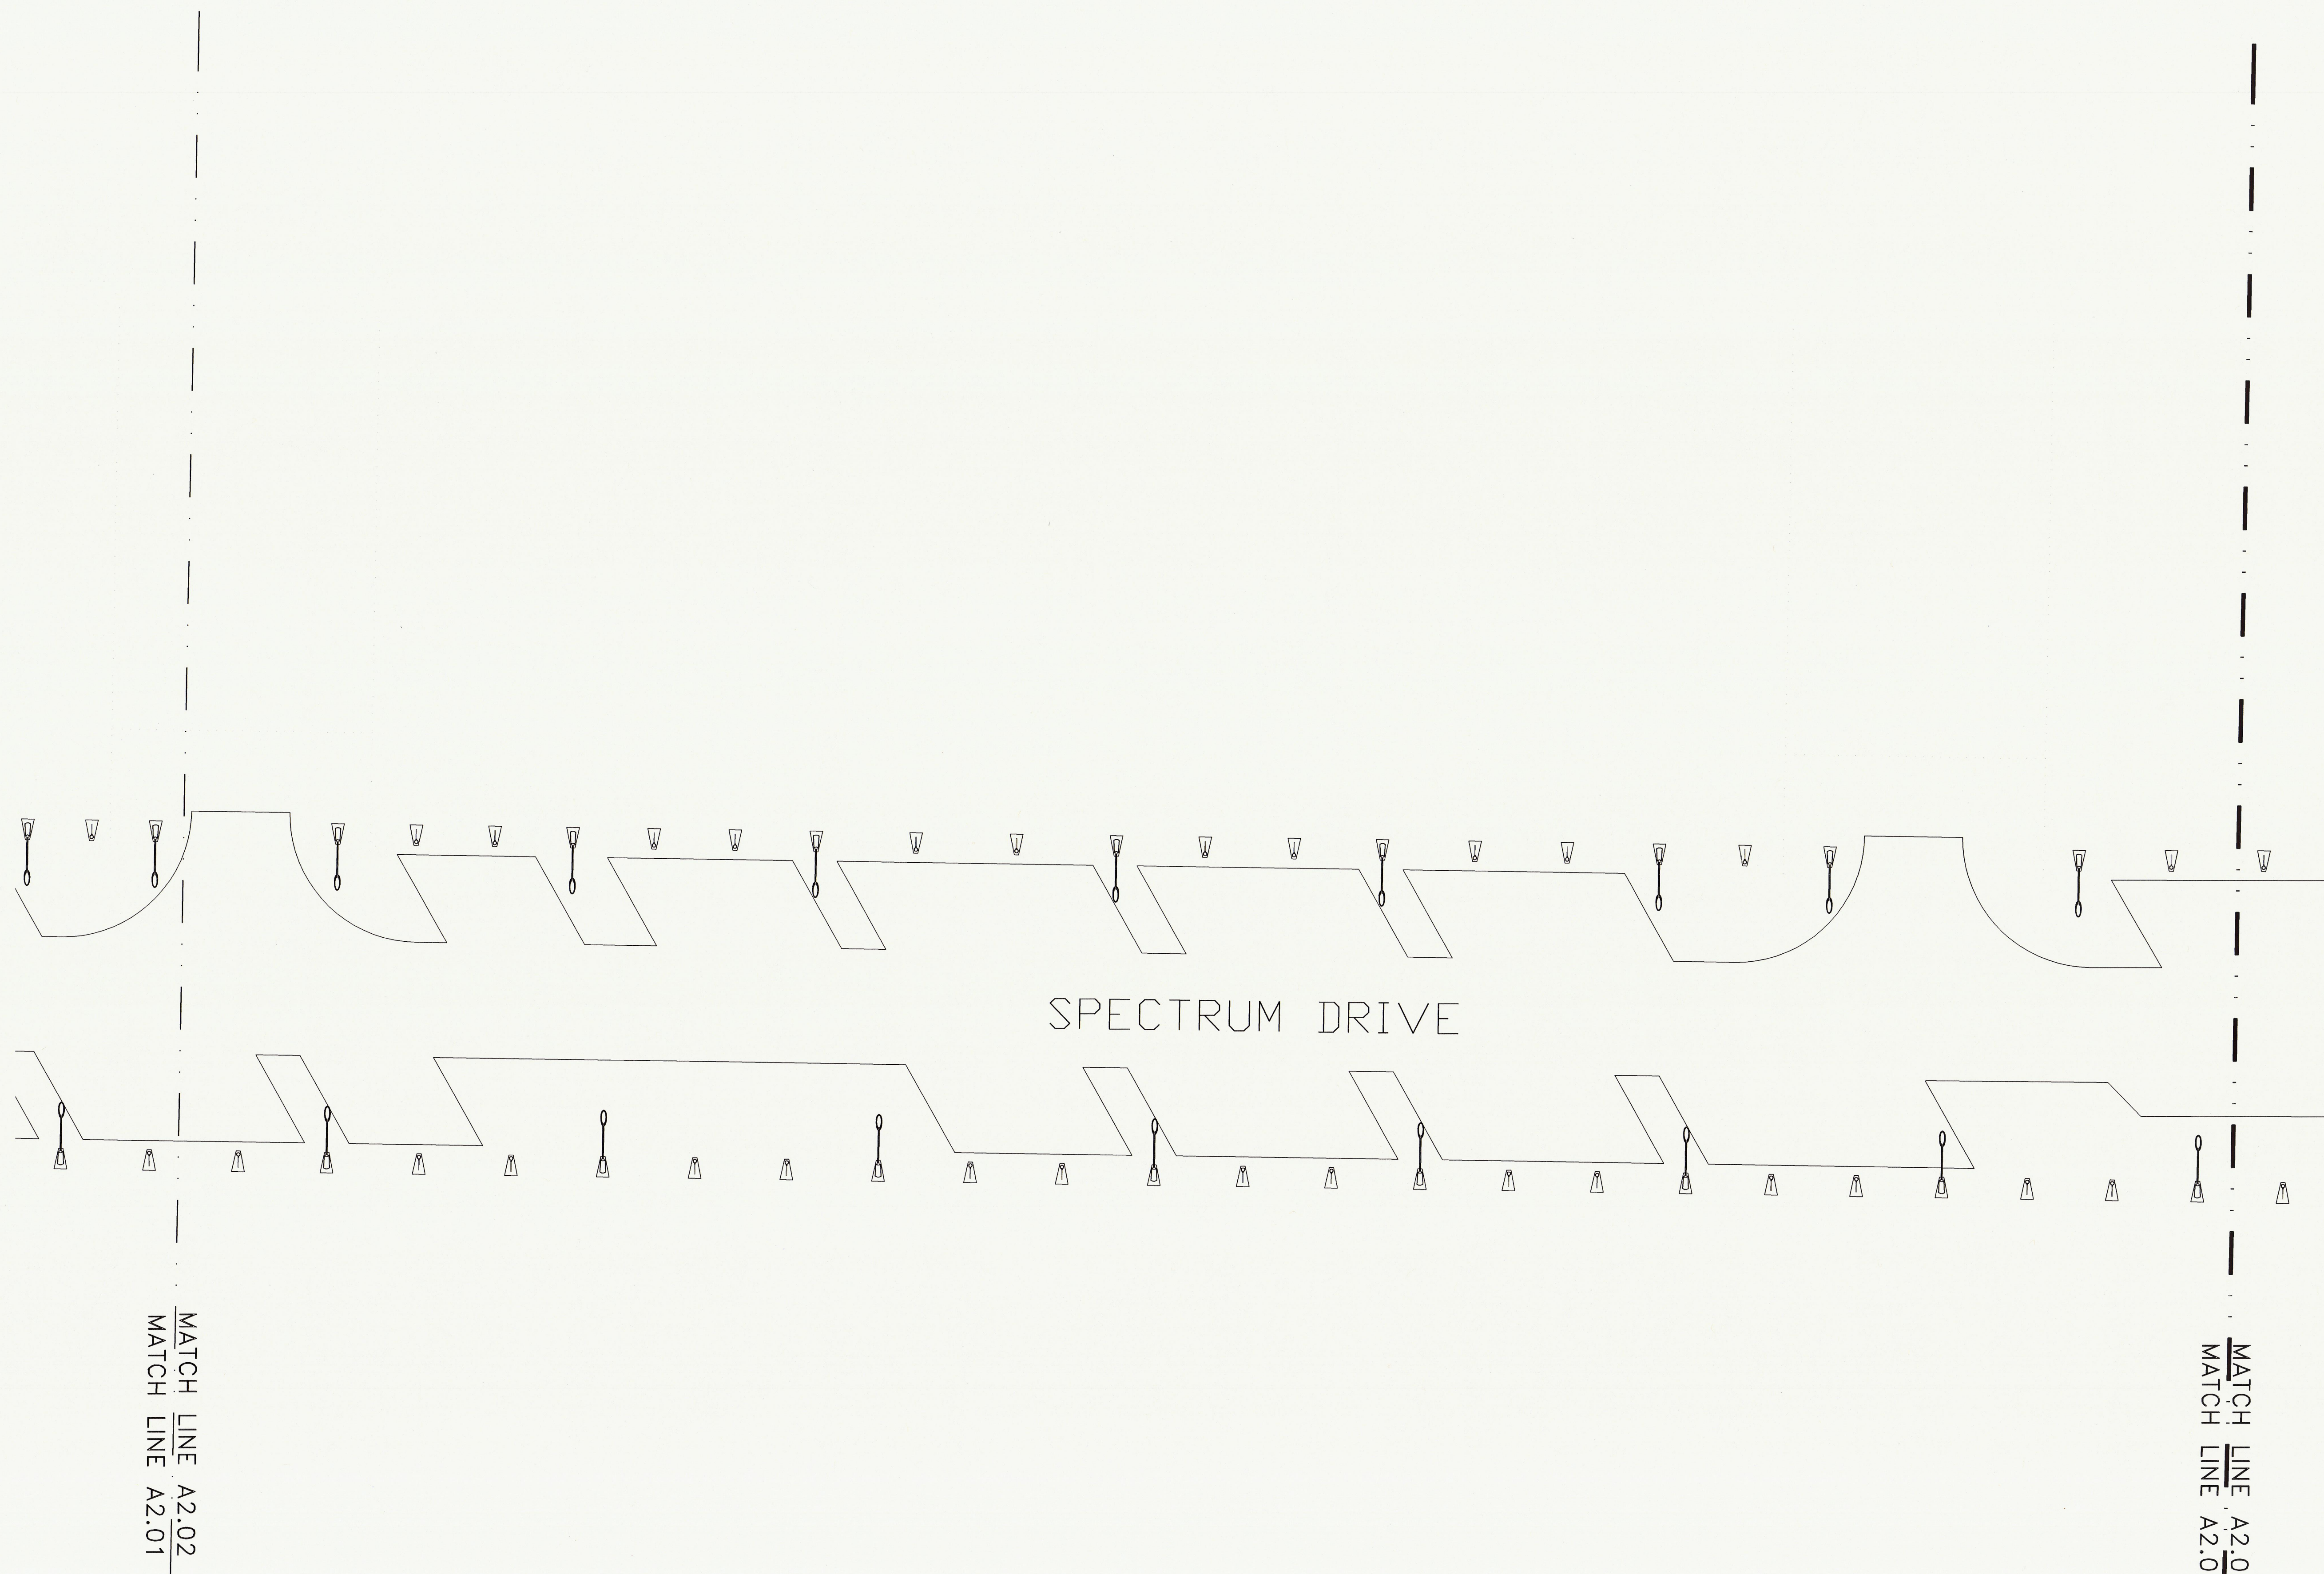

MATCH LINE A2.02
 MATCH LINE A2.01

MATCH LINE A2.03
 MATCH LINE A2.02

 
Project Name
 TOWN OF ADDISON
 LIGHTING MASTER PLAN - SPECTRUM DRIVE

Project Number
 27.3053.000

CAD File Name
 K: 27.3053.000/CAD/SHEETS/S-2-02.dwg

Description
 LIGHTING PLAN
 PART TWO

Scale



A2.02

ENLARGED PLAN - PART 2
 SCALE: 1" = 20'-0"

01

©2003 Gensler