

Addison!®

5430 LBJ Freeway
Suite 400
Dallas TX 75240
Telephone 214.273.1500
Facsimile 214.273.1505

Gensler

Issue	Date & Issue Description	By	Check
01	01/13/04 TOWN OFFICIALS REVIEW	RML	DB

Seal/Signature

 
Project Name
TOWN OF ADDISON
LIGHTING MASTER PLAN - SPECTRUM DRIVE

Project Number
27.3053.000

CAD File Name
K:27.3053.000/CAD/SHEETS/S-2-04.dwg


Description
LIGHTING PLAN
PART FOUR

Scale



A2.04

©2003 Gensler

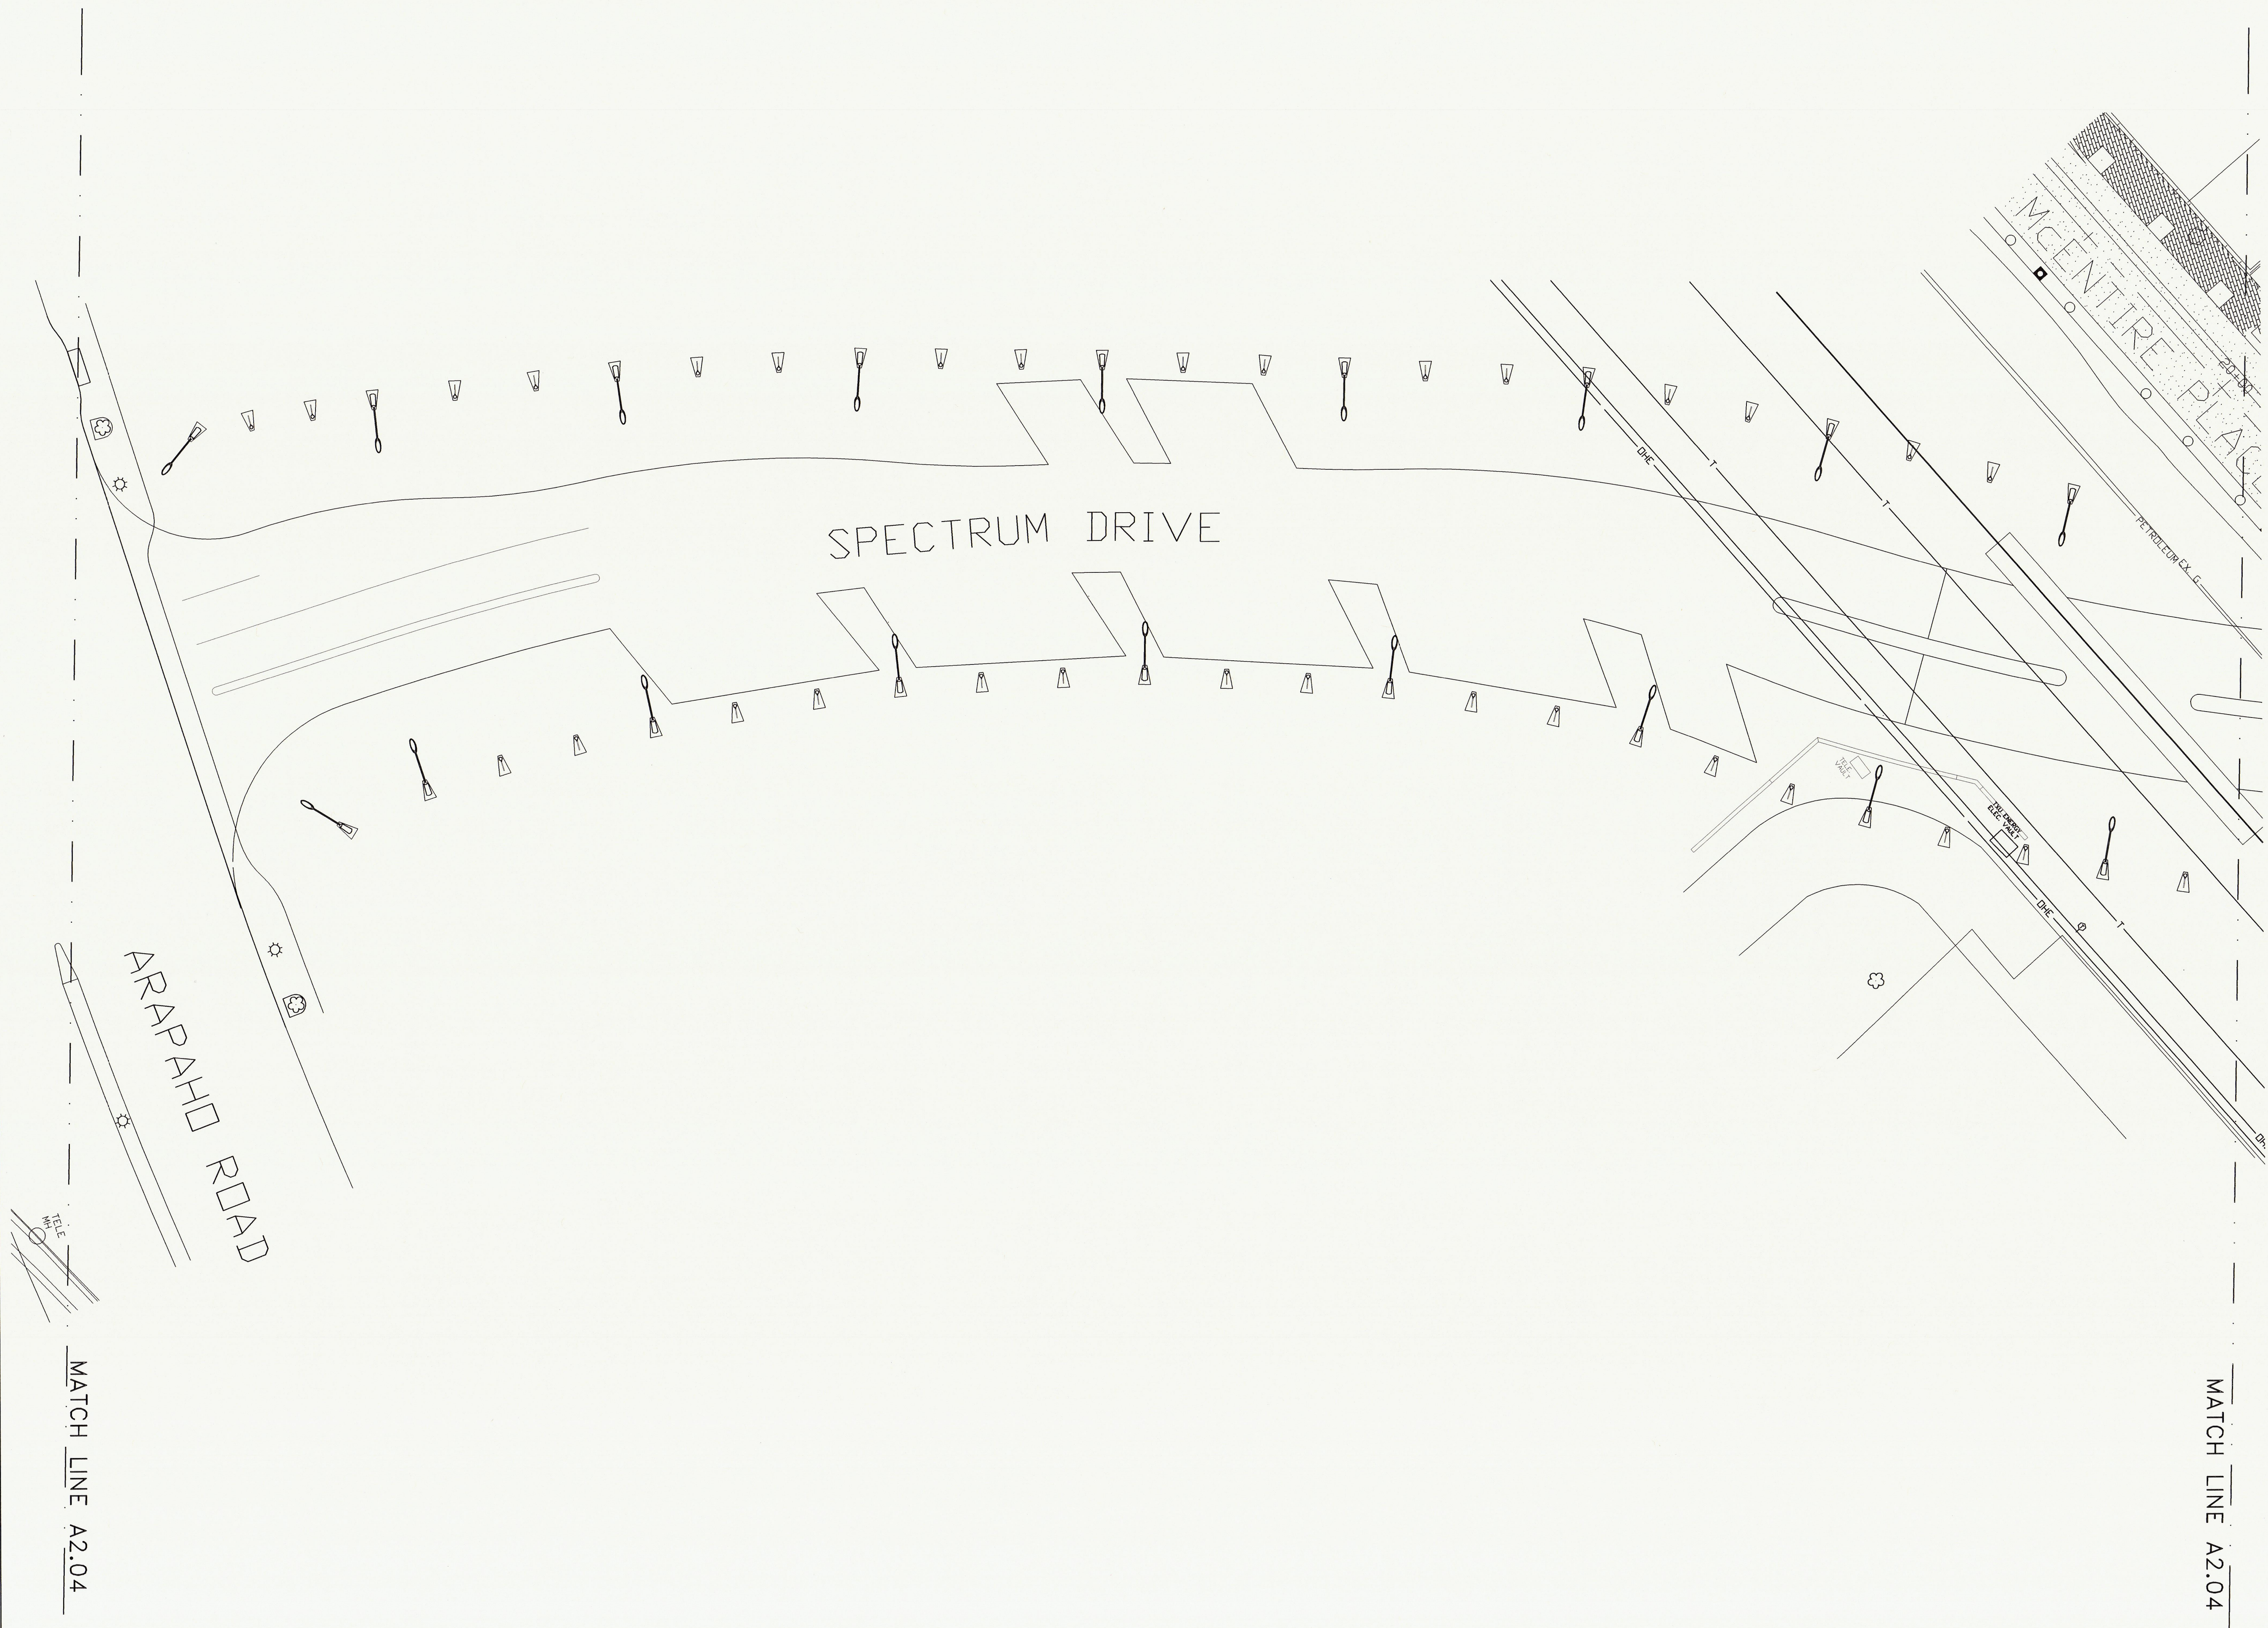

ENLARGED PLAN - PART 4
SCALE: 1" = 20'-0"

01