


NOTE:
UTILITY CONTR. TO RUN
4" WATER LINE AND
PROVIDE 3-2" SERVICE
LINES FOR 3-2" WATER
MTRS

PLUMBING SYMBOLS	
SYMBOL	DESCRIPTION
	EXISTING SANITARY SEWER MAIN
	EXISTING WATER MAIN
	NEW CITY WATER METER
	SANITARY SEWER LINE
	SANITARY SEWER VENT
	DOMESTIC COLD WATER SPLY. LINE
	DOMESTIC HOT WATER SPLY. LINE
	DOMESTIC HOT WATER RUN. LINE
	VALVE BOX (H.W. AND C.W. SHUT OFF VALVES)
	DOUBLE CHECK ASSEMBLY SET IN BOX
	EXISTING GAS MAIN
	GAS SPLY. LINE (LOW PRESS.)
	GAS SPLY. LINE (HIGH PRESS.)
	GAS METER
	GAS REGULATOR
	GAS STOP (GLOBE VALVE)
	GATE VALVE
	CHECK VALVE
	BALANCING VALVE
	ONE WAY SAN. SWR. CLEAN OUT
	TWO WAY SAN. SWR. CLEAN OUT
	WALL CLEAN OUT
	HOSE BIBB
	FLOOR DRAIN
	TEMP. PRESS. AND RELIEF VALVE
	HOT WATER DISCHARGE LINE
	UNION

- PLUMBING SPECIFICATIONS
- GENERAL CONTRACTOR:
- To provide all cutting, patching, painting, rock removal, concrete work, access doors, (if required)
 - To pay all pro rata charges.
 - To pay any additional costs if a man hole is required by city authorities, in lieu of a sanitary sewer tap.
 - To instruct cabinet manufacturer to install all lavatories and kitchen sinks, (to be furnished by plumber)
 - To pay any costs required to install temporary water meters or temporary gas meters for construction use only.
- HVAC AND AIR CONDITIONING CONTRACTOR:
- To furnish and install all piping from condensate drain on unit to drain provided by plumber.
 - To make all final connections required for unit.
- PLUMBING CONTRACTOR:
- To furnish and install a complete plumbing system to conform to city code requirements.
 - To pay all sanitary sewer tap fees and all water meter installation fee required.
 - To pay for gas meter installation, (if required)
 - Materials in General:
 - INSULATION:
 - Insulate all water piping in exterior walls and in attic spaces.
 - INSULATE - FIRE, HOWEVER, ONLY WITH THICK DEATHENED INS.
 - SANITARY SEWER:
 - ALL UNDERGROUND HORIZ. PIPING TO BE CAST IRON.
 - ALL RISERS & VERT. PIPING TO BE PVC PIPE.
 - DOMESTIC WATER PIPE:
 - ALL UNDERGROUND COLD WATER OUTSIDE BLDGS TO BE M. H. HARD COP.
 - ALL CIRC. HW. & PIPING ABOVE GROUND TO BE M. H. HARD COP PIPE.
 - ALL DRING UNDER BLDGS TO BE 1" SPT. COP. PIPE.
 - GAS PIPE:
 - UNDERGROUND - TO BE POLYETHYLENE PIPE
 - ABOVE GROUND TO BE SCHED. 40 STEEL PIPE
 - OTHERS:
 -
 -
 -
 - WATER HEATERS:
 -
 -
 -
 - FIXTURE TYPE AND ROUGH IN MEASUREMENTS:

	TYPE	DRAIN	WATER
1.	WATER CLOSET	12"	6"
2.	ELMET. WATER CLOSET	12"	6"
3.	LAVATORIES COUNTERTOP	12"	18"
4.	LAVATORIES WALL HUNG	12"	18"
5.	BATHTUBS	VERIFY	VERIFY
6.	KITCHEN SINKS	18"	18"
7.	BATH SINKS	12"	18"
8.	WASHERS	32"	32"
9.	URINALS	VERIFY	VERIFY

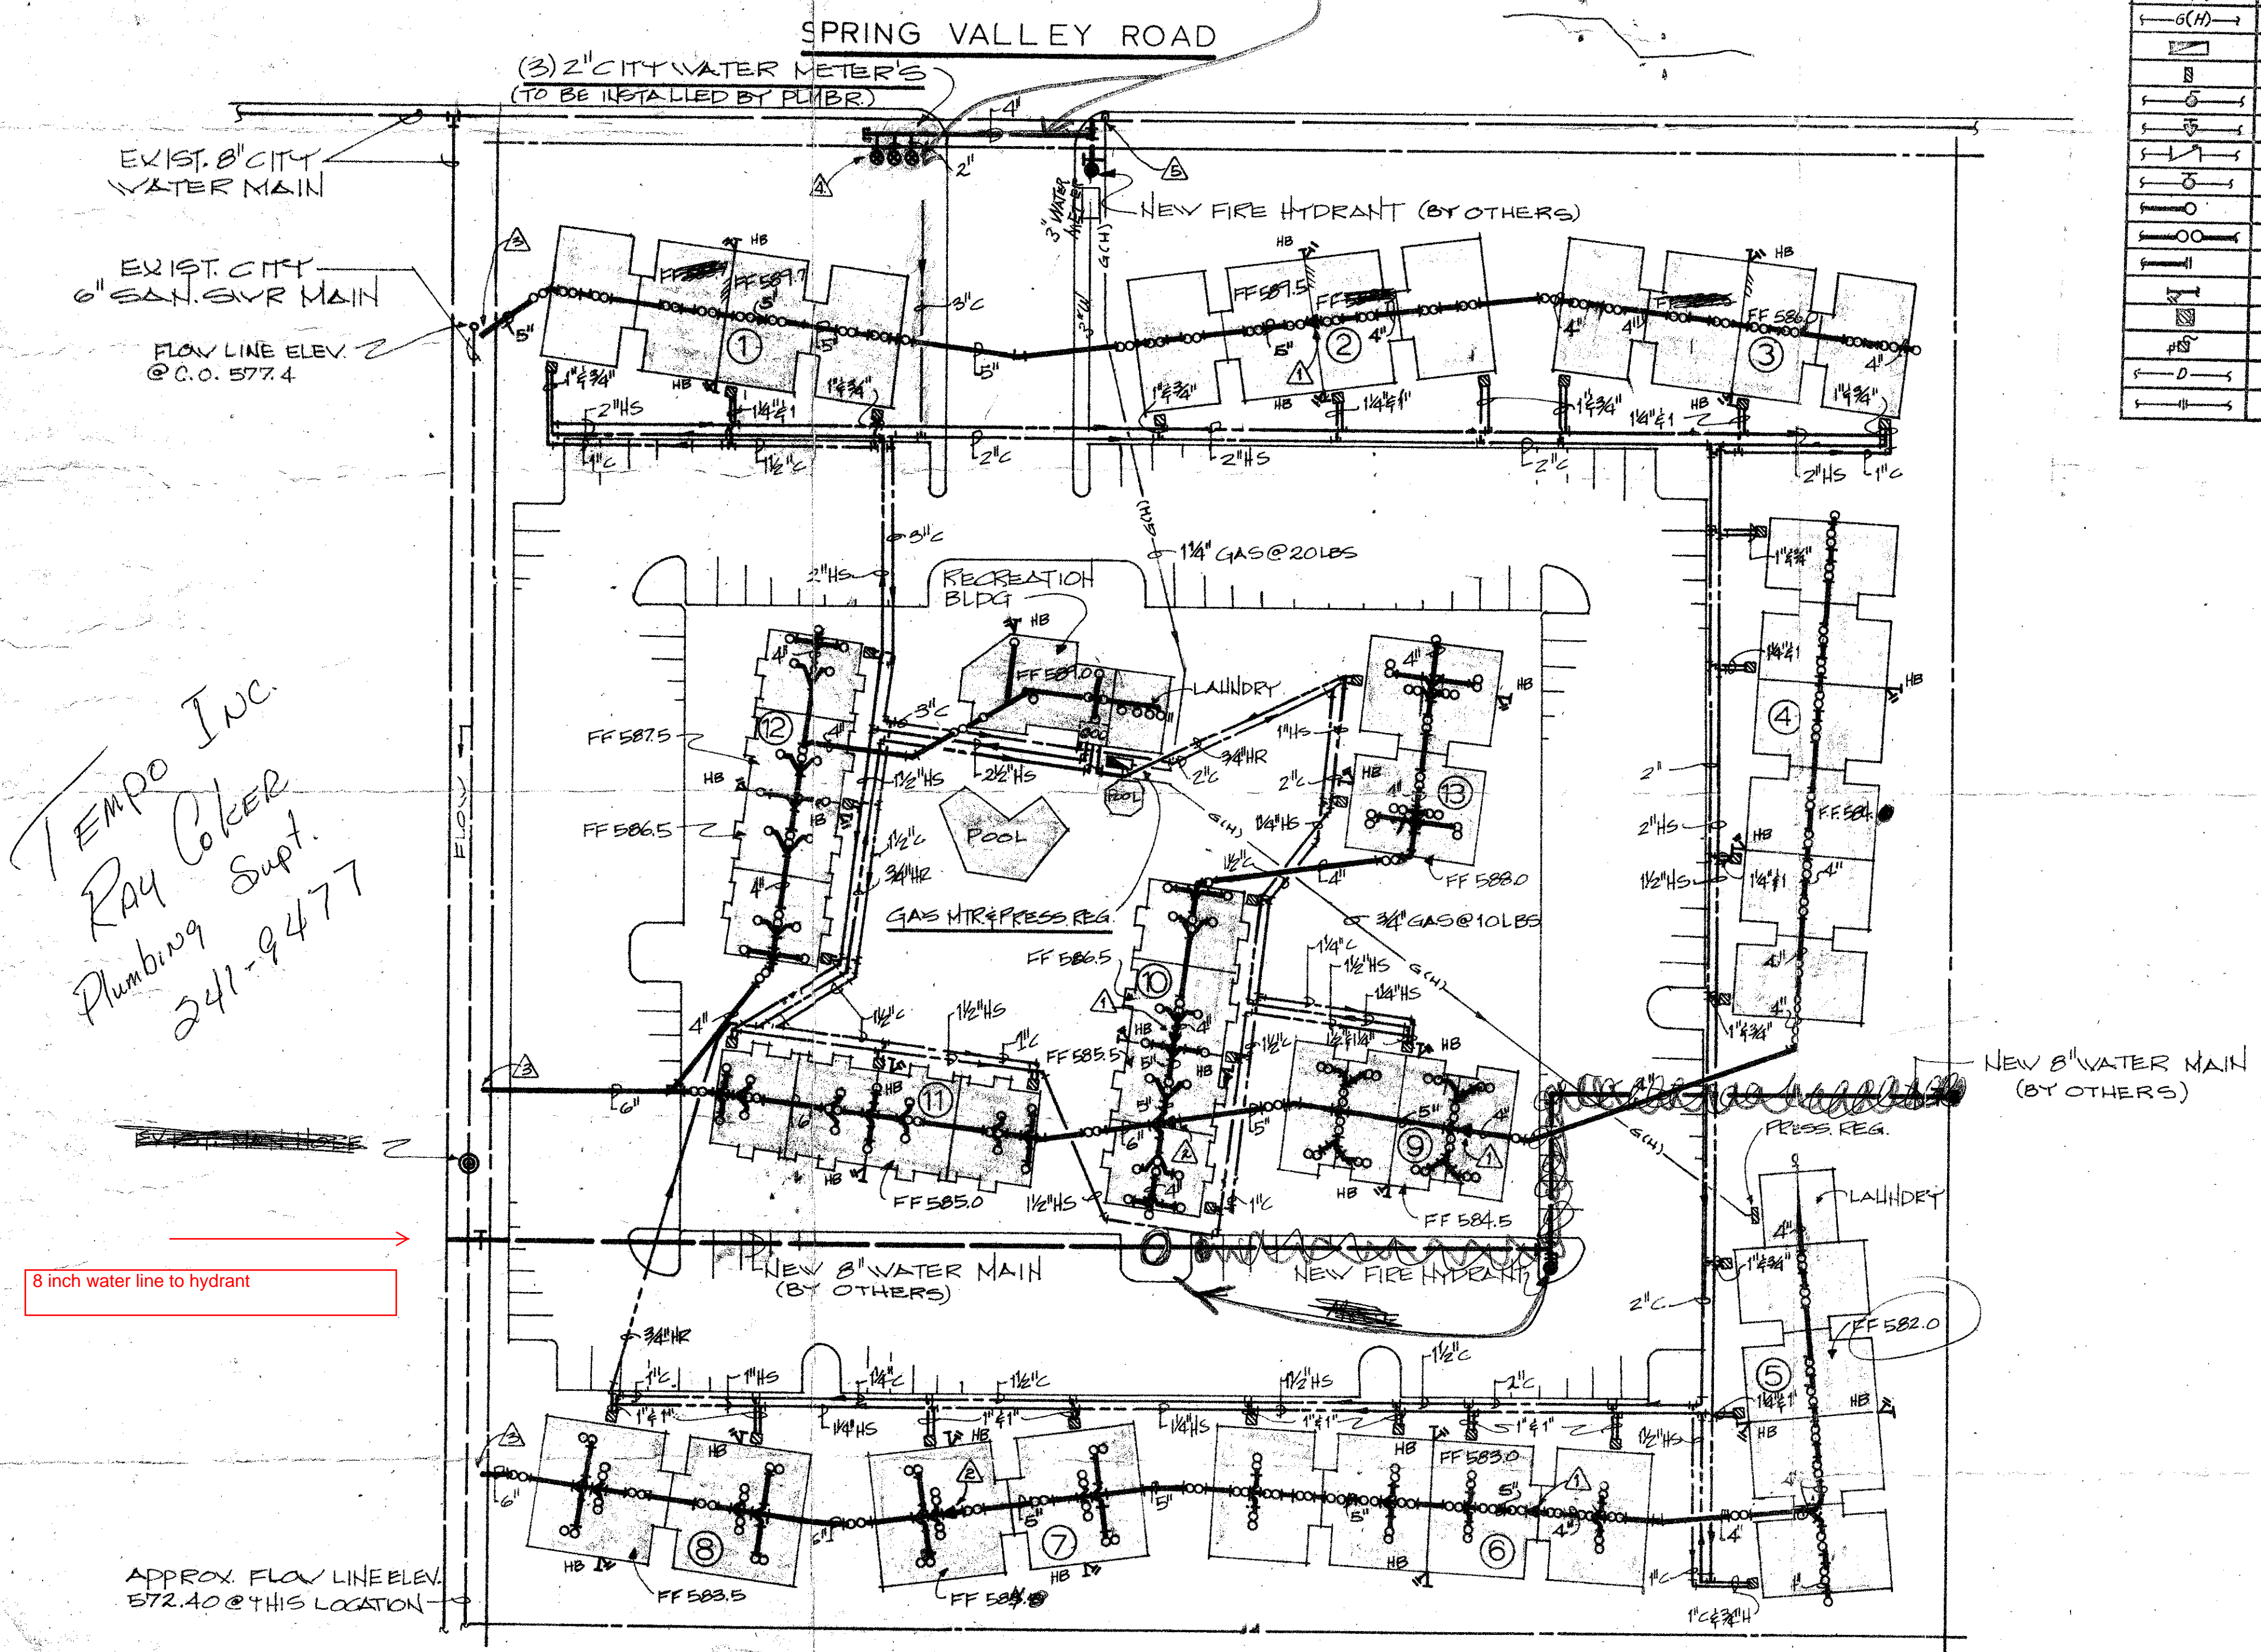

TEMPO INC.
RAY COLKER
Plumbing Supt.
241-9477

PLUMBING SITE PLAN SCALE: 1"=40'-0" NORTH

- NOTES:
- INSTALL 6"x4" REDUCER
 - INSTALL 6"x6" REDUCER
 - PLUMBER TO MAKE ALL SAN. SWR. TAPS AND FINAL CONNECTIONS INTO CITY SAN. SWR. MAIN
 - PLUMBER TO INSTALL ALL WATER METER'S (CITY OF ADDISON TO FURNISH MTRS)
 - PLUMBER TO RUN GAS LINE TO CURB AND TERMINATE, LOSE STAR GAS CO. TO MAKE FINAL CONNECTION INTO GAS MAIN

(Handwritten signatures and initials)

13

PLUMBING SITE PLAN		JOB NO.
		460-P
DATE 7-27-79		DWN. BY G.M.
CKD. BY		SCALE NOTED
DWC. NO.		1 OF 4

TEMPO, INC.
HVAC AND PLUMBING CONTRACTORS
2252 WISCONSIN ST., DALLAS, TEX. 75229
PHONE 214-241-9475