





JANI KING CALL CENTER  
4393 SUNBELT DRIVE  
ADDISON, TEXAS

TOILET ACCESSORY LEGEND	
TA1	SEMI-RECESSED PAPER TOWEL DISPENSER & WASTE RECEPTACLE; BOBRICK B-3942; 12 GAL.
TA2	SURFACE MOUNTED MULTI-ROLL TOILET TISSUE DISPENSER BOBRICK B-4288 SERIES
TA3	36" GRAB BAR BOBRICK B-6806 SERIES
TA4	42" GRAB BAR BOBRICK B-6806 SERIES
TA5	WALL MOUNTED SOAP DISPENSER BOBRICK - B-8221 SERIES
TA6	SURFACE MOUNTED SANITARY NAPKIN DISPOSAL (WOMEN'S) BOBRICK - B-270
TA7	24" X 36" FRAMED MIRROR BOBRICK - B-165 2436
TA8	48" X 36" FRAMED MIRROR BOBRICK - B-165 4836


\*SEE P2.01 AND P3.01 FOR PLUMBING FIXTURES

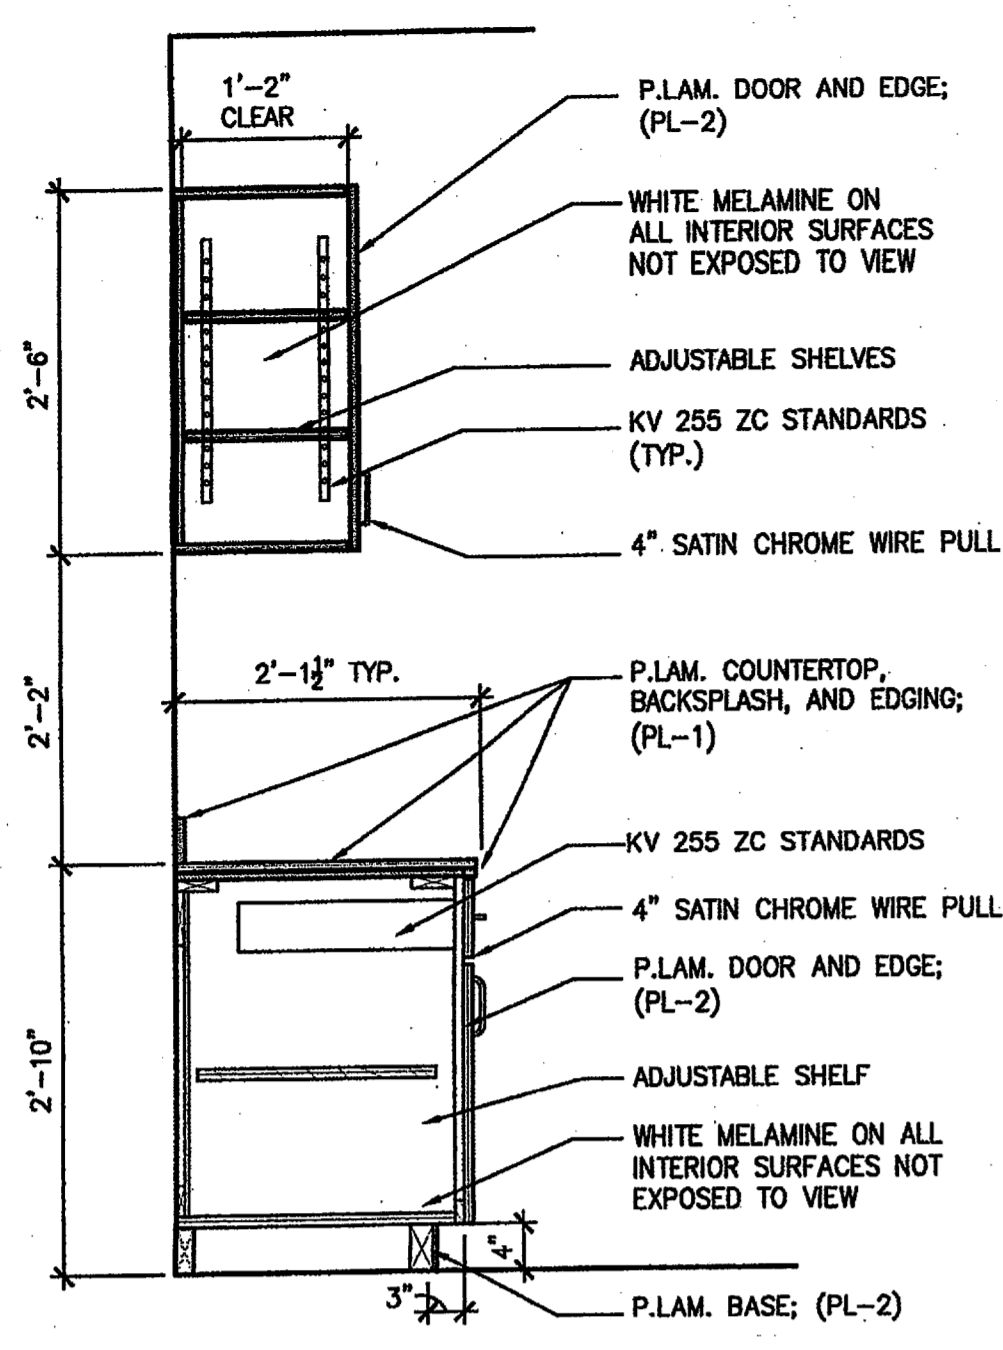

09 SECTION @ MILLWORK SCALE: 3/4" = 1'-0"

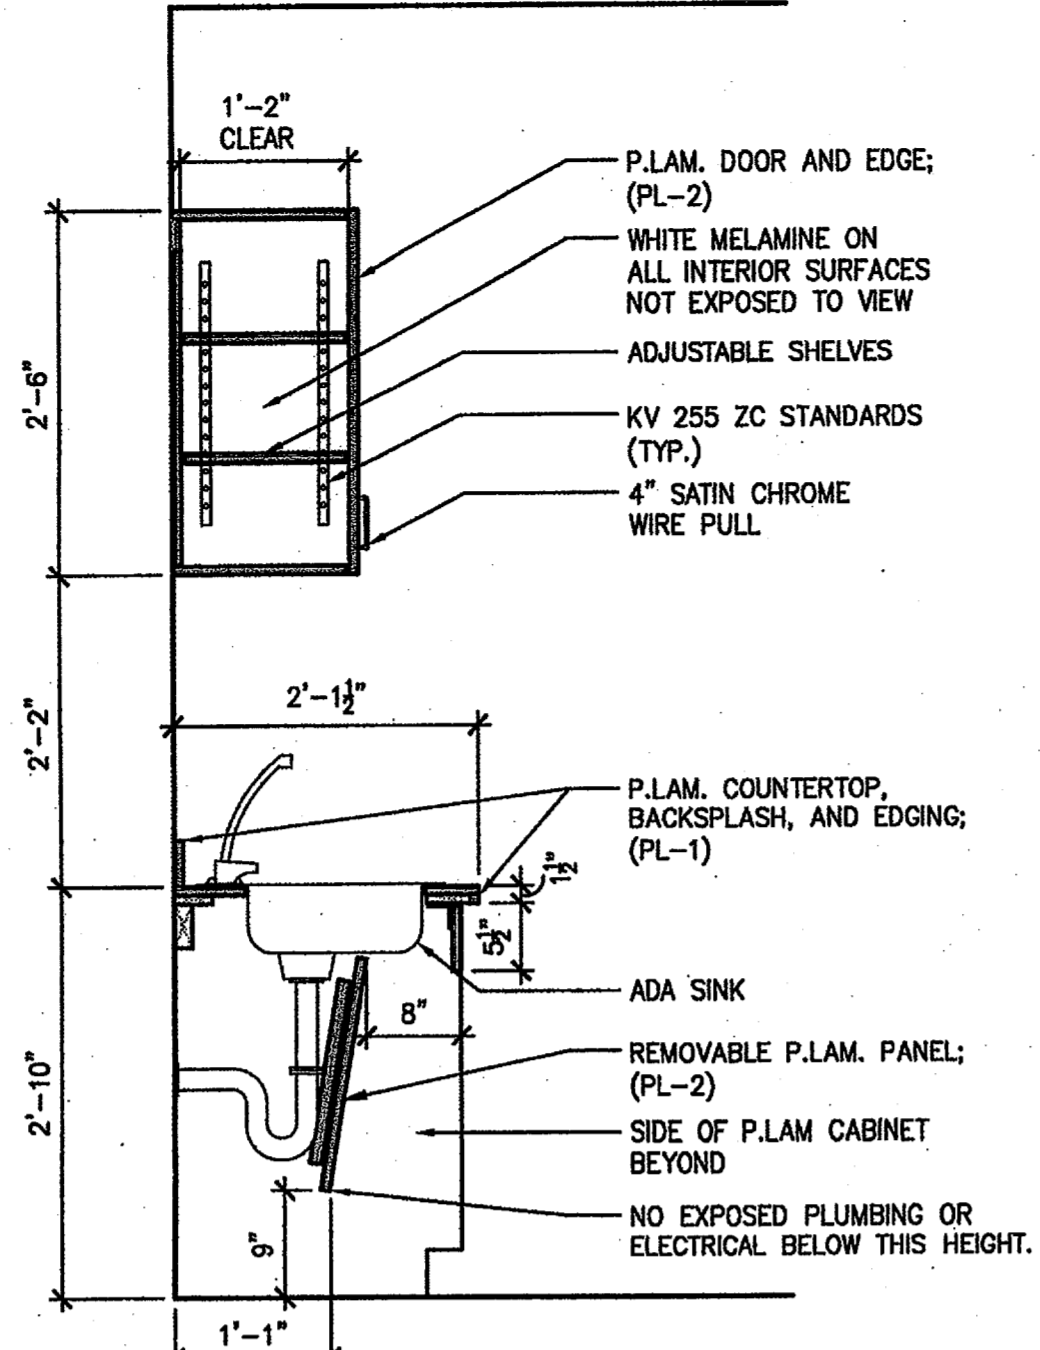


10 SECTION @ MILLWORK SCALE: 3/4" = 1'-0"

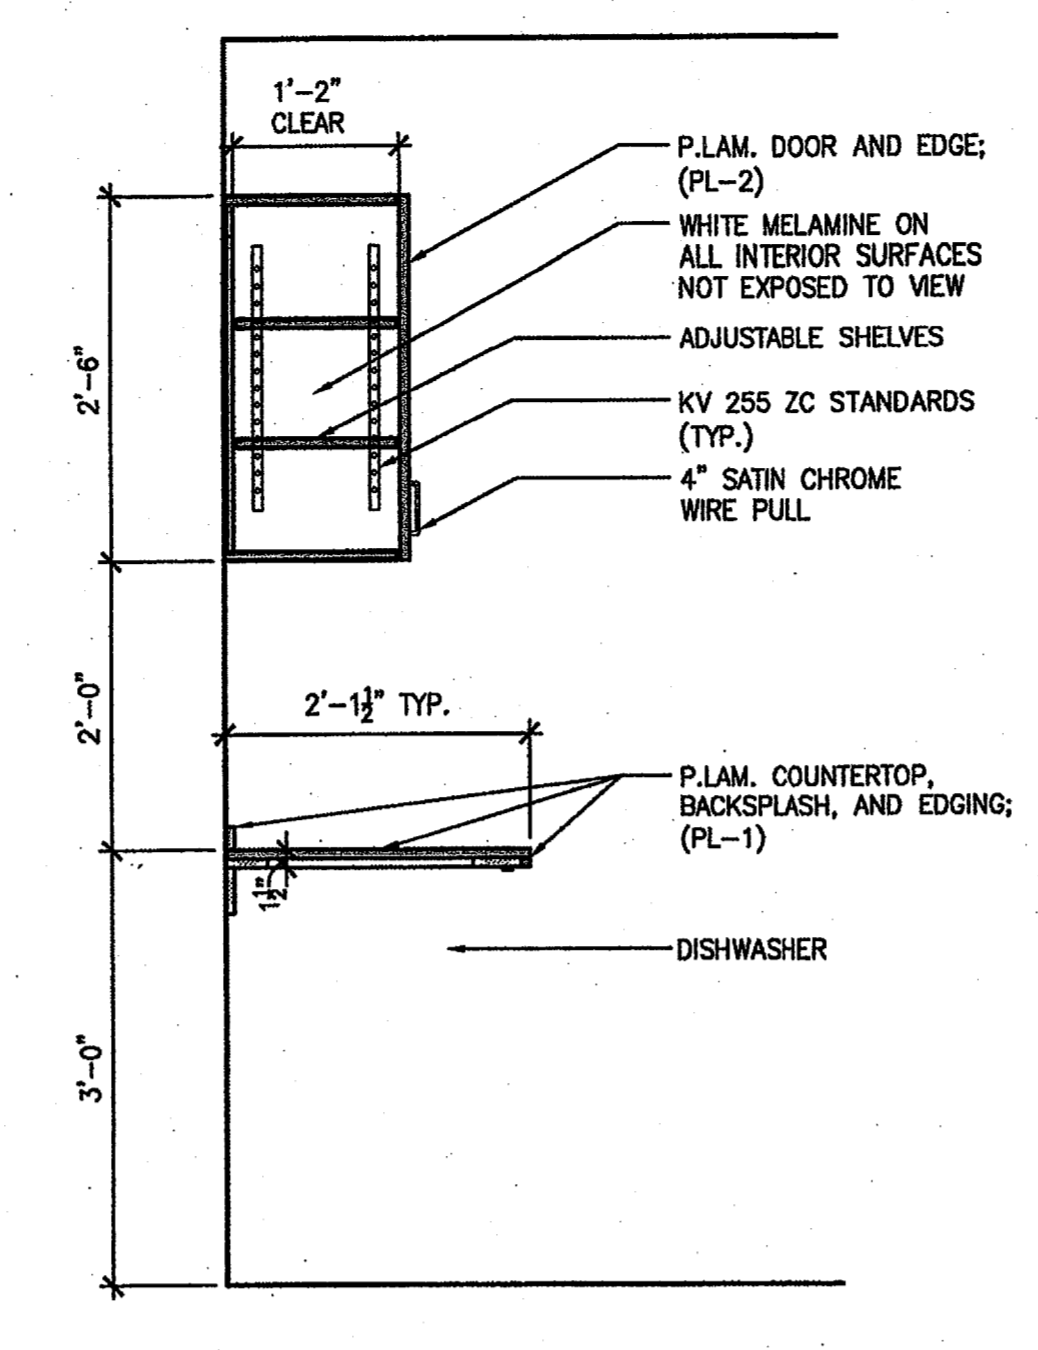

11 SECTION @ MILLWORK SCALE: 3/4" = 1'-0"

12 NOT USED

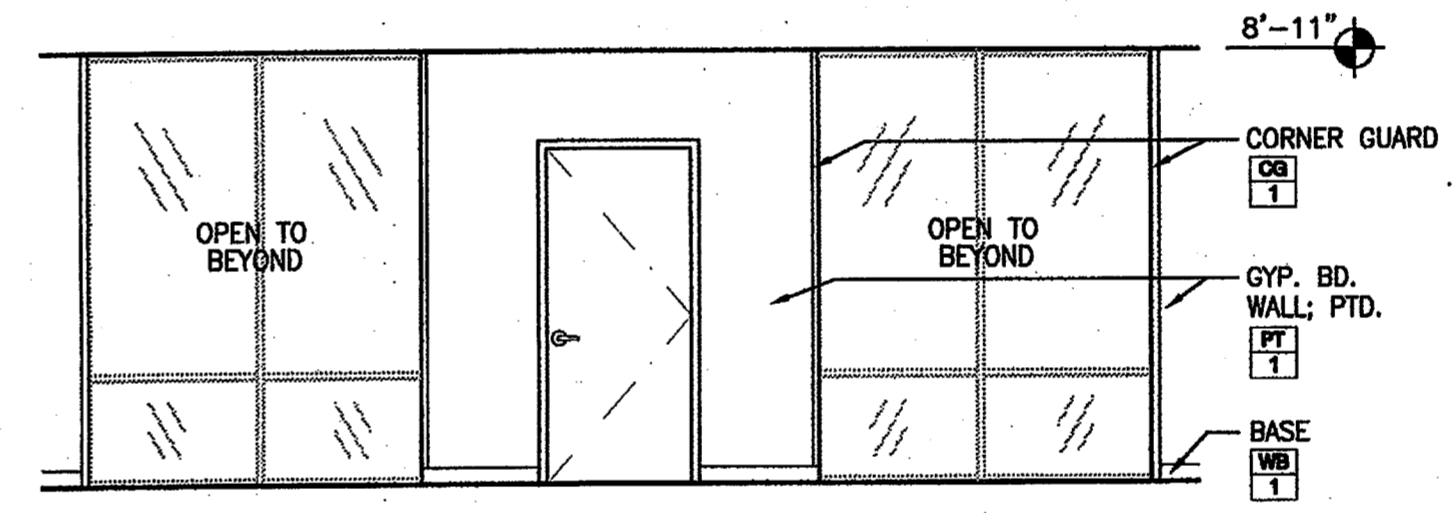


08 RECEPTION ELEV. SCALE: 1/4" = 1'-0"


05 NOT USED

06 NOT USED


07 NOT USED

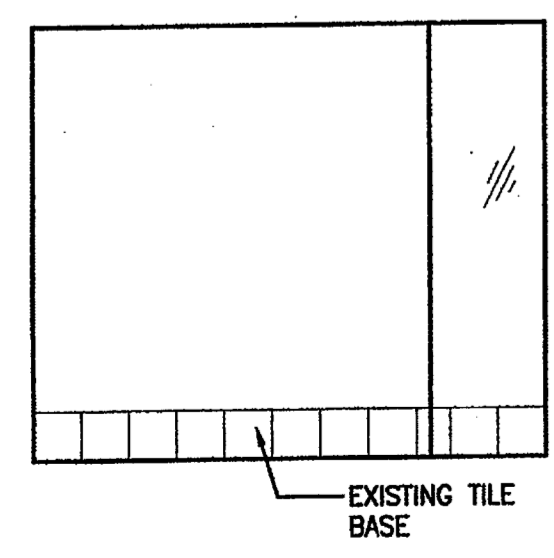


01 ELEVATION RESTROOM 105 SCALE: 1/4" = 1'-0"

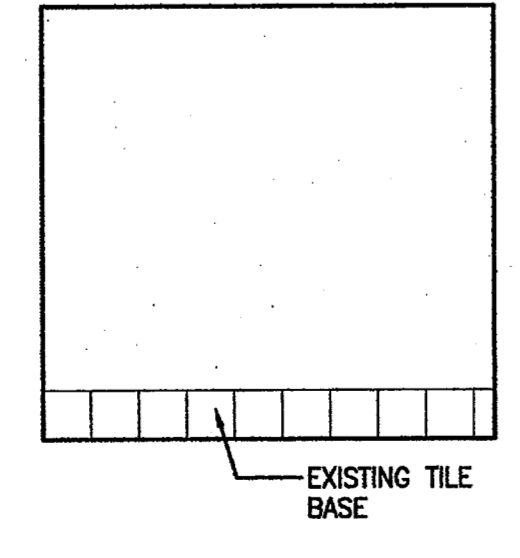

02 ELEVATION RESTROOM 133 SCALE: 1/4" = 1'-0"

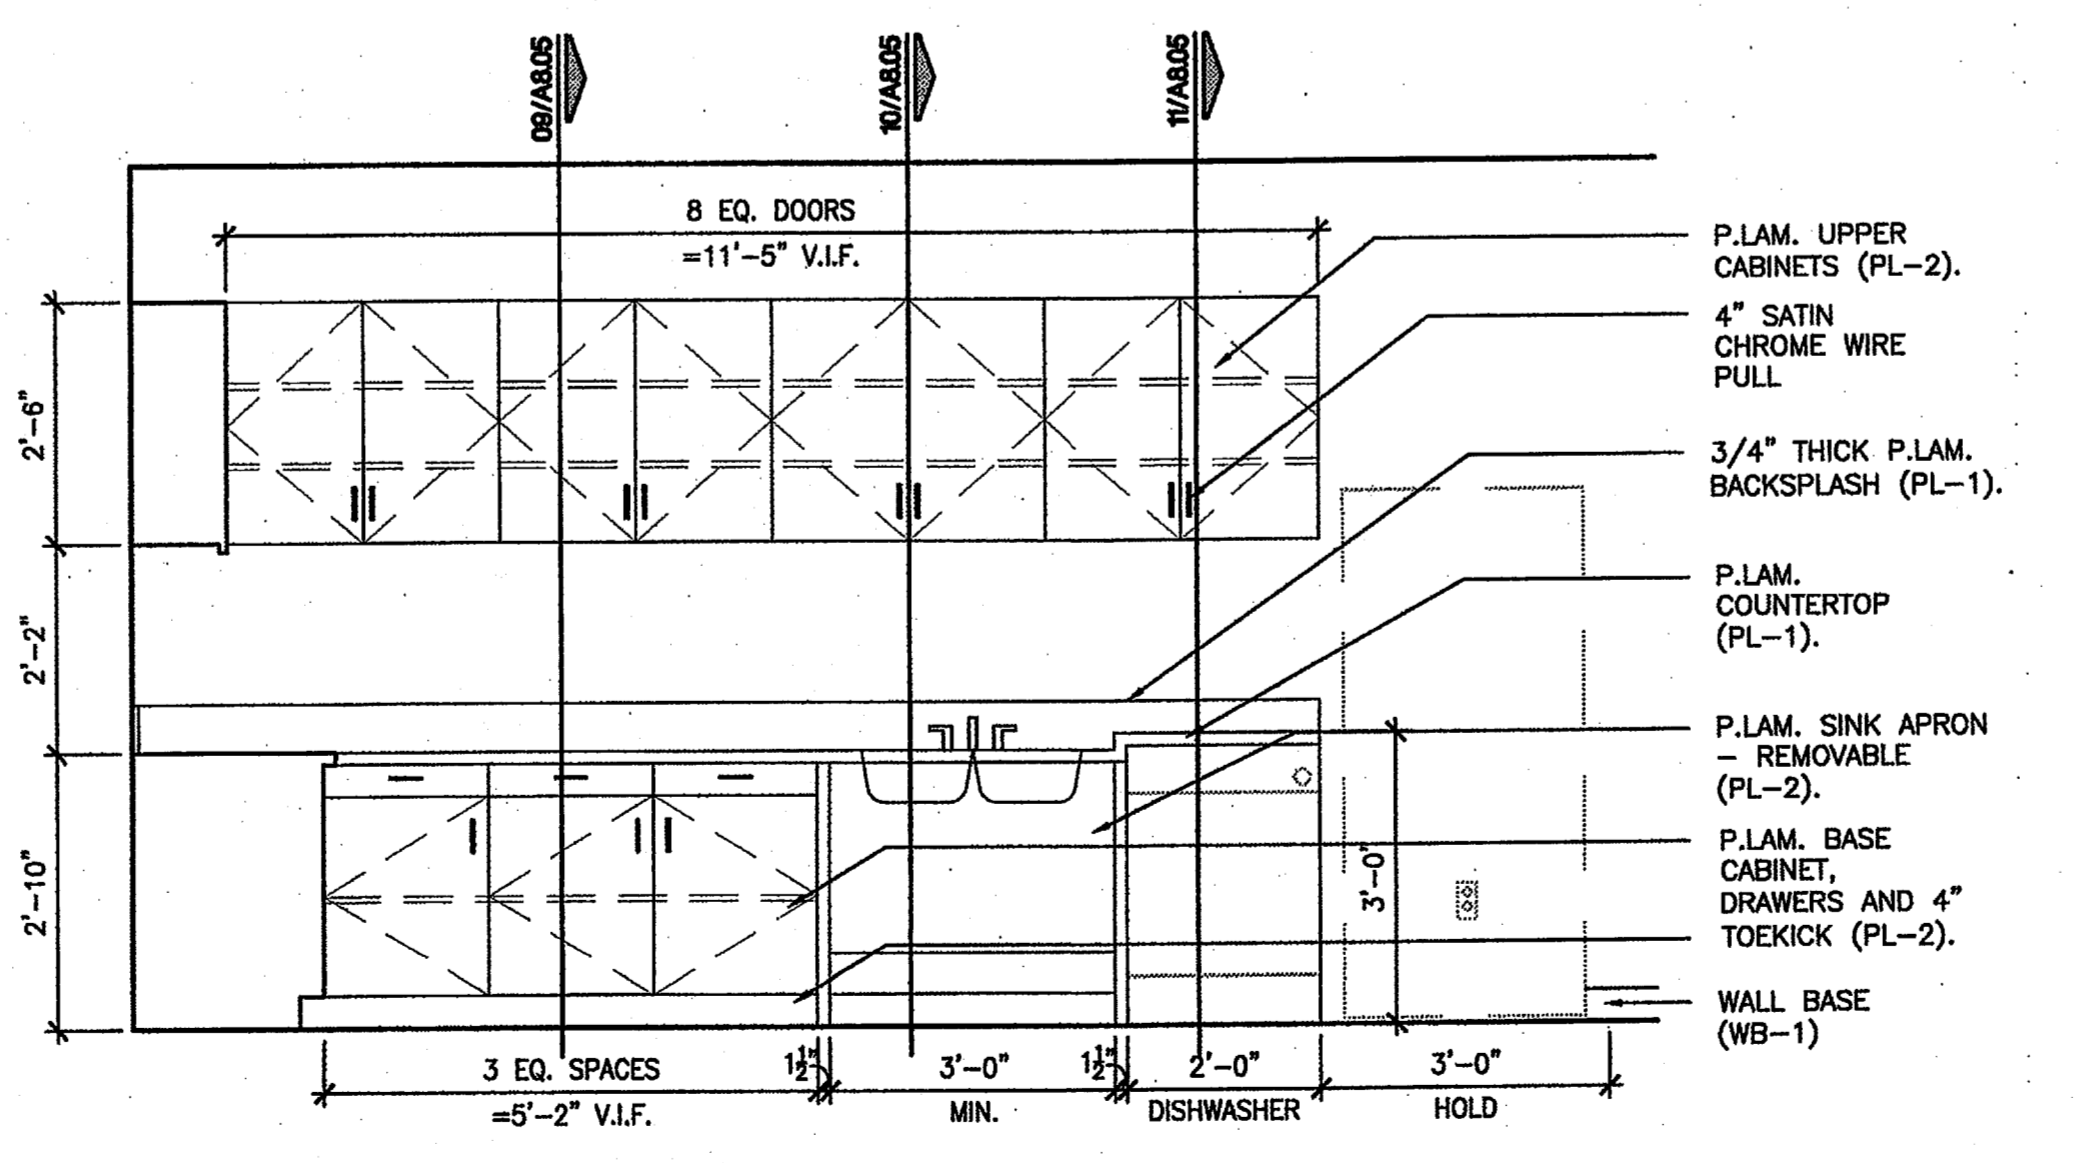

03 BREAK ROOM ELEVATION SCALE: 1/2" = 1'-0"

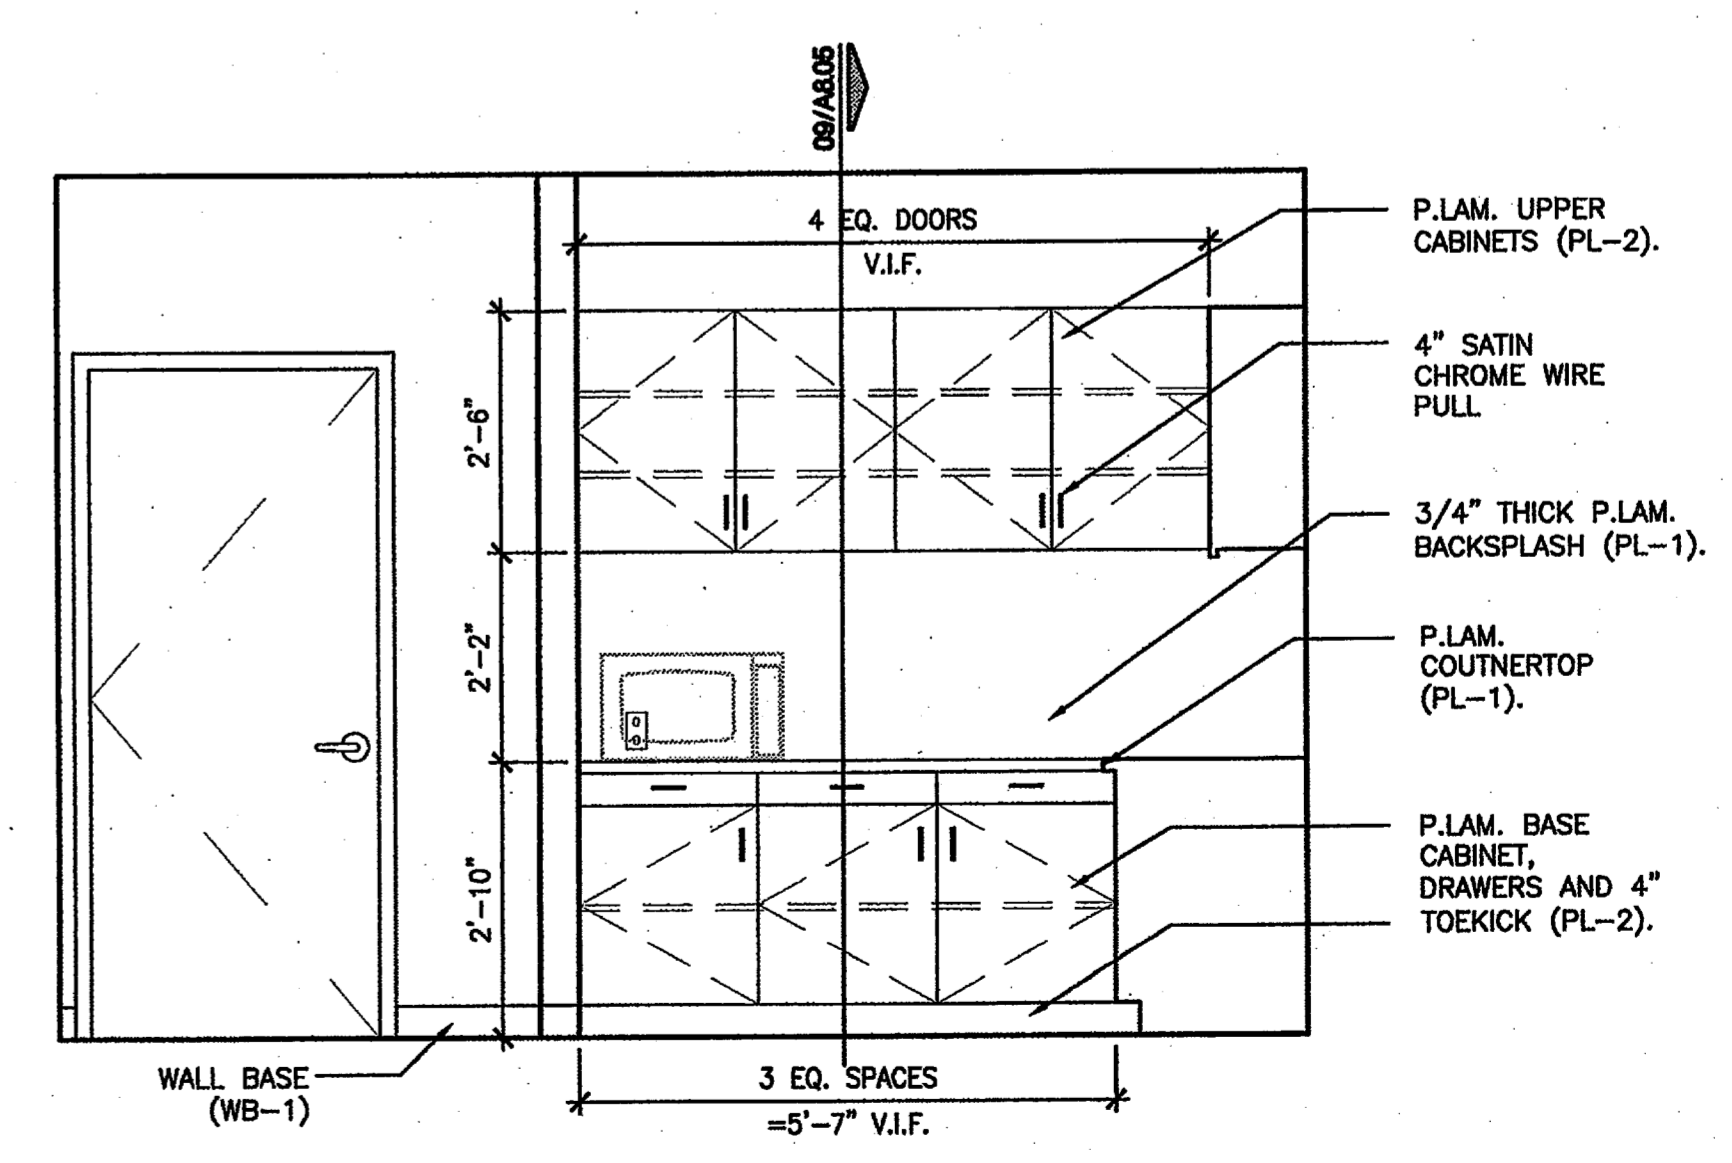

04 BREAK ROOM ELEVATION SCALE: 1/2" = 1'-0"