



**02 FLOOR PLAN - MEZZANINE ELECTRICAL**  
SCALE: 1/4" = 1'-0"

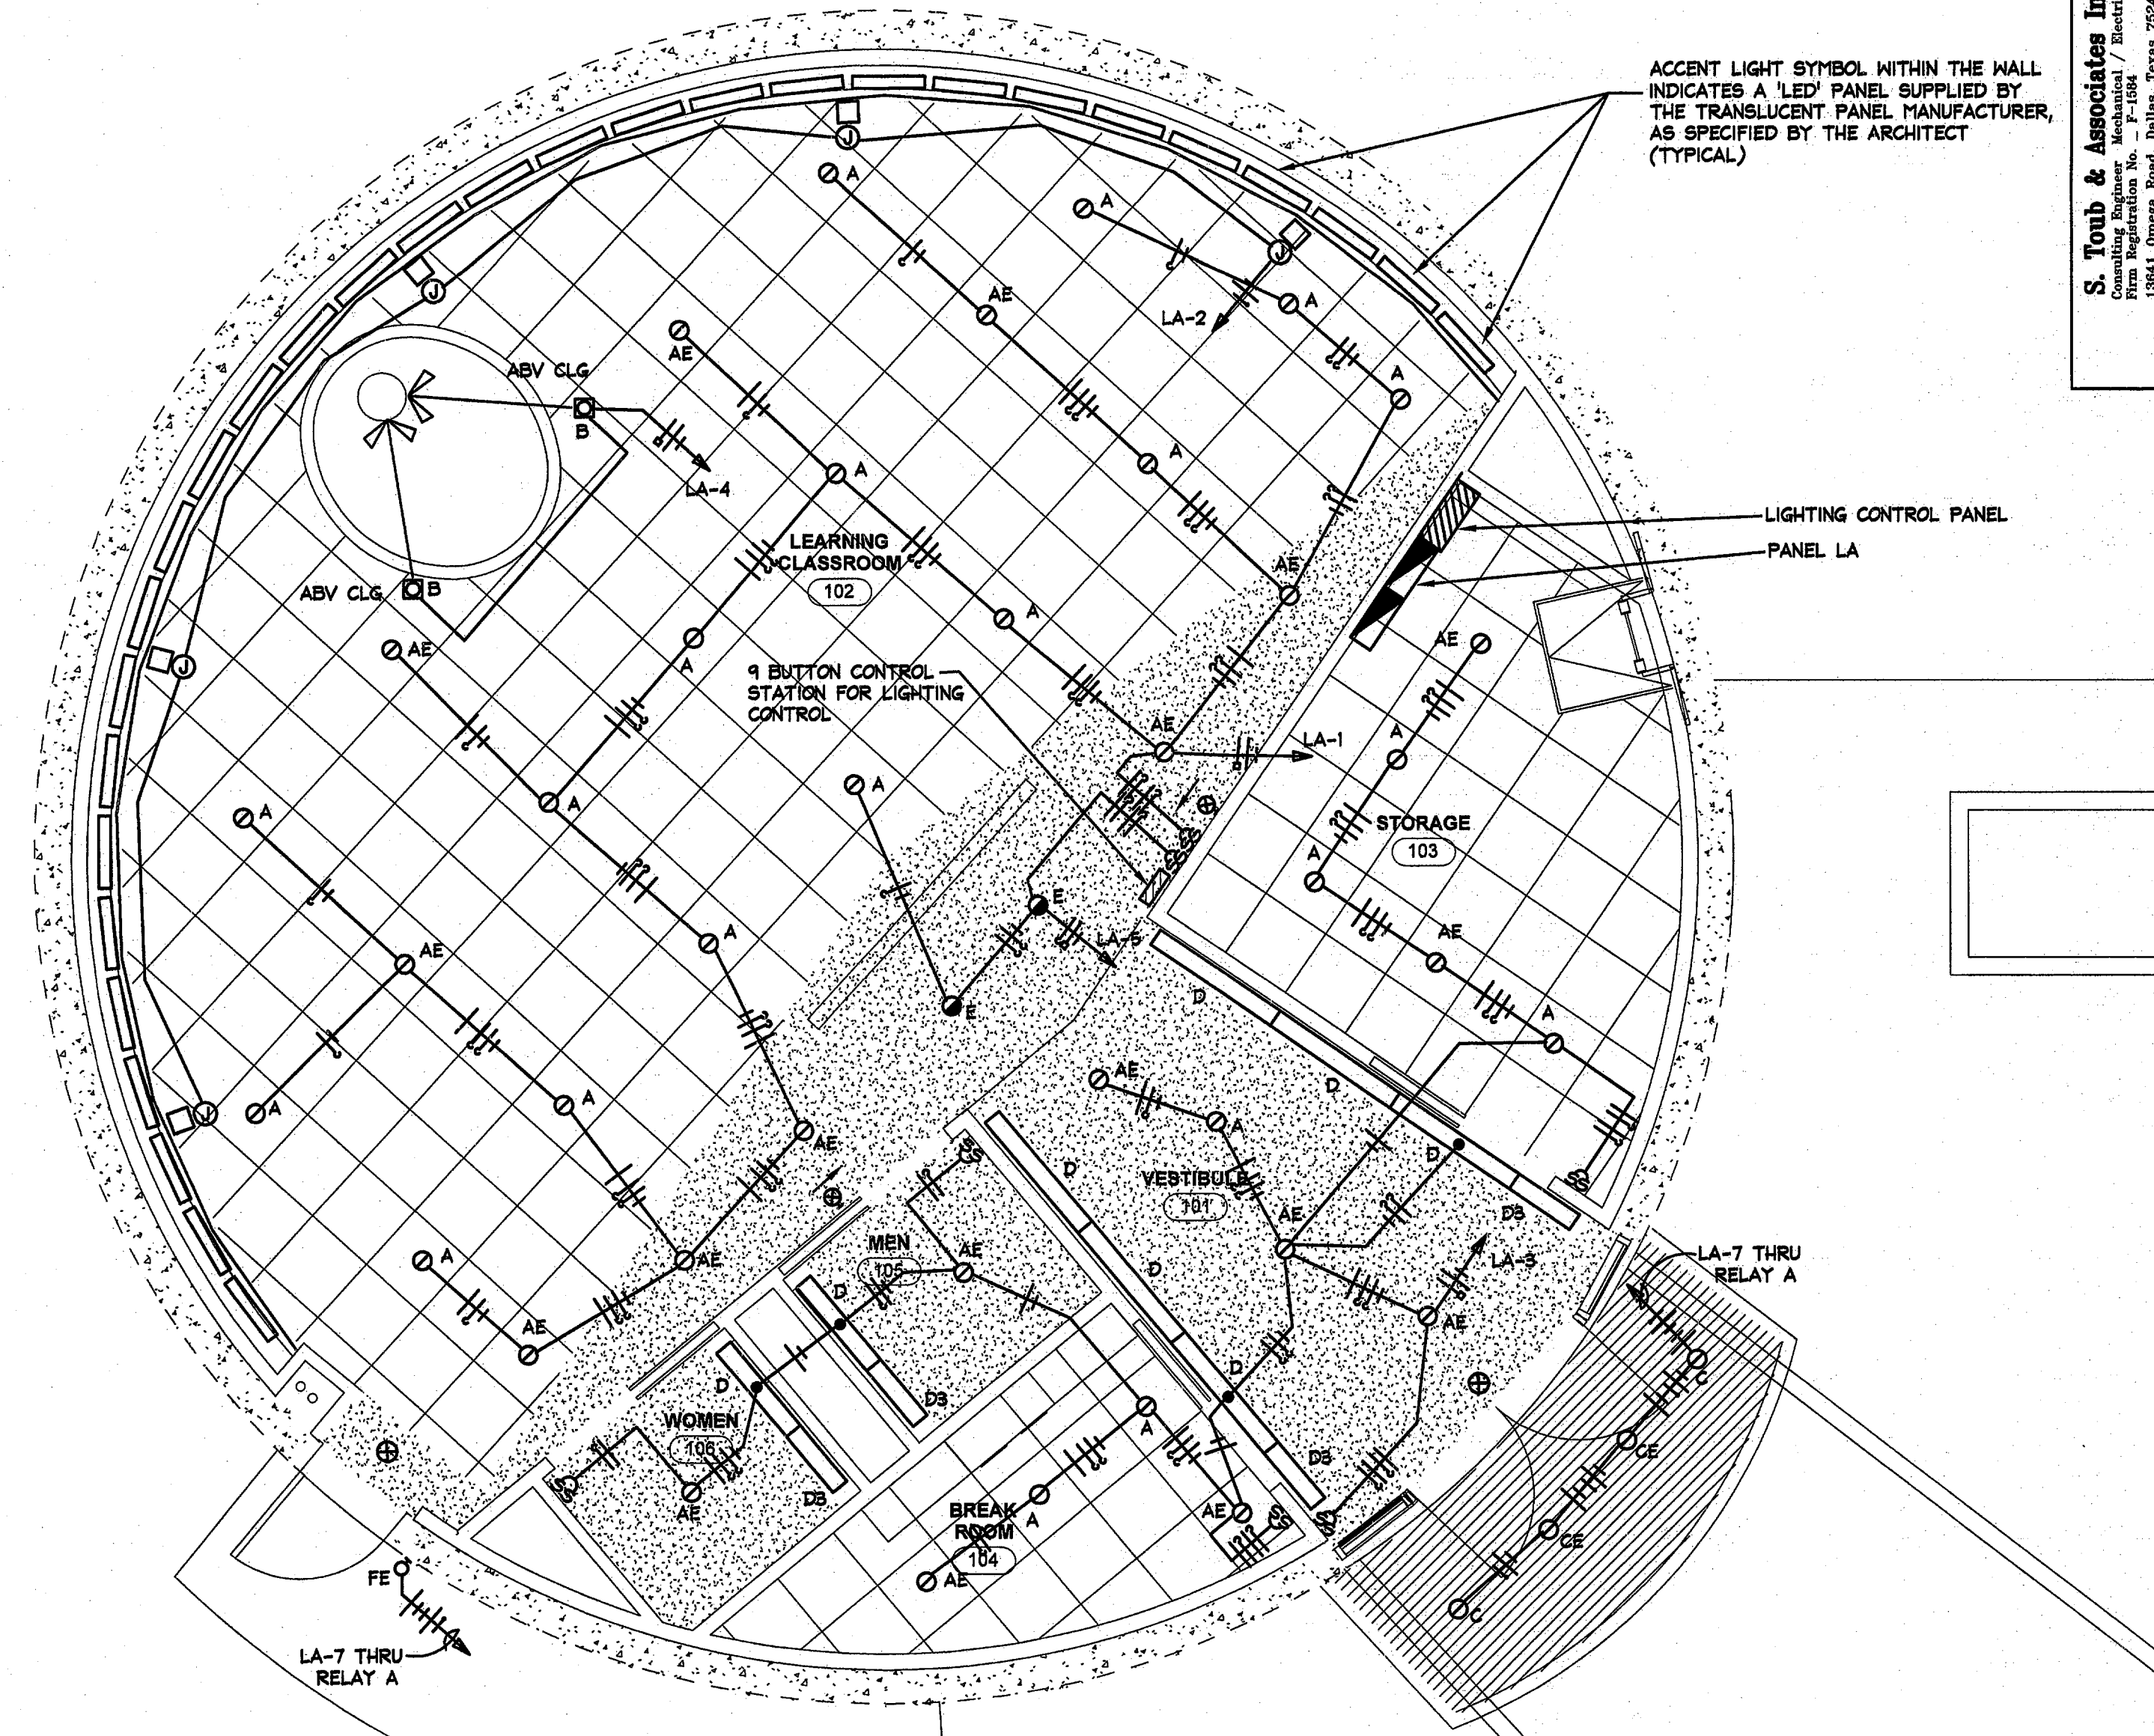

**01 FLOOR PLAN - LIGHTING**  
SCALE: 1/4" = 1'-0"

- NOTES**
- 1 ALL LIGHT FIXTURES SHALL BE TYPE "A" UNLESS NOTED OTHERWISE
  - 2 ALL CONDUITS SHALL CONTAIN A SWITCH LEG, NEUTRAL, AND GROUND UNLESS INDICATED OTHERWISE
  - 3 ALL EXIT SIGNS SHALL BE CONNECTED TO CIRCUIT LA-20 UNLESS INDICATED OTHERWISE

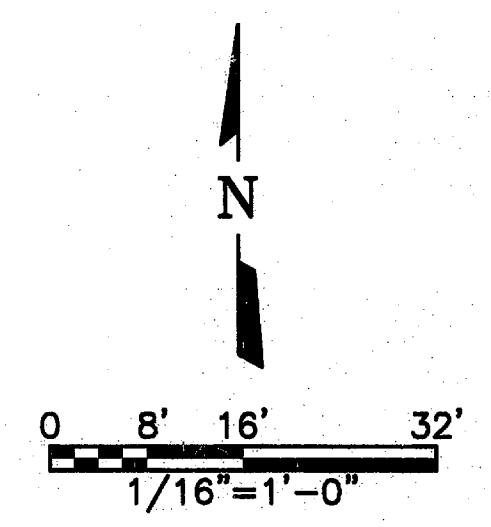

**S. Toub & Associates Inc.**  
Electrical  
18841 Omega Blvd., Dallas, Texas 75244  
972-230-2628

The seal on this document was prepared by Richard L. Norris, P.E. 100569 on the date shown below.

Richard L. Norris  
100569  
seal@rlnorris.com  
rlnorris@earthlink.net  
1-817-118-1465  
49307

**FREESSE & NICHOLS**  
2220 San Jacinto Blvd., Suite 330  
Dallas, Texas 75201  
Phone - (940) 397-4800  
Fax - (940) 397-4877

TOWN OF ADDISON, TEXAS  
**SURVEYOR 1.5 MG EST**  
M.E.P.  
**FLOOR PLAN - LIGHTING**

NO.	ISSUE	DATE	BY	DATE	DESIGNED	DRAWN	TRB	TRB	REVIS	CHKD	RLN	FILE NAME
												4049-E-1.dwg
VERIFY SCALE: Bar is one inch on original drawing. If not one inch on this sheet, adjust scale.												
SHEET EP-1												