



**02 FLOOR PLAN - MECHANICAL POWER**  
SCALE: 1/4" = 1'-0"

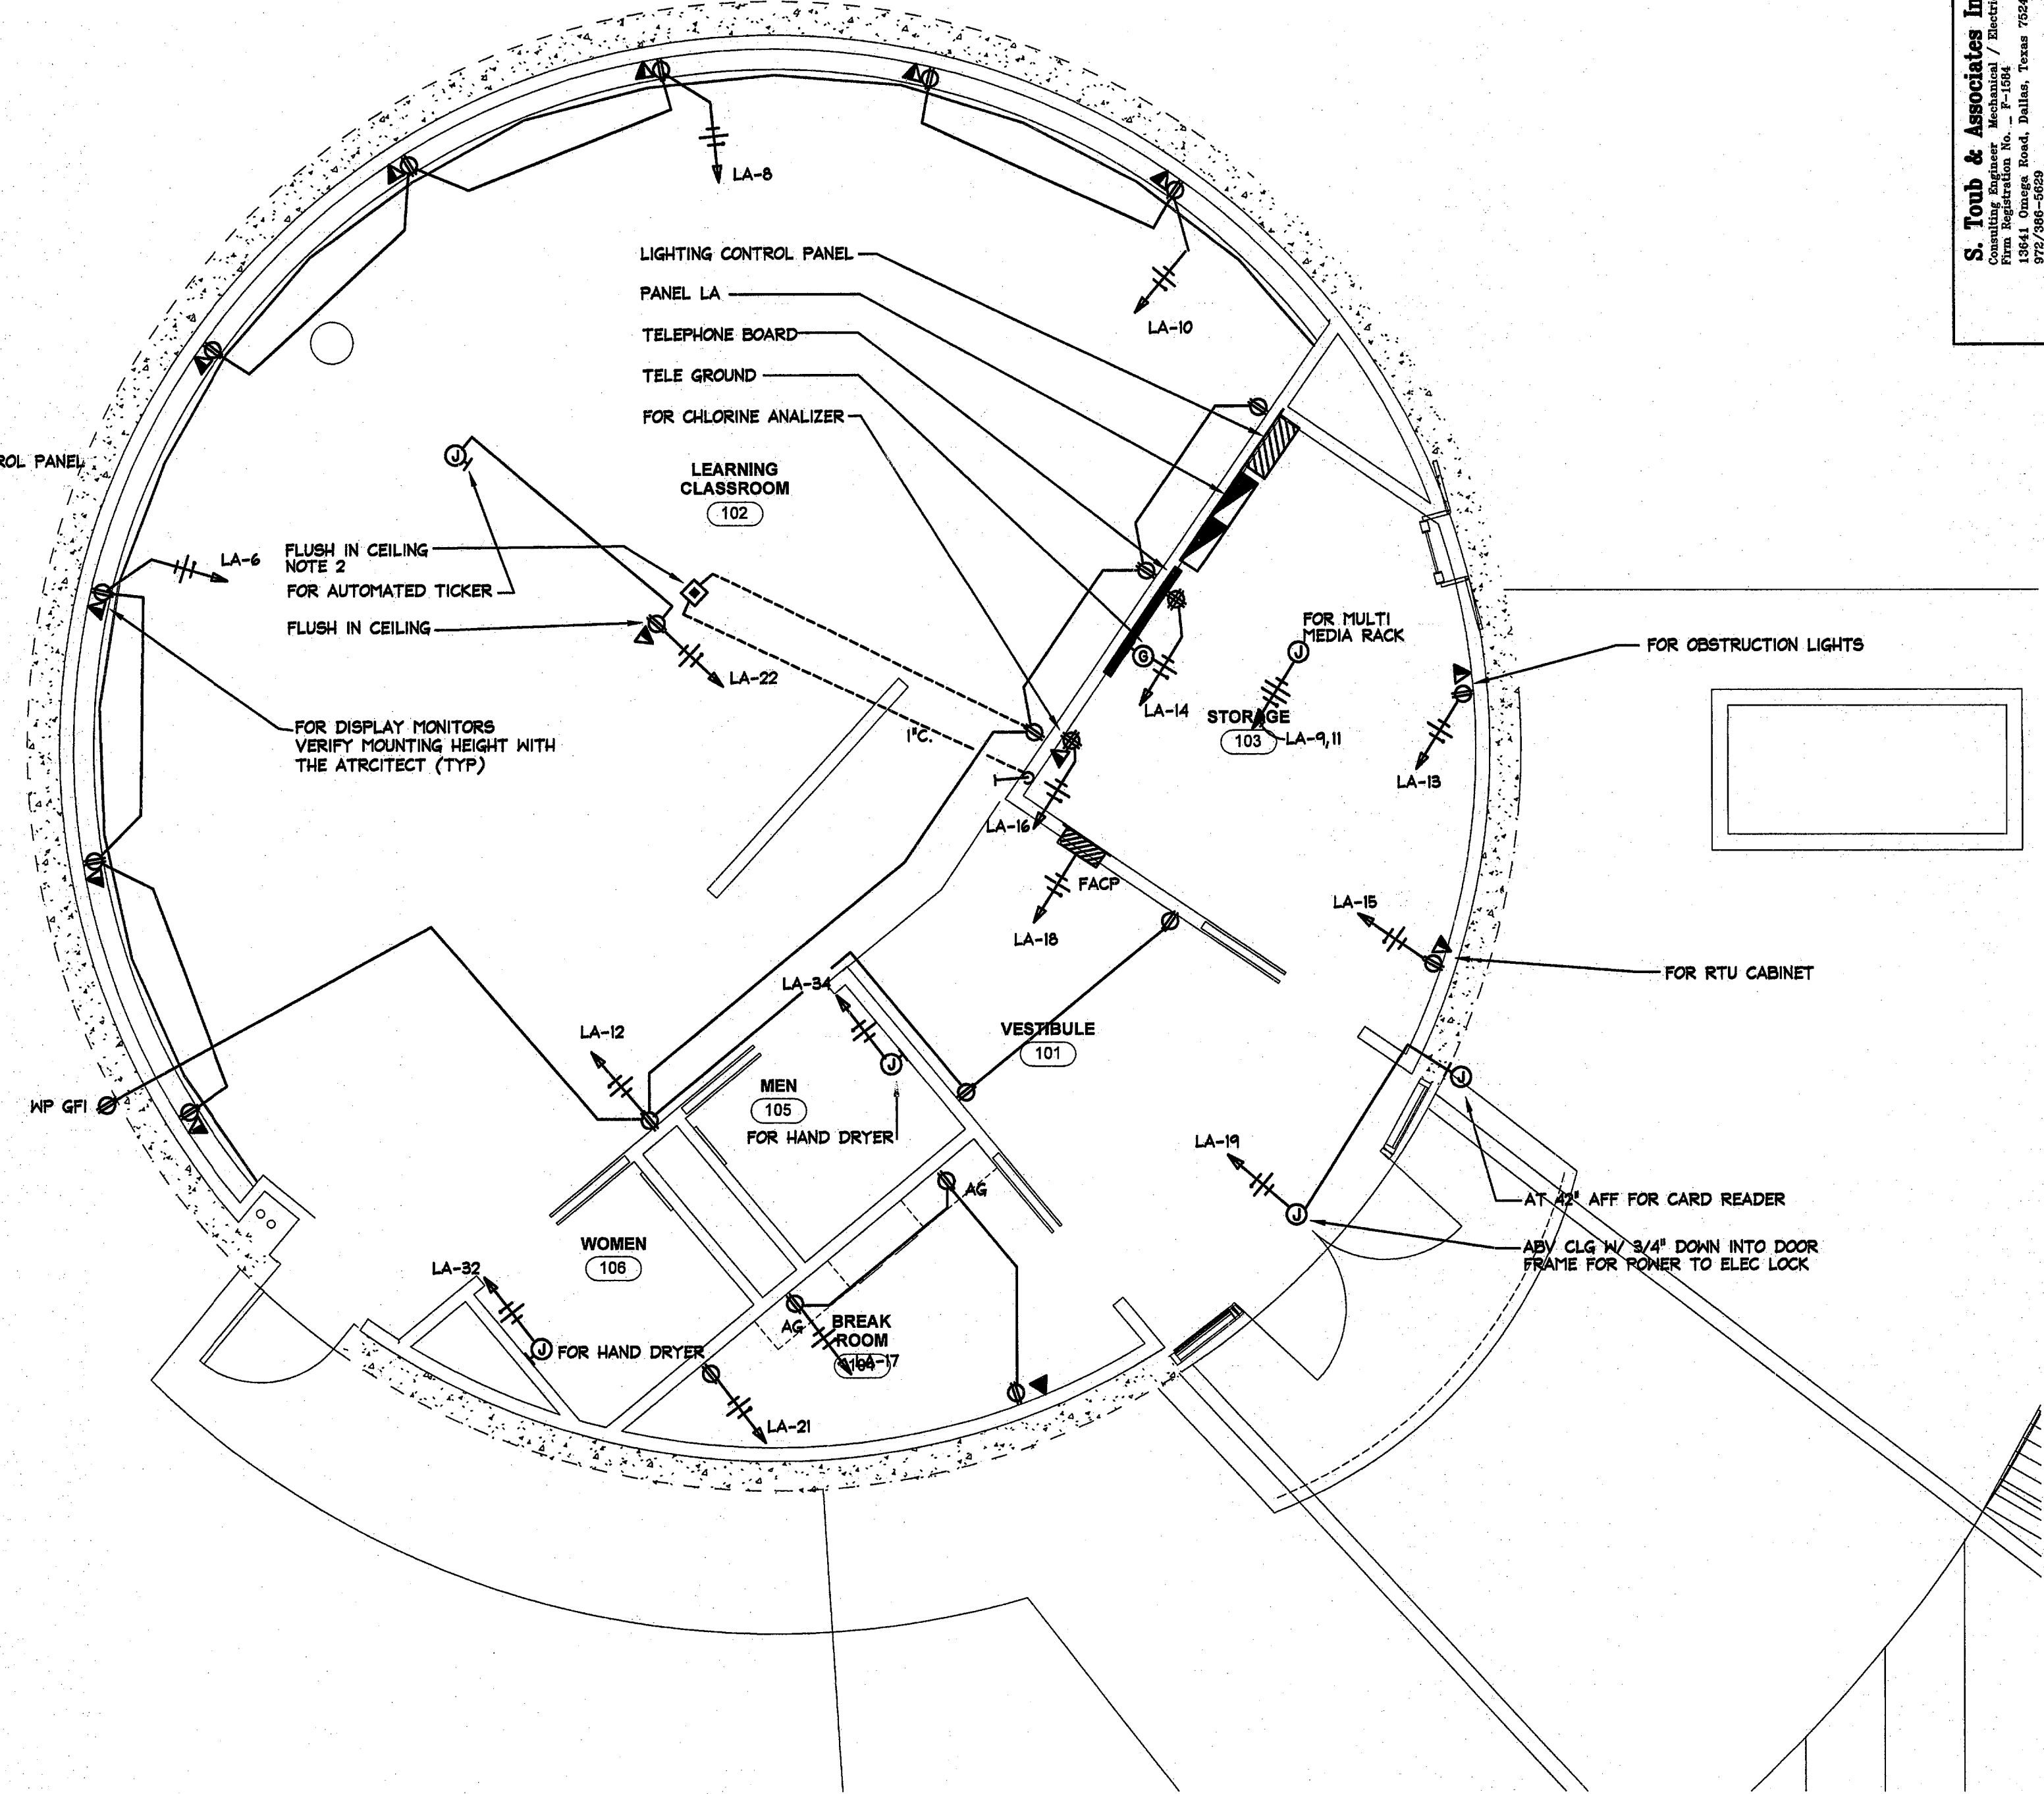

**01 FLOOR PLAN - POWER**  
SCALE: 1/4" = 1'-0"

- NOTES**
- 1 ALL CONDUITS SHALL CONTAIN A HOT LEG, NEUTRAL AND GROUND UNLESS INDICATED OTHERWISE
  - 2 FLUSH FLOOR BOX FOR POWER AND DATA SHALL BE WIREMOLD BOX = 2 GANG, #860MP (2)  
COVER = BRASS, 2 GANG, #827B  
POWER INSERT = BRASS #828R  
DATA INSERT = BRASS #8289PTC  
(1) DUPLEX RECEPTACLE/IVORY  
(1) TELE/DATA JACK

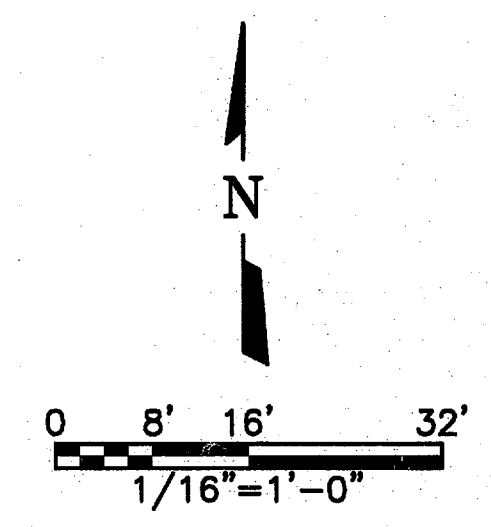

**S. Toub & Associates Inc.**  
Electrical / Structural  
13841 Omega Road, Dallas, Texas 75244  
972/948-9859

The seal on this document was authorized by Richard L. Morris, 0009 on the date shown below.

**FREISE & NICHOLS**  
2220 San Jacinto Blvd., Suite 330  
Houston, Texas 77002  
Phone: (713) 357-4900  
Fax: (713) 357-4877

TOWN OF ADDISON, TEXAS  
**SURVEYOR 1.5 MG EST**  
M.E.P.  
**FLOOR PLAN - POWER**

NO.	ISSUE	BY	DATE	F&N JOB NO.	DATE	DESIGNED	DRAWN	REVISIONS	CHECKED	FILE NAME
				ADD08459	01/18/11	GCH	TRB		RLN	4049-E-2.dwg

Bar is one inch on original drawing, if not one inch on this sheet, adjust scale.

VERIFY SCALE

SHEET EP-2