



REFER TO SHEET 16.13 FOR PLUMBING SYMBOL LEGEND.  
 REFER TO SHEETS 16.11 & 16.12 FOR PLUMBING RISER DIAGRAMS.  
 REFER TO SHEET 16.13 FOR PLUMBING CONNECTION SCHEDULES.  
 REFER TO SHEET 16.14 FOR PLUMBING DETAILS.

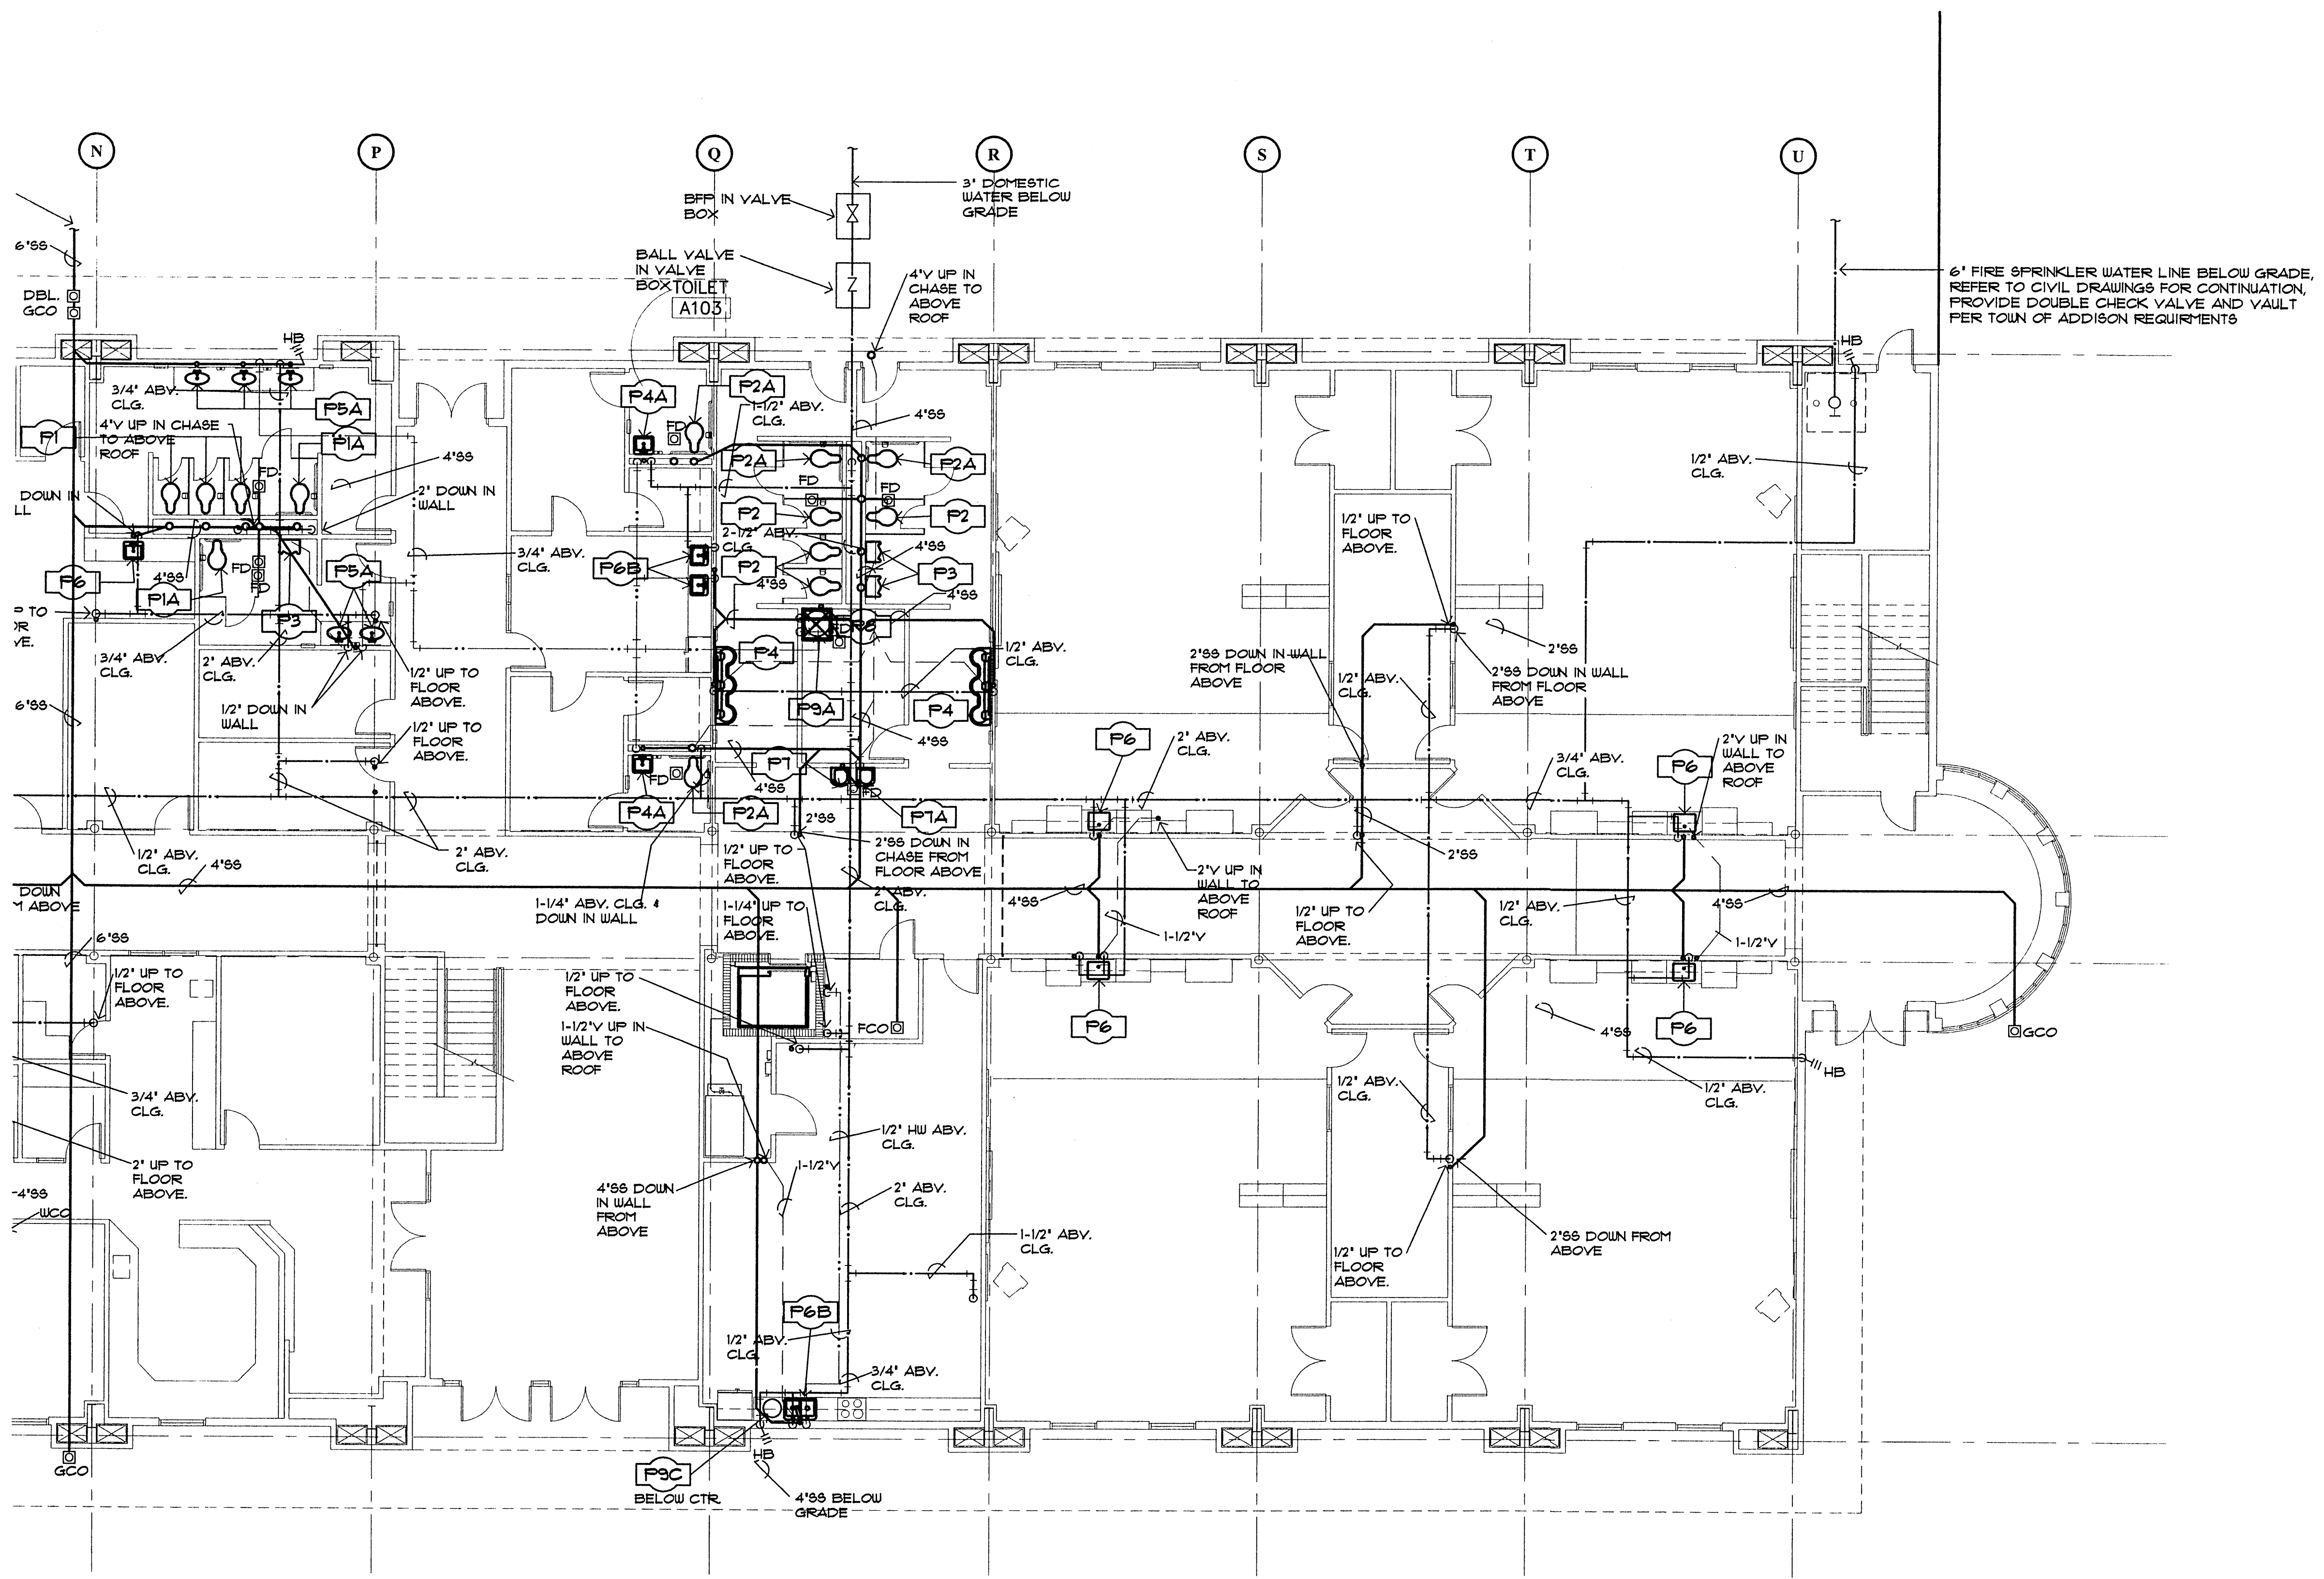

**S · B · I**  
**SCOTT · BALLEW · INC**  
 ARCHITECTURE · DESIGN · PLANNING  
 214-252-0883  
 FAX 214-252-0889  
 3511 CEDAR SPRINGS · SUITE THREE  
 DALLAS · TX 75219

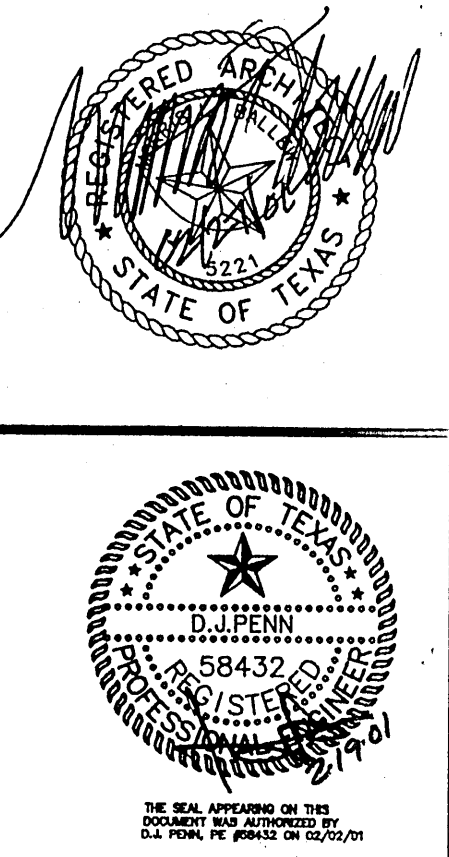

A NEW  
**TRINITY LOWER SCHOOL**  
 TRINITY CHRISTIAN ACADEMY  
 ADDISON, TEXAS  
**1ST FLR PLUMBING PLAN - AREA 'A'**

SBI Project No.: 9924  
 Date: 02-15-2000  
 Issue: S.D. Print Set  
 Drawn By: B.F. SWS  
 Checked By: D.P.  
 Revisions: 02/15/01

SHEET

**16.01**

PLAN NORTH  
**01 1ST FLR PLUMBING PLAN - AREA 'A'**  
 1/8" = 1'-0"

**dp** DON PENN  
 CONSULTING ENGINEERS  
 3950 HIGHWAY 360, SUITE 101  
 GRAPEVINE, TEXAS 76051  
 817-410-2858 FAX 817-251-8411

SHEET NO. 01 OF 14 TOTAL SHEETS