



REFER TO SHEET 16.13 FOR PLUMBING SYMBOL LEGEND.
 REFER TO SHEETS 16.11 & 16.12 FOR PLUMBING RISER DIAGRAMS.
 REFER TO SHEET 16.13 FOR PLUMBING CONNECTION SCHEDULES.
 REFER TO SHEET 16.14 FOR PLUMBING DETAILS.

S·B
 SCOTT·BALLEW·INC
 ARCHITECTURE·DESIGN·PLANNING
 214-252-0883
 FAX 214-252-0889
 3511 CEDAR SPRINGS - SUITE THREE
 DALLAS - TX 75219

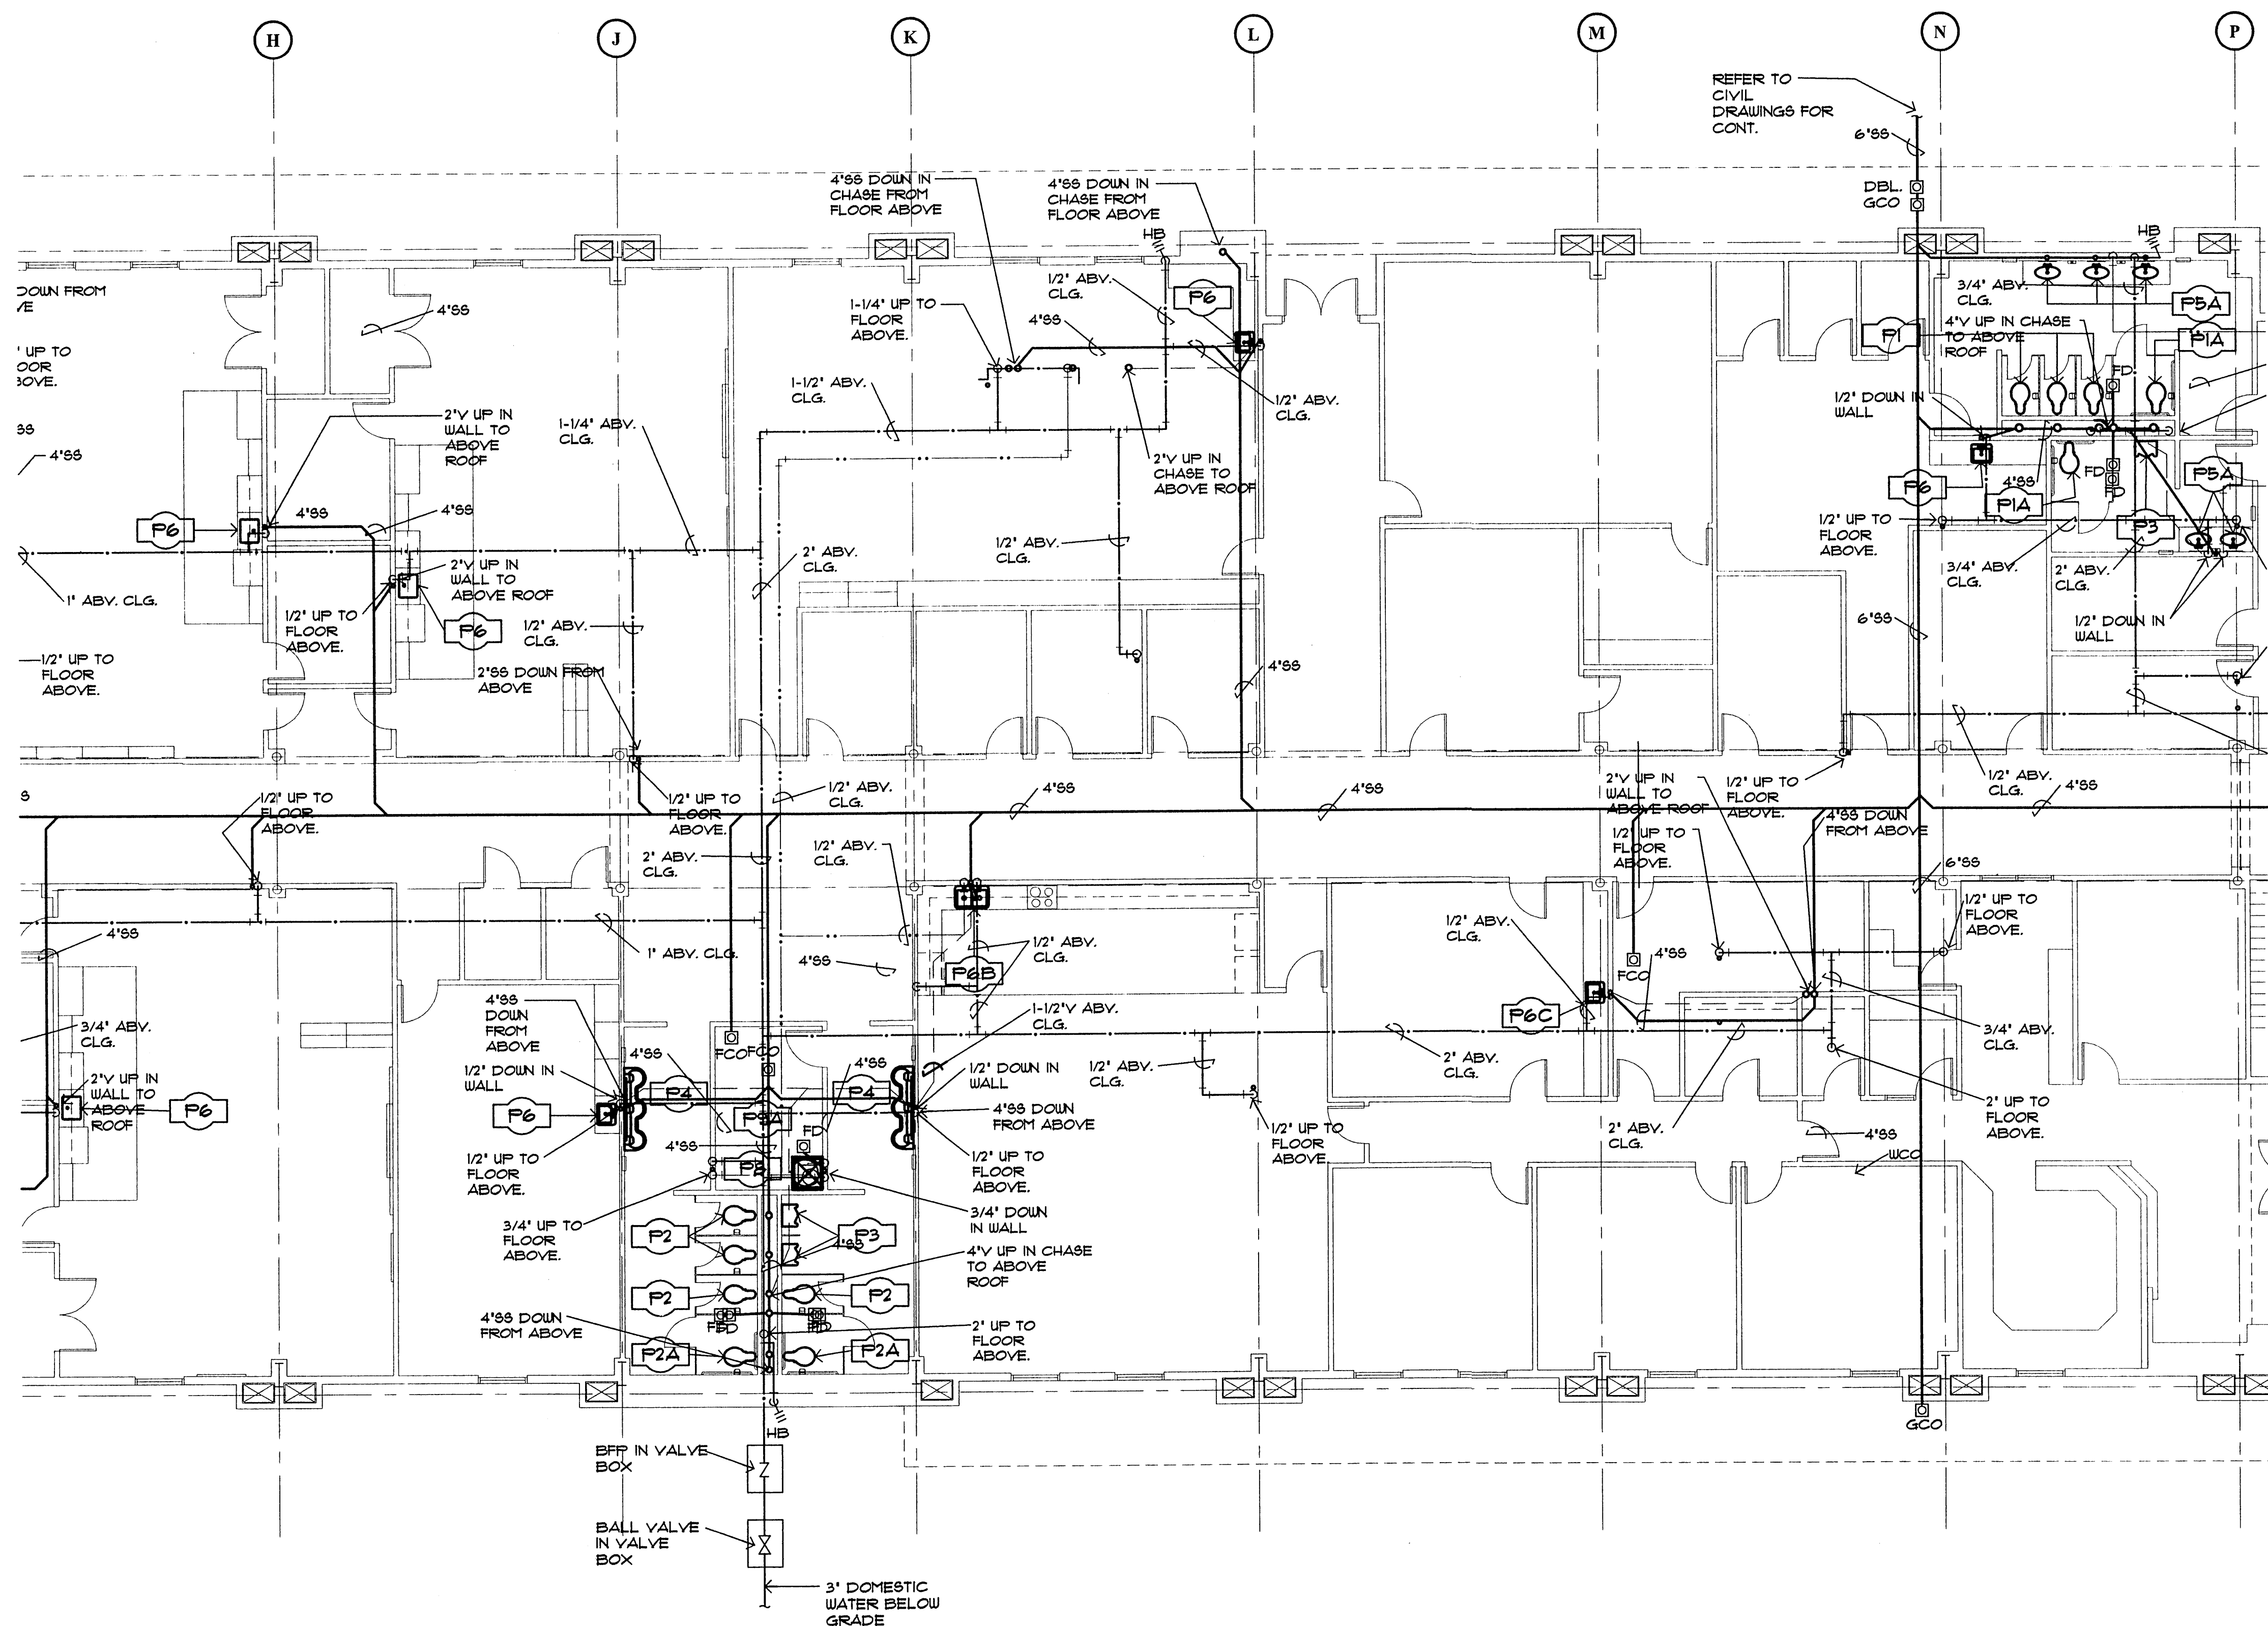

REFER TO CIVIL DRAWINGS FOR CONT.

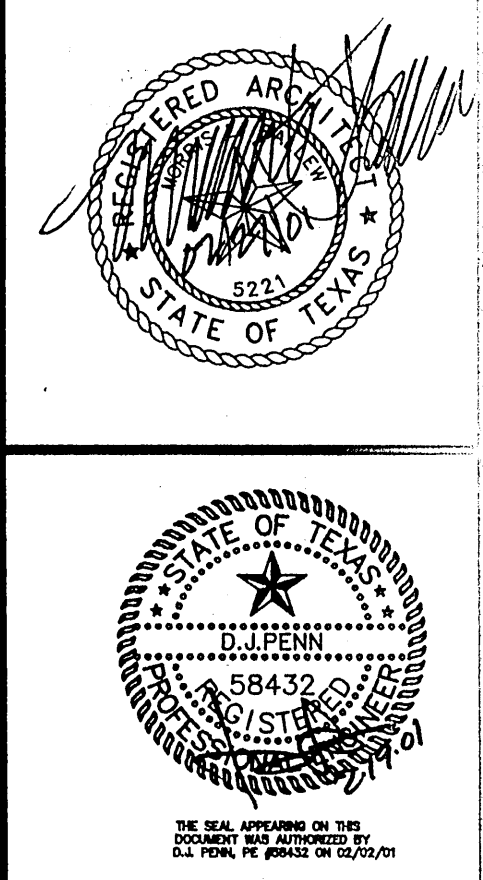

01 1ST FLR PLUMBING PLAN - AREA 'B'

1/8" = 1'-0"

A NEW
TRINITY LOWER SCHOOL
 TRINITY CHRISTIAN ACADEMY
 ADDISON, TEXAS
 1ST FLR PLUMBING PLAN - AREA 'B'

SBI Project No.:	9924
Date:	02-15-2000
Issue:	S.D. Printing Set
Drawn By:	RLP-SWS
Checked By:	DJP
Revisions:	02/19/01

SHEET

16.02

dp DON PENN CONSULTING ENGINEERS
 3950 HIGHWAY 360, SUITE 101
 GRAPEVINE, TEXAS 76051
 817-410-2858 FAX 817-251-8411

SHEET NO. 02 OF 14 TOTAL SHEETS