



12" DISCHARGE PROFILE
Scale: 1" = 10' Horizontal, 1" = 5' Vertical

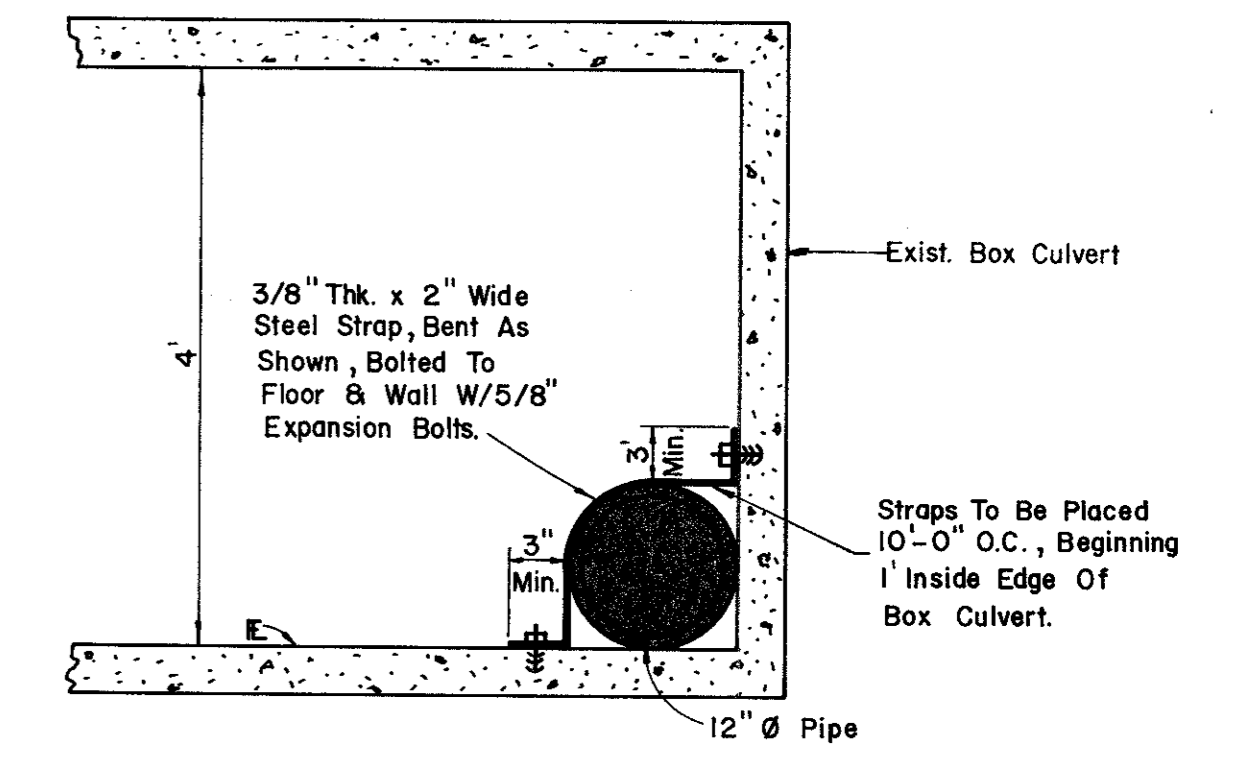


DETAIL PIPE LOCATION
No Scale

SITE PLAN
Scale: 1" = 10'-0"

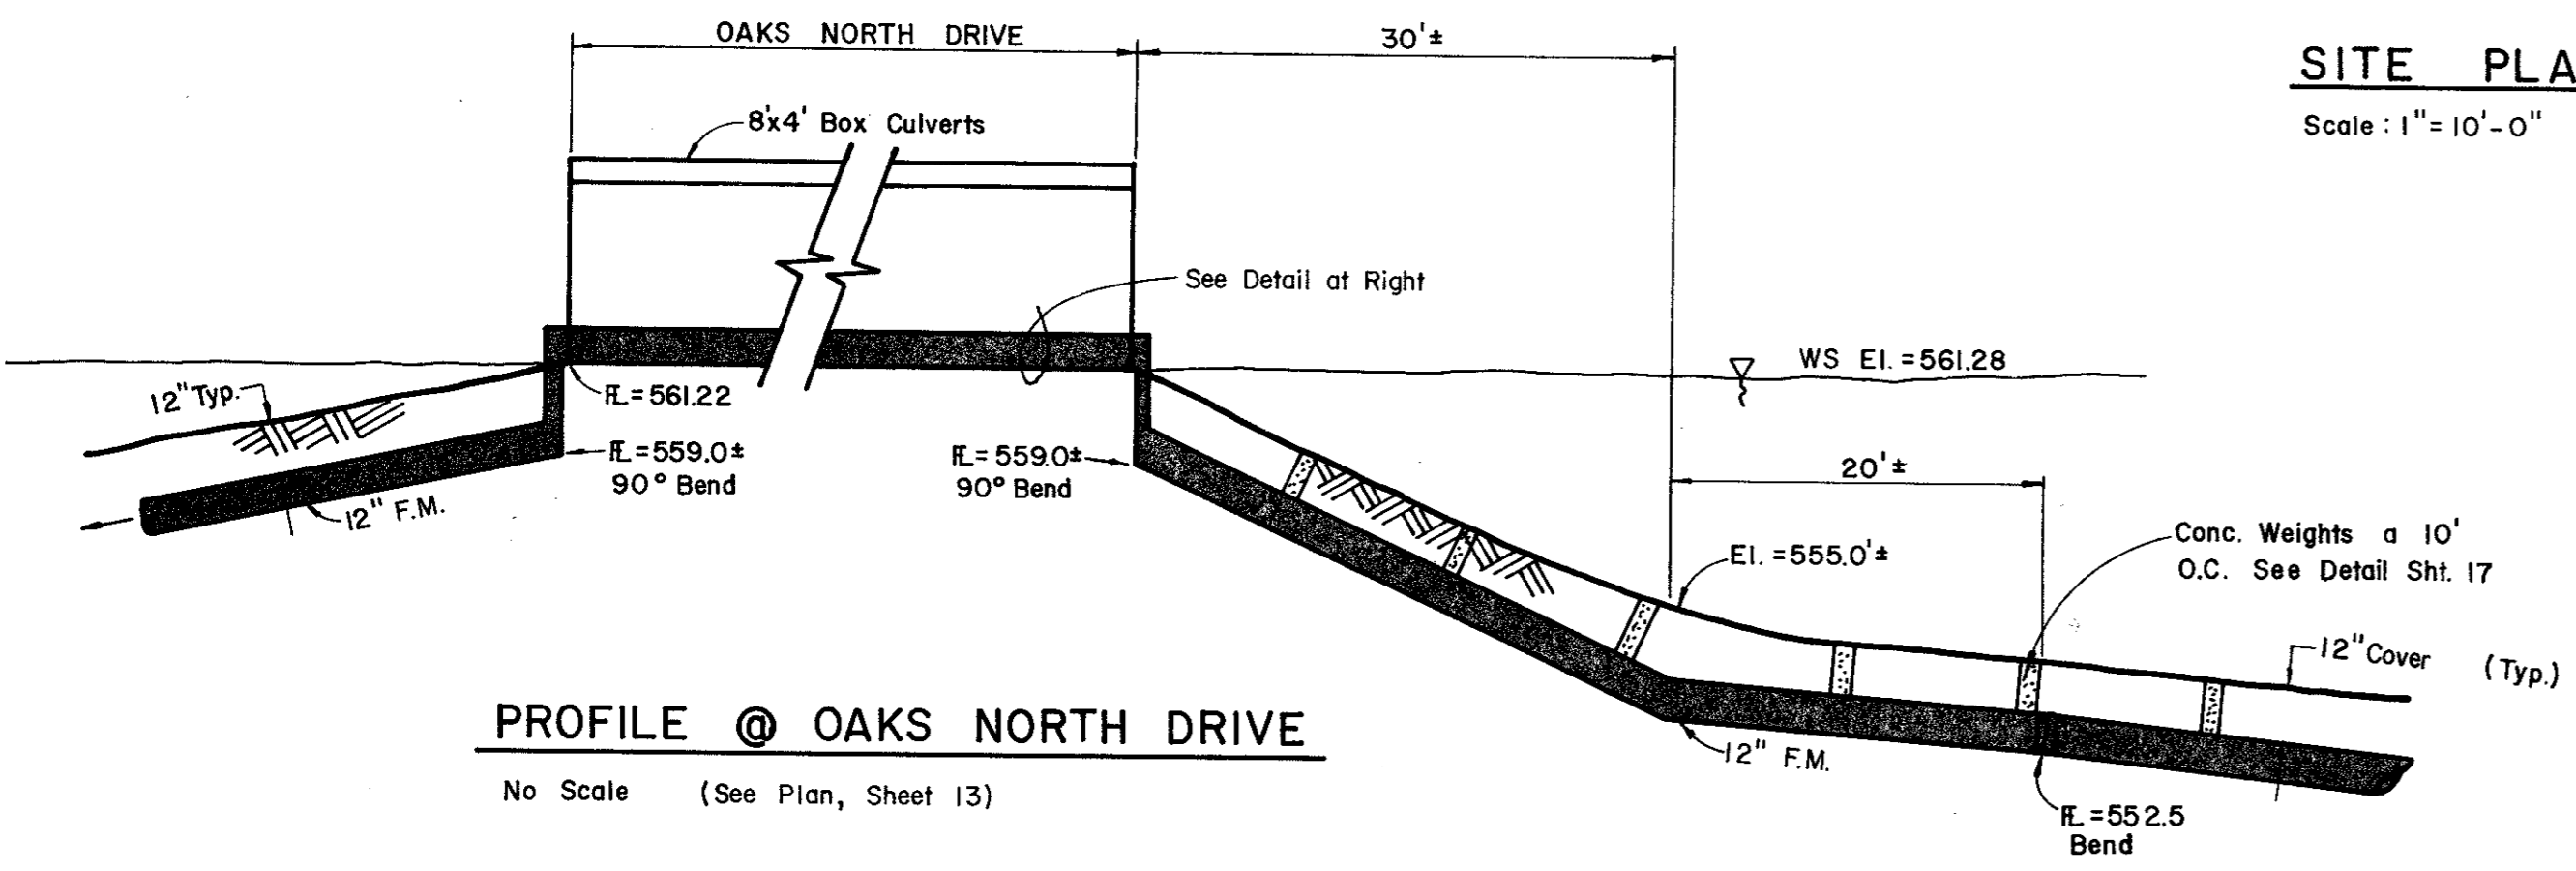

PROFILE @ OAKS NORTH DRIVE
No Scale (See Plan, Sheet 13)

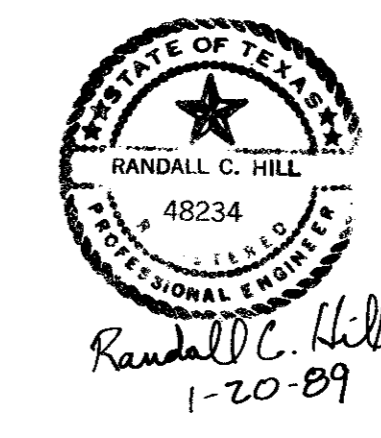

Randall C. Hill
1-20-89

No.	Revision	By	Date
TOWN OF ADDISON DALLAS COUNTY, TEXAS CREEK SYSTEM IMPROVEMENTS			
FINANCE CENTER PUMP STATION SITE PLAN			
GINN, INC.			
Consulting Engineers Dallas, Texas			
Designed - RCH	Drawn - RLO	Date - OCT., 1988	Job No. - 369
Approved - HWG	Checked - RCH	Scale - 1" = 20'	Sheet 14 Of 23