


41-3

- GENERAL NOTES
1. ALL MATERIAL SHALL BE U.L. LISTED FOR FIRE PROTECTION SERVICE.
  2. ALL WORK SHALL COMPLY WITH NFPA #24 & THE CITY OF ADDITION.
  3. TRENCH WORK, BACKFILL, AND CONCRETE THRUST BLOCKS SHALL COMPLY WITH NFPA #24 & THE CITY OF ADDITION.
  4. PIPE SHALL BE HYDROSTATICALLY TESTED @ 200 PSI FOR 2 HOURS.
  5. PIPE SHALL BE FLUSHED PER NFPA #24.

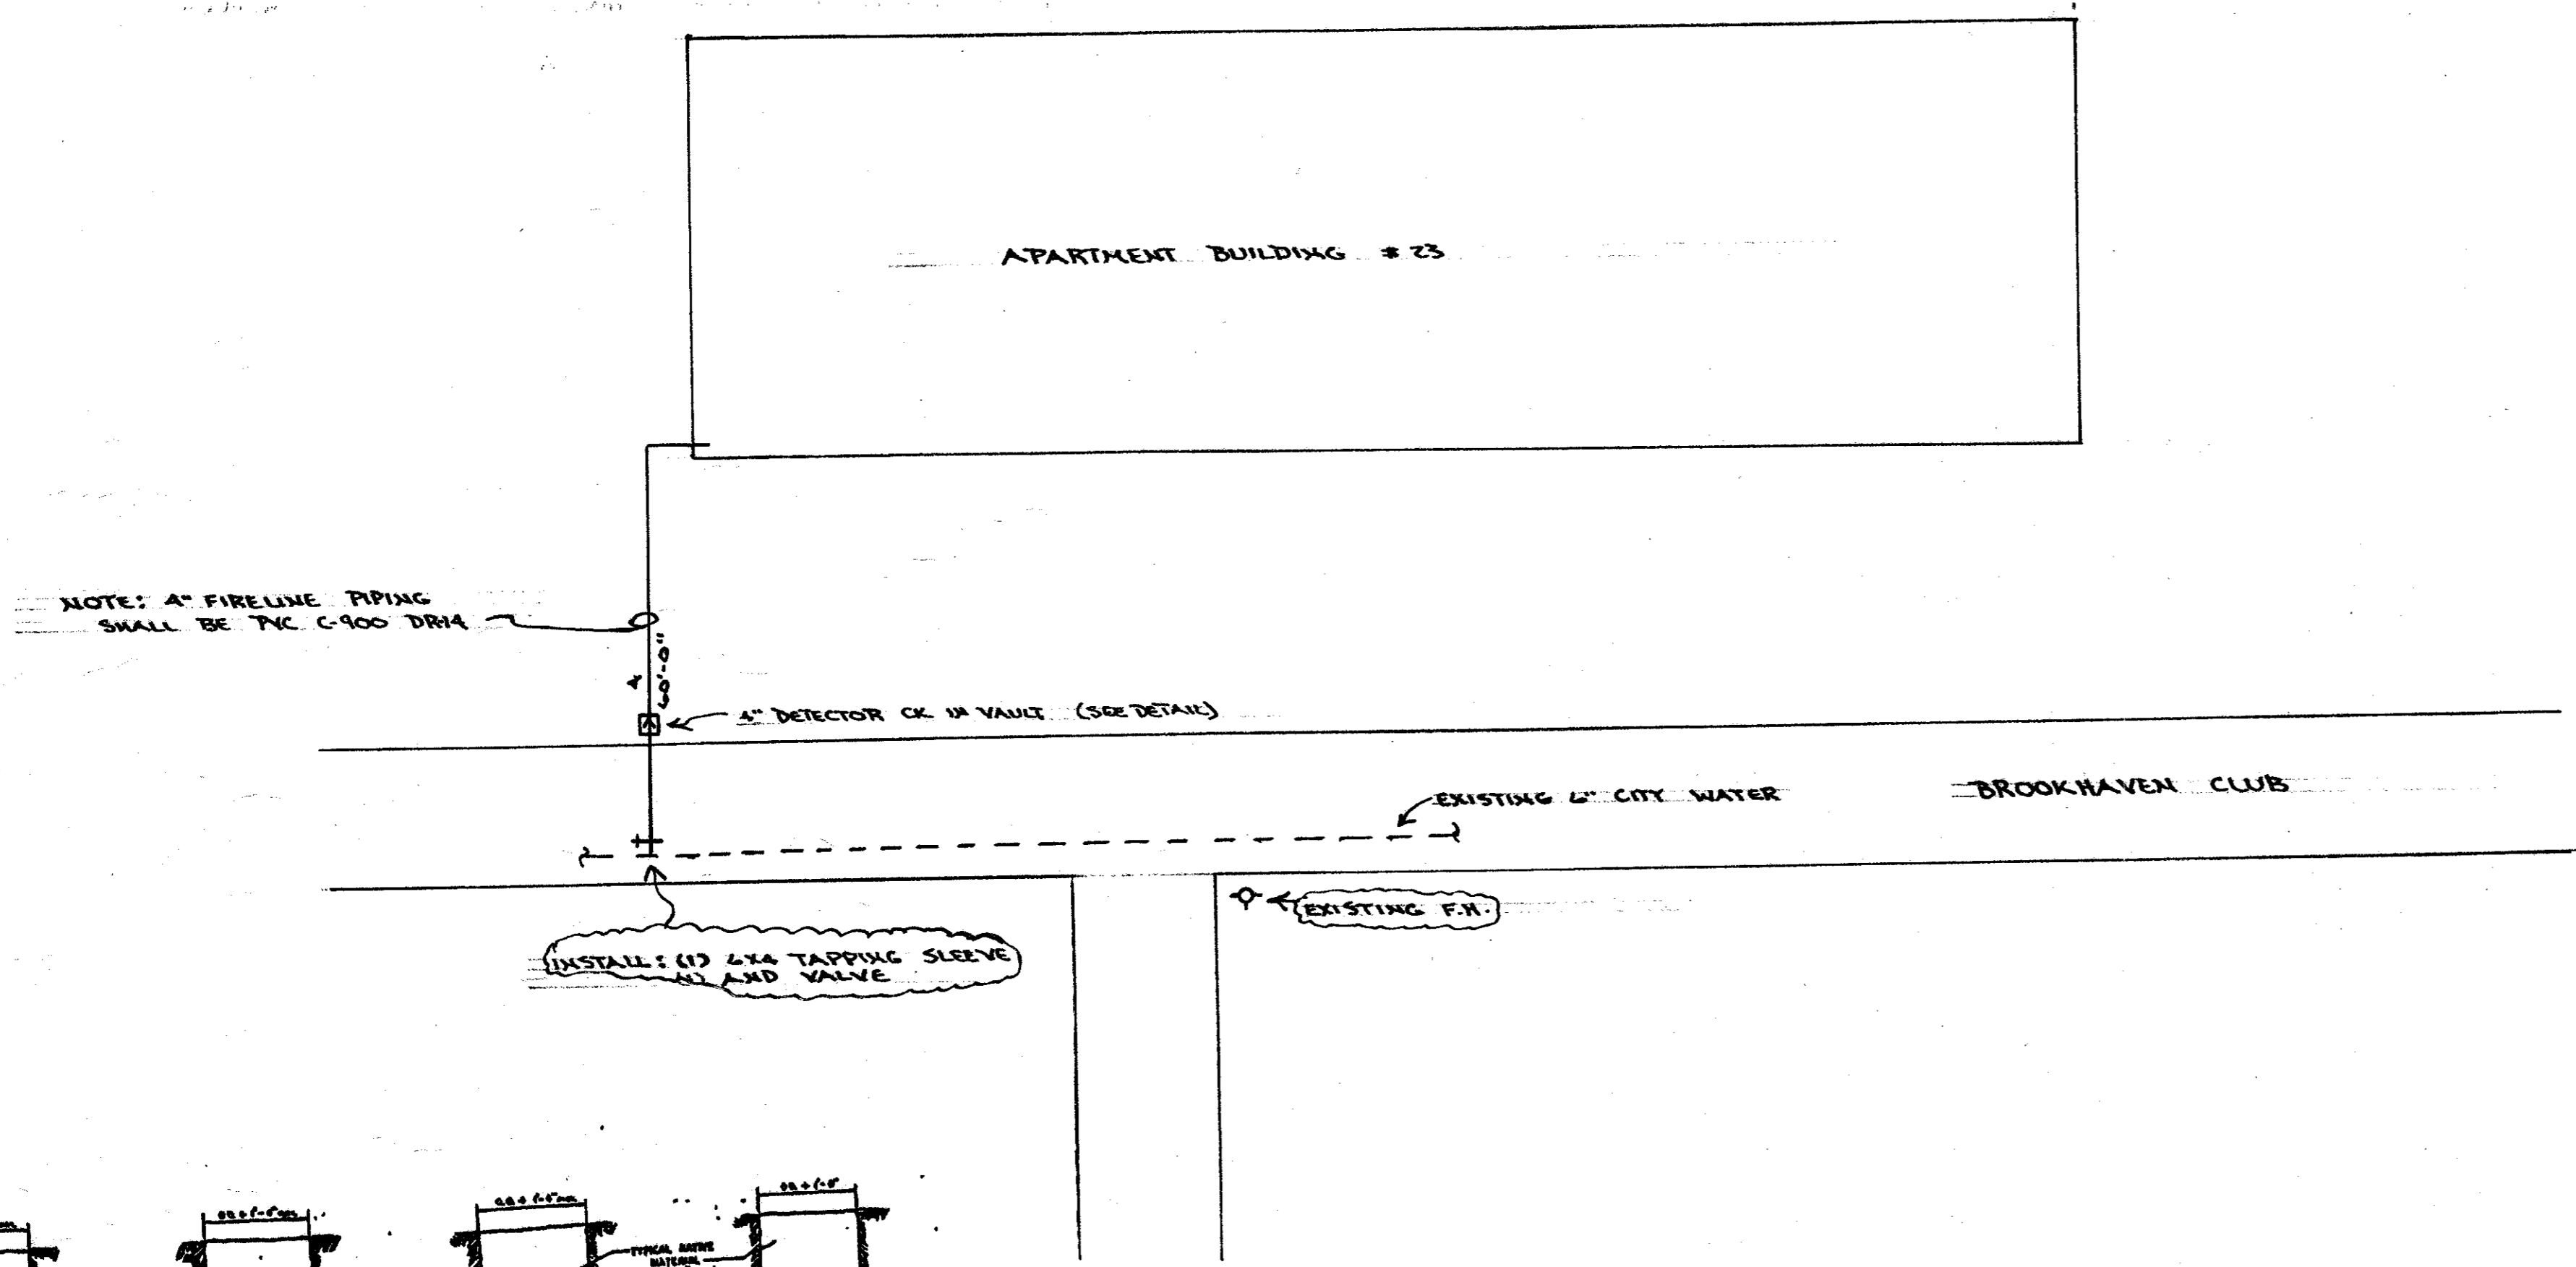

NOTE: 4" FIRELINE PIPING SHALL BE PVC C-900 DR14


4" DETECTOR CK. IN VAULT (SEE DETAIL)

EXISTING 6" CITY WATER

BROOKHAVEN CLUB

INSTALL 1/2" LSA TAPPING SLEEVE AND VALVE


EXISTING F.W.

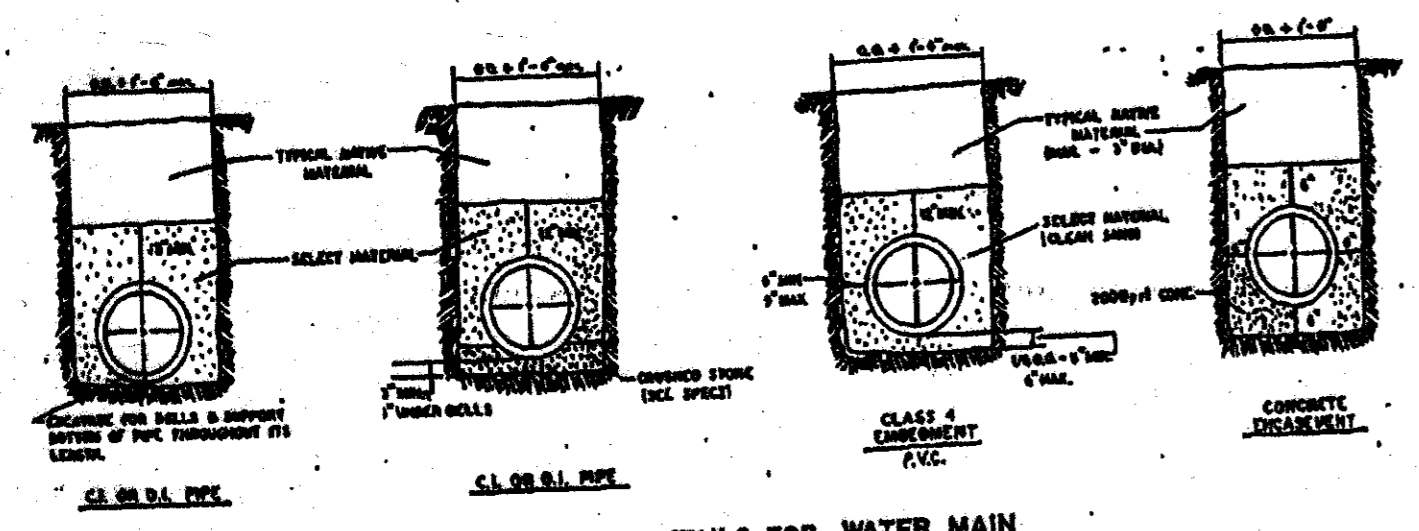


EMBEDMENT DETAILS FOR WATER MAIN

↑  
US


SITE PLAN  
SCALE: 1"=20'-0" N

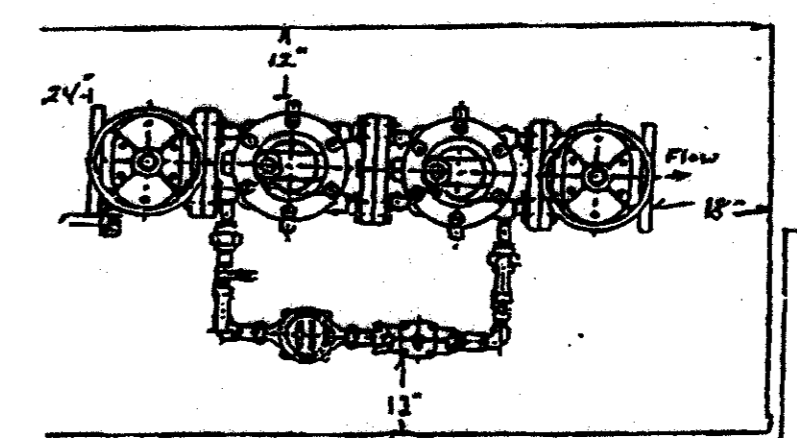

DC DETAIL  
NO SCALE

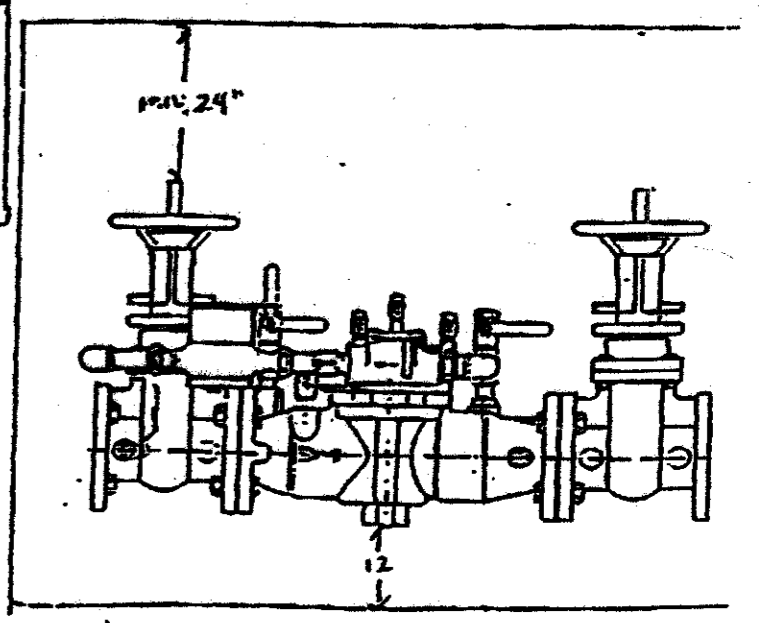

WITH PIT PACK

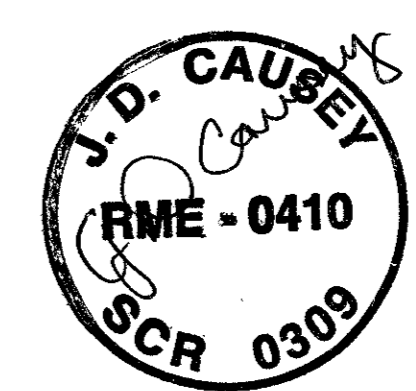

|                                   |                          |
|-----------------------------------|--------------------------|
| TALIS KET APARKMENTS              | DATE:<br>A-20-02         |
| 3925 BROOKHAVEN CLUB              | SCALE:<br>AS NOTED       |
| ADDITION, TEXAS                   | REG.#<br>0309            |
| DIVERSIFIED FIRE PROTECTION, INC. | RME#<br>0410             |
| 3941 MIDWAY RD.                   | RME NAME:<br>J.D. CAUSEY |
| (817) 834-6401                    | DRAWN BY:<br>D. WILLIAMS |
| FT. WORTH, TEXAS, 76117           | SHEET #<br>F.P. 10F1     |

41-3