


VITRUVIAN WAY



- LEGEND**
- DULPEX 20A GFCI RECEPTACLE
  - HUBBELL GFR5362SGW OR EO
  - SIMPLEX 30A 120/240V 4 WIRE L14-30 LOCKING RECEPTACLE
  - HUBBELL OR EO WITH WHITE-IN-USE WATERPROOF COVER
  - QUAD (2) CIRCUIT 20A GFCI RECEPTACLE
  - (2) HUBBELL GFR5362SGW OR EO WITH WHITE-IN-USE WATERPROOF COVER
  - LIGHT POLE BASE AND FIXTURE TYPE
  - XX-XX PANEL DESIGNATION & CIRCUIT NUMBER
  - POWER CONDUIT
  - LIGHTING CONDUIT
  - IRR IRRIGATION SLEEVE - 1-6" & 1-2" SCH 40 PVC UNLESS OTHERWISE NOTED

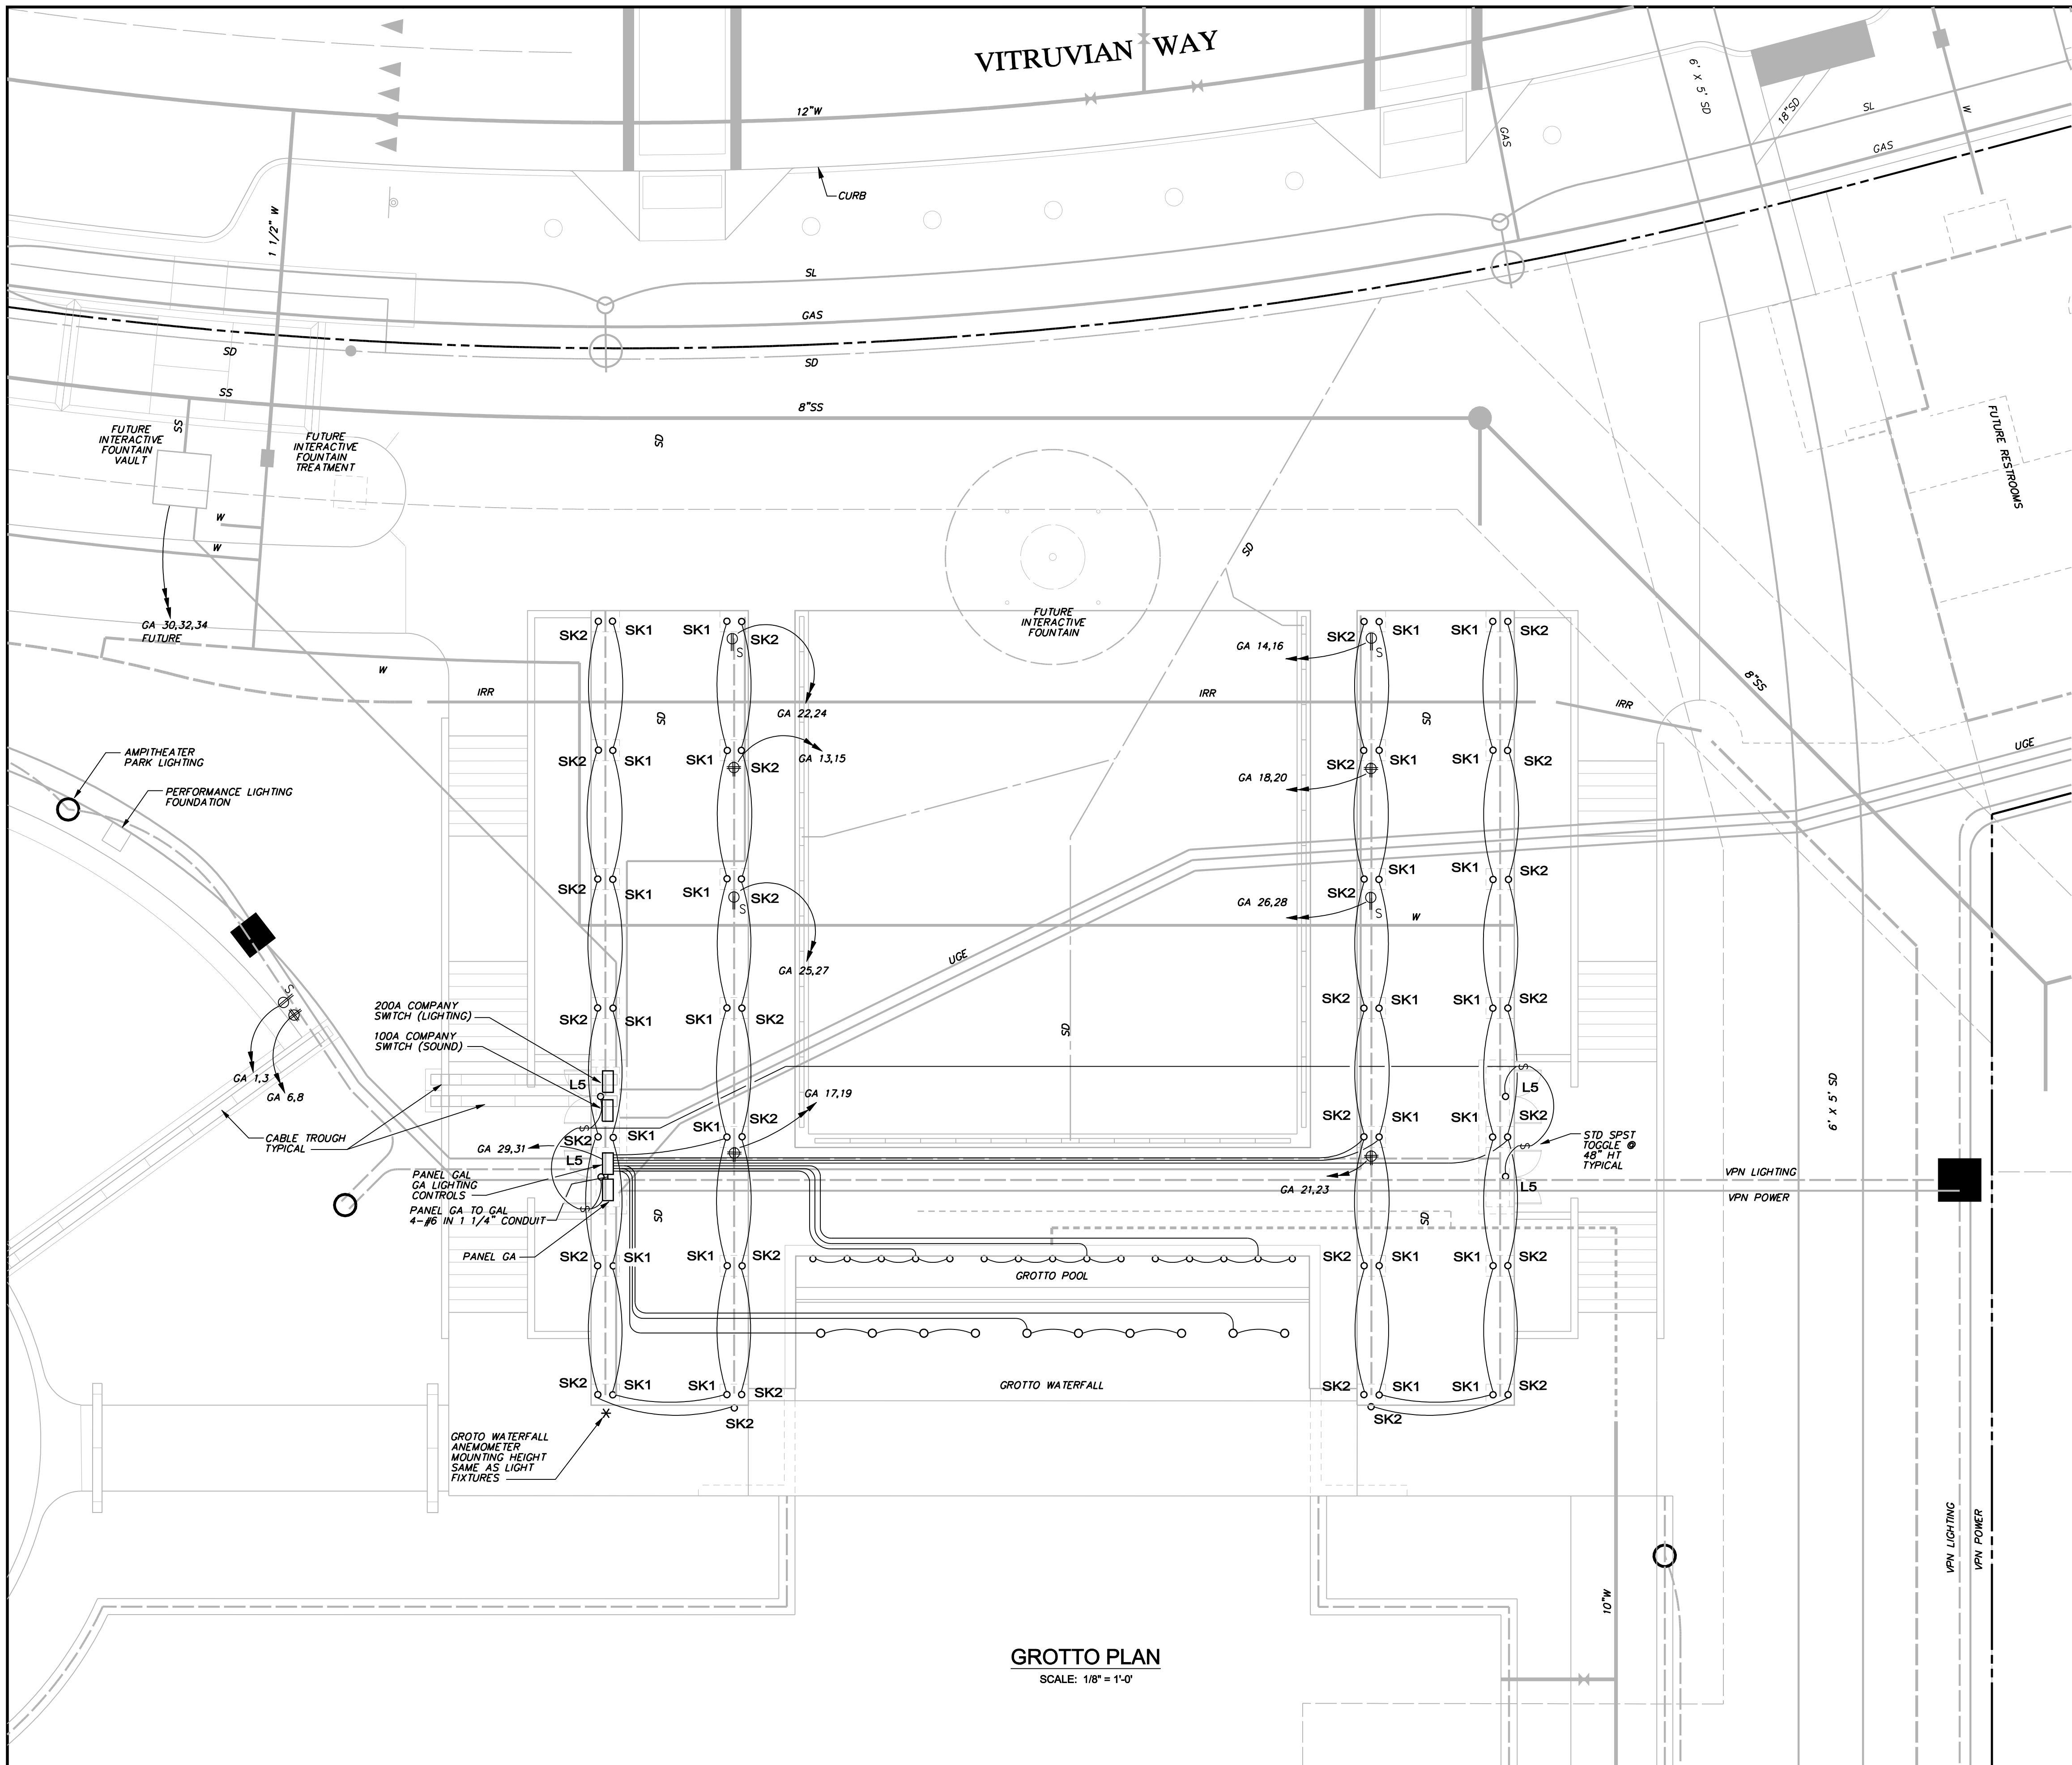

**GROTTO PLAN**  
SCALE: 1/8" = 1'-0"

NO.	REVISION	BY	DATE
<b>TOWN OF ADDISON</b> DALLAS COUNTY, TEXAS			
<b>PARK AND STREETSCAPE IMPROVEMENTS</b> VITRUVIAN PARK			
<b>PARK LIGHTING &amp; ELECTRICAL PLAN</b> GROTTO			
<b>icon</b> Consulting Engineers, Inc. Civil Engineers - Designers - Planners		250 W. Southlake Blvd., Suite 117 Southlake, Tx 76092 (817) 552-6210	
PROJECT	DESIGN	DRAWN	DATE
5029-01	ICE	ICE	APR 26, 2010
FILE	SHEET		
PW# 2009-04	C805		

PARK AND STREETSCAPE IMPROVEMENTS - VITRUVIAN PARK