
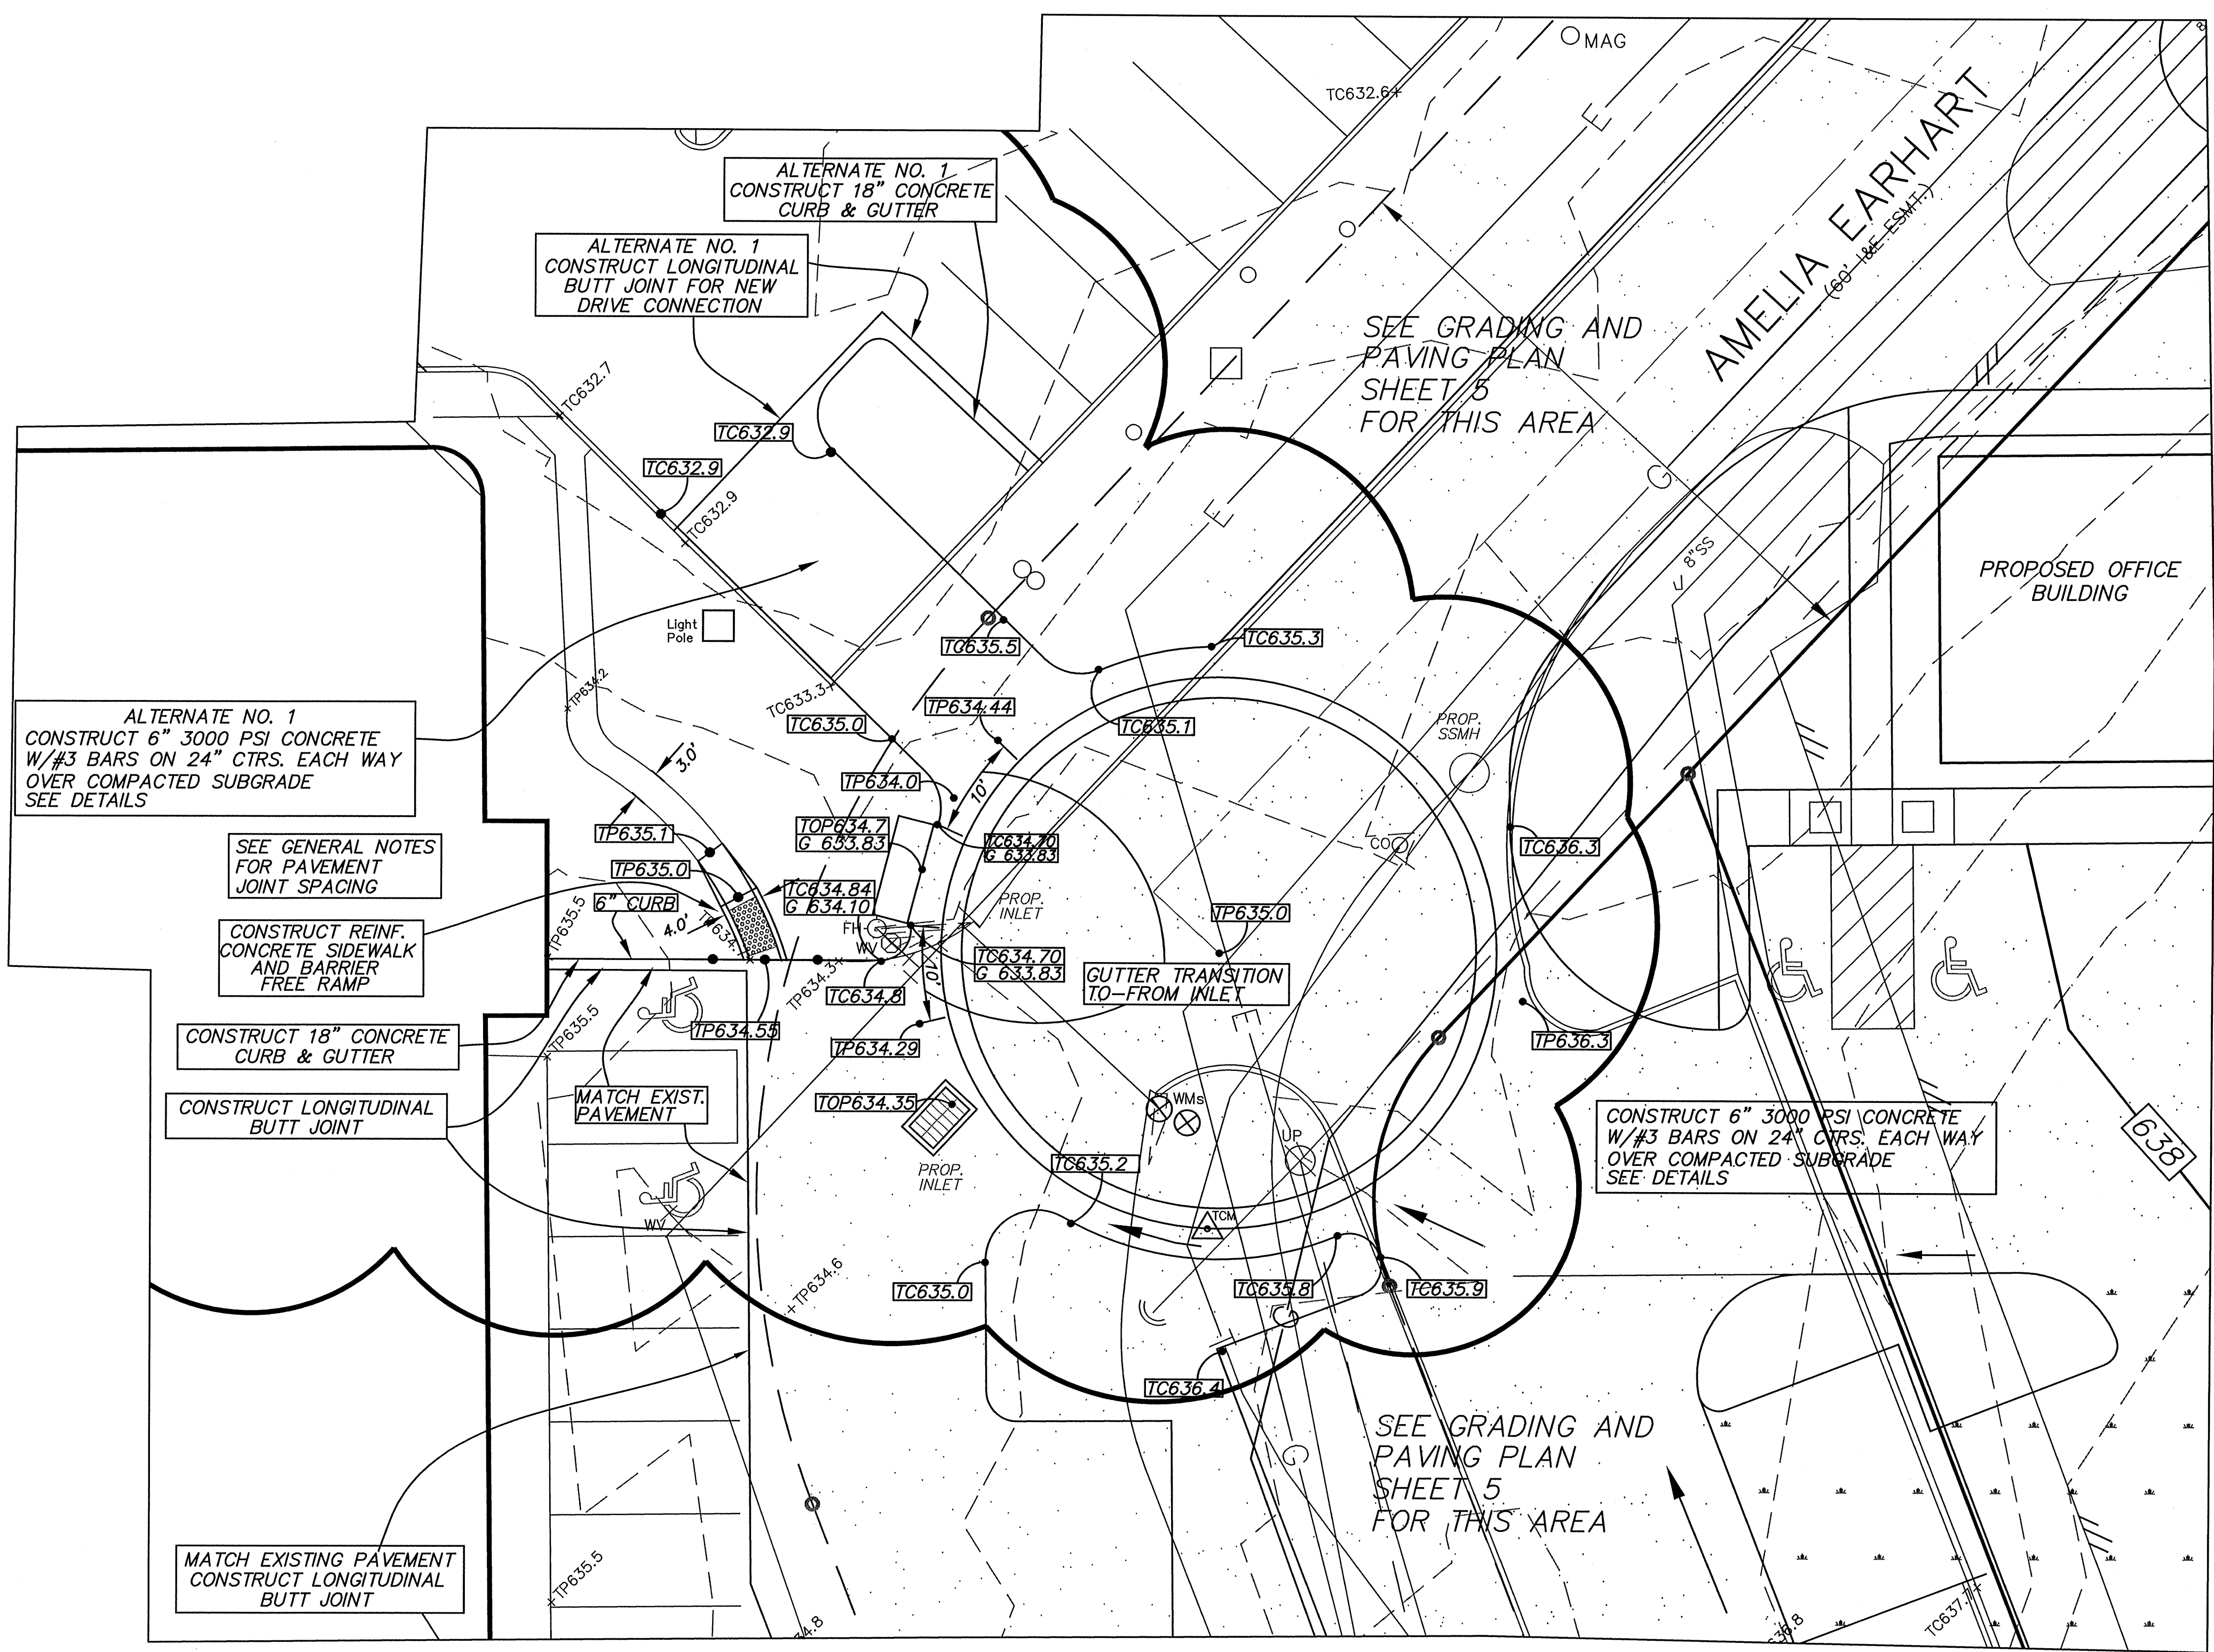


- LEGEND**
- FIR Found Iron Rod
 - UP Utility Pole
 - LP Light Pole
 - A Anchor
 - FH Fire Hydrant
 - WM Water Meter
 - WV Water Valve
 - WW Wastewater
 - SMH Storm Manhole
 - SD Storm Drain
 - RCP Reinf. CONcrete Pipe
 - EM Electric Meter
 - GM Gas Meter
 - 643.1 Ex. CONtour
 - x643.1 Ex. Spot Elevation
 - Proposed Spot Elevation
 - FF Finish Floor
 - TC Top of Curb
 - RW Retaining Wall
 - G Gutter

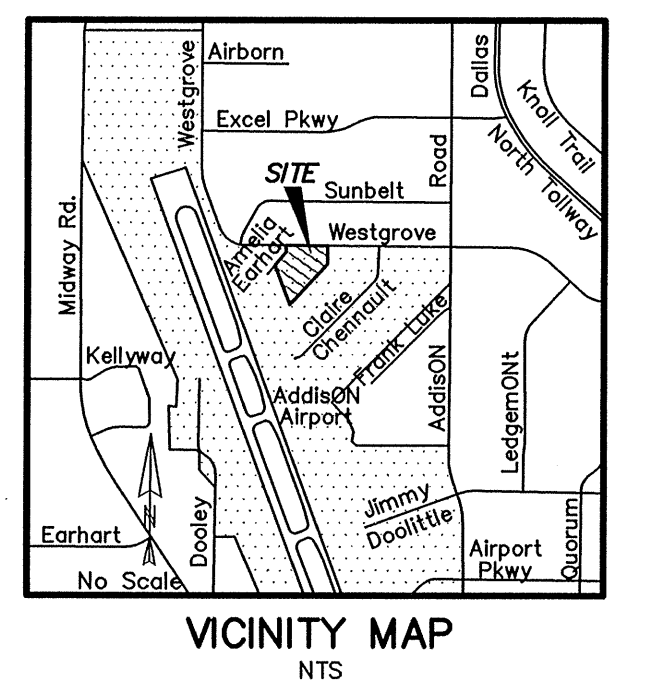

PAVING LEGEND

- HEAVY DUTY PAVEMENT**
6" 3000 PSI CONCRETE
W/#3 BARS ON 24" CTRS. EACH WAY
OVER 6" COMPACTED SUBGRADE
SEE DETAIL SHEET
- LIGHT DUTY PAVEMENT**
5" 3000 PSI CONCRETE
W/#3 BARS ON 24" CTRS. EACH WAY
OVER 6" COMPACTED SUBGRADE
SEE DETAIL SHEET
- EXISTING CONCRETE PAVEMENT**

NOTE: EXISTING FEATURES AND TOPOGRAPHIC INFORMATION SHOWN WAS FURNISHED BY OWNER FROM SURVEY PREPARED BY: BRAD SPARR DATED: _____

BENCH MARK: FOUND SQUARE CUT AT NORTHWEST CORNER OF BOX INLET, 13.5' SOUTH OF INTERSECTION OF SOUTH LINE OF WESTGROVE ROAD & EAST LINE OF AMELIA EARHART. ELEV. 632.80

6
14

SEE TOWN OF ADDISON CONSTRUCTION DETAILS
SEE SHEETS 13 & 14 FOR DETAILS AND NOTES

GRADING AND PAVING PLAN			
FOR CIRCLE AREA			
MILLION AIR - PHASE TWO			
LEASE PARCEL No. 70-WESTGROVE RD.			
ADDISON MUNICIPAL AIRPORT			
TOWN OF ADDISON, TEXAS			
DESIGN	DRAWN	DATE	SCALE
K&A	K&A	SEPT.2010	1"=10'
			PROJECT No. 10544

RECORD DRAWING

DATE: October 26, 2012

Based on information furnished from the Contractor and to the best of the design engineer's knowledge, the constructed work is substantially in accordance with this plan.

PREPARED BY

KADLECK & ASSOCIATES
ENGINEERING PLANNING SURVEYING
3000 N. CENTRAL EXPY. SUITE 113
(972) 881-0771 PLANO, TX 75074
TBPE Reg. No. F-6460 TBPLS Reg. No. 100555-00