


BT BROOK
B12-5

PLUMBING SITE PLAN

GAS METER &
REGULATOR
TOTAL DEMAND
REQ'D 3,180 CFH

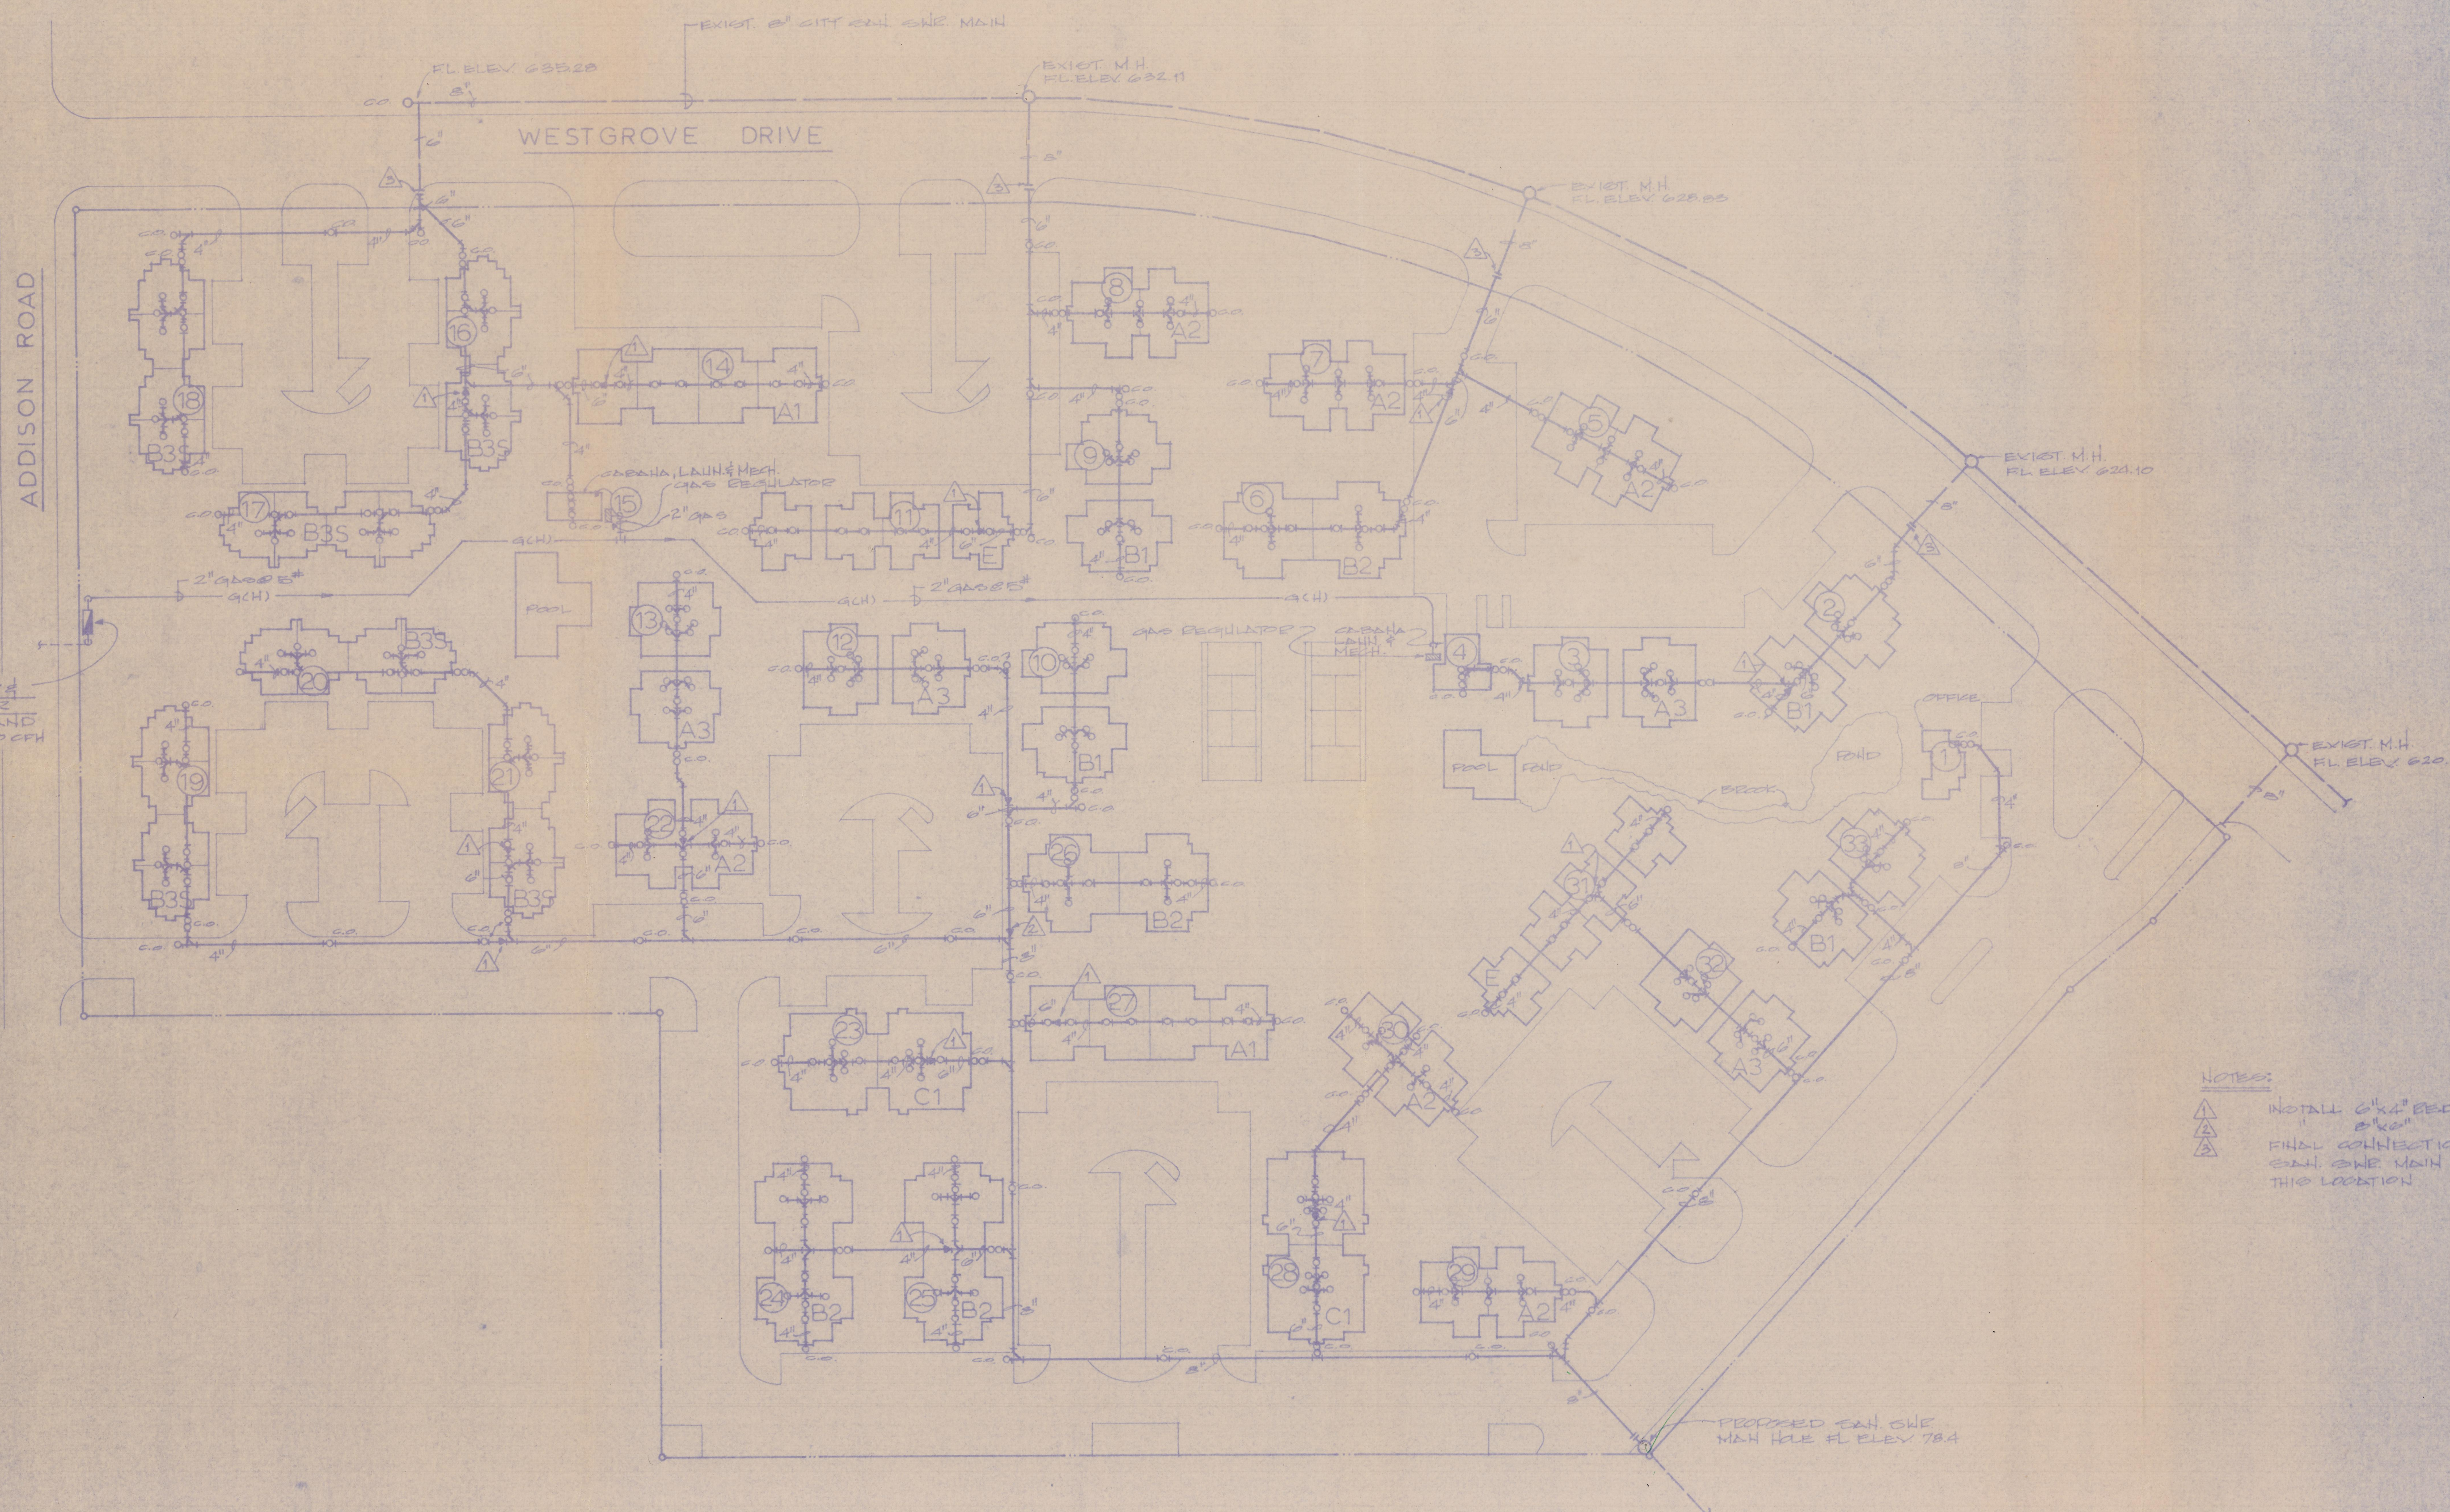

SYMBOL	DESCRIPTION
---	CITY SANITARY SEWER MAIN
---	CITY WATER MAIN
○	CITY WATER METER
○	TANITARY SEWER PIPE
---	SANITARY SEWER VENT PIPE
---	COLD WATER SUPPLY PIPE
---	HOT WATER SUPPLY PIPE
---	HOT WATER RETURN PIPE
VB	VALVE BOX AND VALVES
DCA	DOUBLE CHECK ASSEMBLY SET IN BOX
HP	HIGH PRESSURE INTERMEDIATE HIGH PRESSURE
DU	GAS SUPPLY PIPE - HIGH PRESSURE 3/8"
LD	GAS SUPPLY PIPE - LOW PRESSURE 1/2"
GR	GAS METER AND REGULATOR
R	GAS REGULATOR
CS	GAS STOP
GV	GATE VALVE
CV	CHECK VALVE
GV	GLOBE VALVE
CO	ONE WAY SANITARY SEWER CLEAN-OUT
CO	TWO WAY SANITARY SEWER CLEAN-OUT
WC	WALL CLEAN-OUT
FD	FLOOR DRAIN
RD	ROOF DRAIN
AD	AREA DRAIN
HE	FROST PROOF HOSE BIB
TP	TEMP. FREENG. AND RELIEF VALVE

NOTE: ALL SYMBOLS SHOWN MAY NOT NECESSARILY BE USED.

NOTES:
 ▲ INSTALL 6" x 4" REDUCER
 ▲ FINAL CONNECTION INTO CITY
 SANITARY SEWER MAIN BY PLUMBER
 THIS LOCATION



PLUMBING SITE PLAN

SCALE:

1" = 80'-0"

REV. 5-21-78 (14) 4820 WESTGROVE DRIVE BENT TREE BROOK TX 78008

PLUMBING SITE PLAN	Job No.
BENT TREE BROOK	508
4820 WESTGROVE DR.	
Tempo Mechanical	
A Texas Distributors, Inc. Company	
2352 Wisconsin St.	
Dallas Texas 75239	
Phone 214-241-9475	

B12-5

BT BROOK PLUMBING SITE PLAN

Redo
gpa

PLUMBING SITE PLAN
BT BROOK
B12-5

B12-5