

Sta. 6+00 (6' Rt. of C)  
Install 5' M.H.  
Top El. 553.31


Sta. 10+00 (6' Rt. of C)  
Install 5' M.H.  
Top Elev. 558.15

**CAUTION!**  
Underground Gas Main In This Area.  
Contact Lone Star Gas Company 2  
Working Days Prior To Construction.  
Call MR. Leon Weatherford At  
276-1171

Contractor Shall Notify Dallas  
Water Utilities Construction  
Inspection At 670-8700 At  
Least 48 Hours Prior To  
The Start Of Construction.

B.M. ~ "D" Cut on edge of concrete  
porch of Church at 5535 Celestial.  
ELEV. 577.95 (m.s.l.)

B.M. ~ "D" Cut on headwall, E. Side  
of Winnwood, 180' S. of Bell Line E.  
ELEV. 555.79 (m.s.l.)

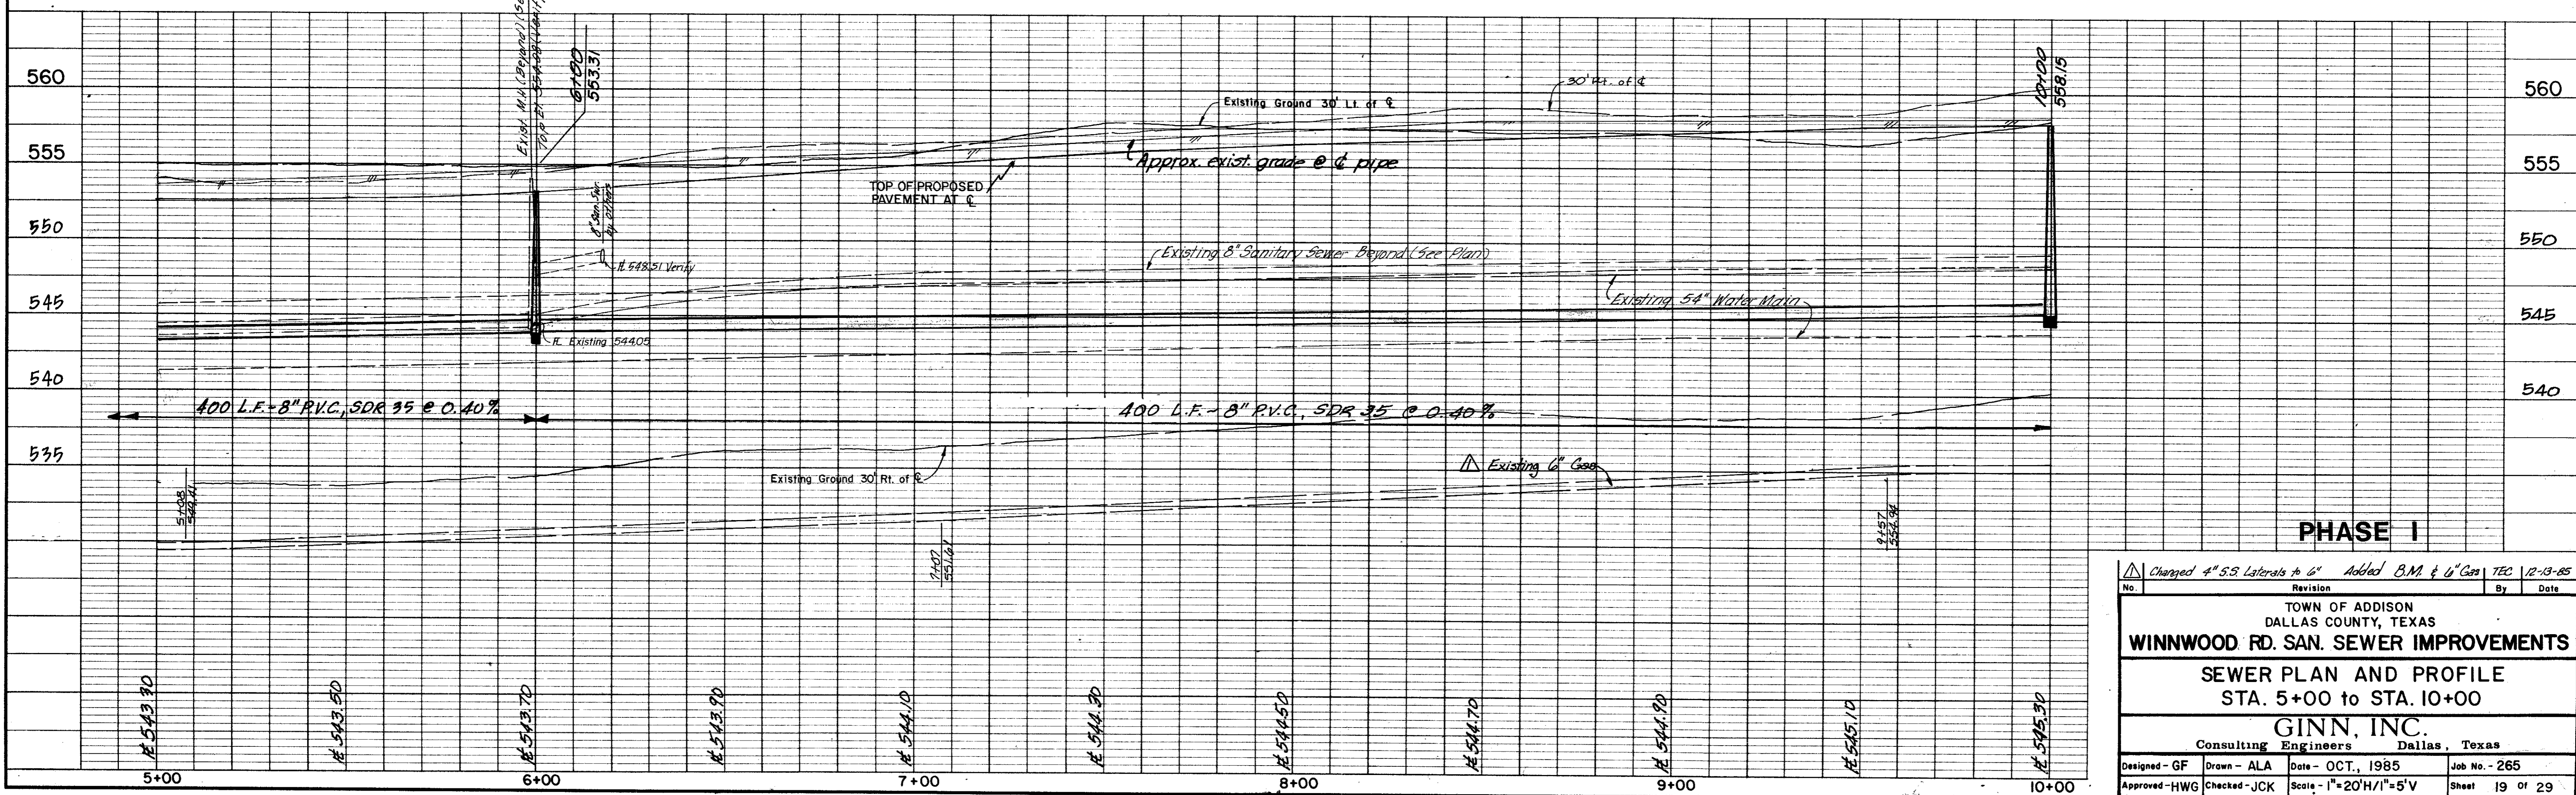

**PHASE I**

Charged 4" S.S. Laterals to 6" Added B.M. & 6" Gas TEC 12-13-85			
No.	Revision		
TOWN OF ADDISON DALLAS COUNTY, TEXAS <b>WINNWOOD RD. SAN. SEWER IMPROVEMENTS</b> <b>SEWER PLAN AND PROFILE</b> <b>STA. 5+00 to STA. 10+00</b> <b>GINN, INC.</b> Consulting Engineers Dallas, Texas			
Designed - GF	Drawn - ALA	Date - OCT, 1985	Job No. - 265
Approved - HWG	Checked - JCK	Scale - 1"=20'H/1"=5'V	Sheet 19 of 29

TEL: 214-343-1111