



LUMINAIRE SCHEDULE									
Symbol	Label	Qty	Catalog Number	Description	Lamp	File	Lumens	LLF	Watts
☉	A	2	EH16 175M MED GCF SR2	EUROTIOQUE ARCHITECTURAL LUMINAIRE WITH SR4SC REFLECTOR, CLEAR FLAT GLASS LENS.	ONE 175-WATT CLEAR ED17 METAL HALIDE, HORIZONTAL POS.	L110240H.ies	12800	1.00	213.6
☉	B	1	EH16 175M MED GCF SR3	EUROTIOQUE ARCHITECTURAL LUMINAIRE WITH SR4SC REFLECTOR, CLEAR FLAT GLASS LENS.	ONE 175-WATT CLEAR ED17 METAL HALIDE, HORIZONTAL POS.	L110239H.ies	12800	1.00	213.6
☉	C	1	EH16 175M MED GCF SR4SC	EUROTIOQUE ARCHITECTURAL LUMINAIRE WITH SR4SC REFLECTOR, CLEAR FLAT GLASS LENS.	ONE 175-WATT CLEAR ED17 METAL HALIDE, HORIZONTAL POS.	L110238H.ies	12800	1.00	213.6

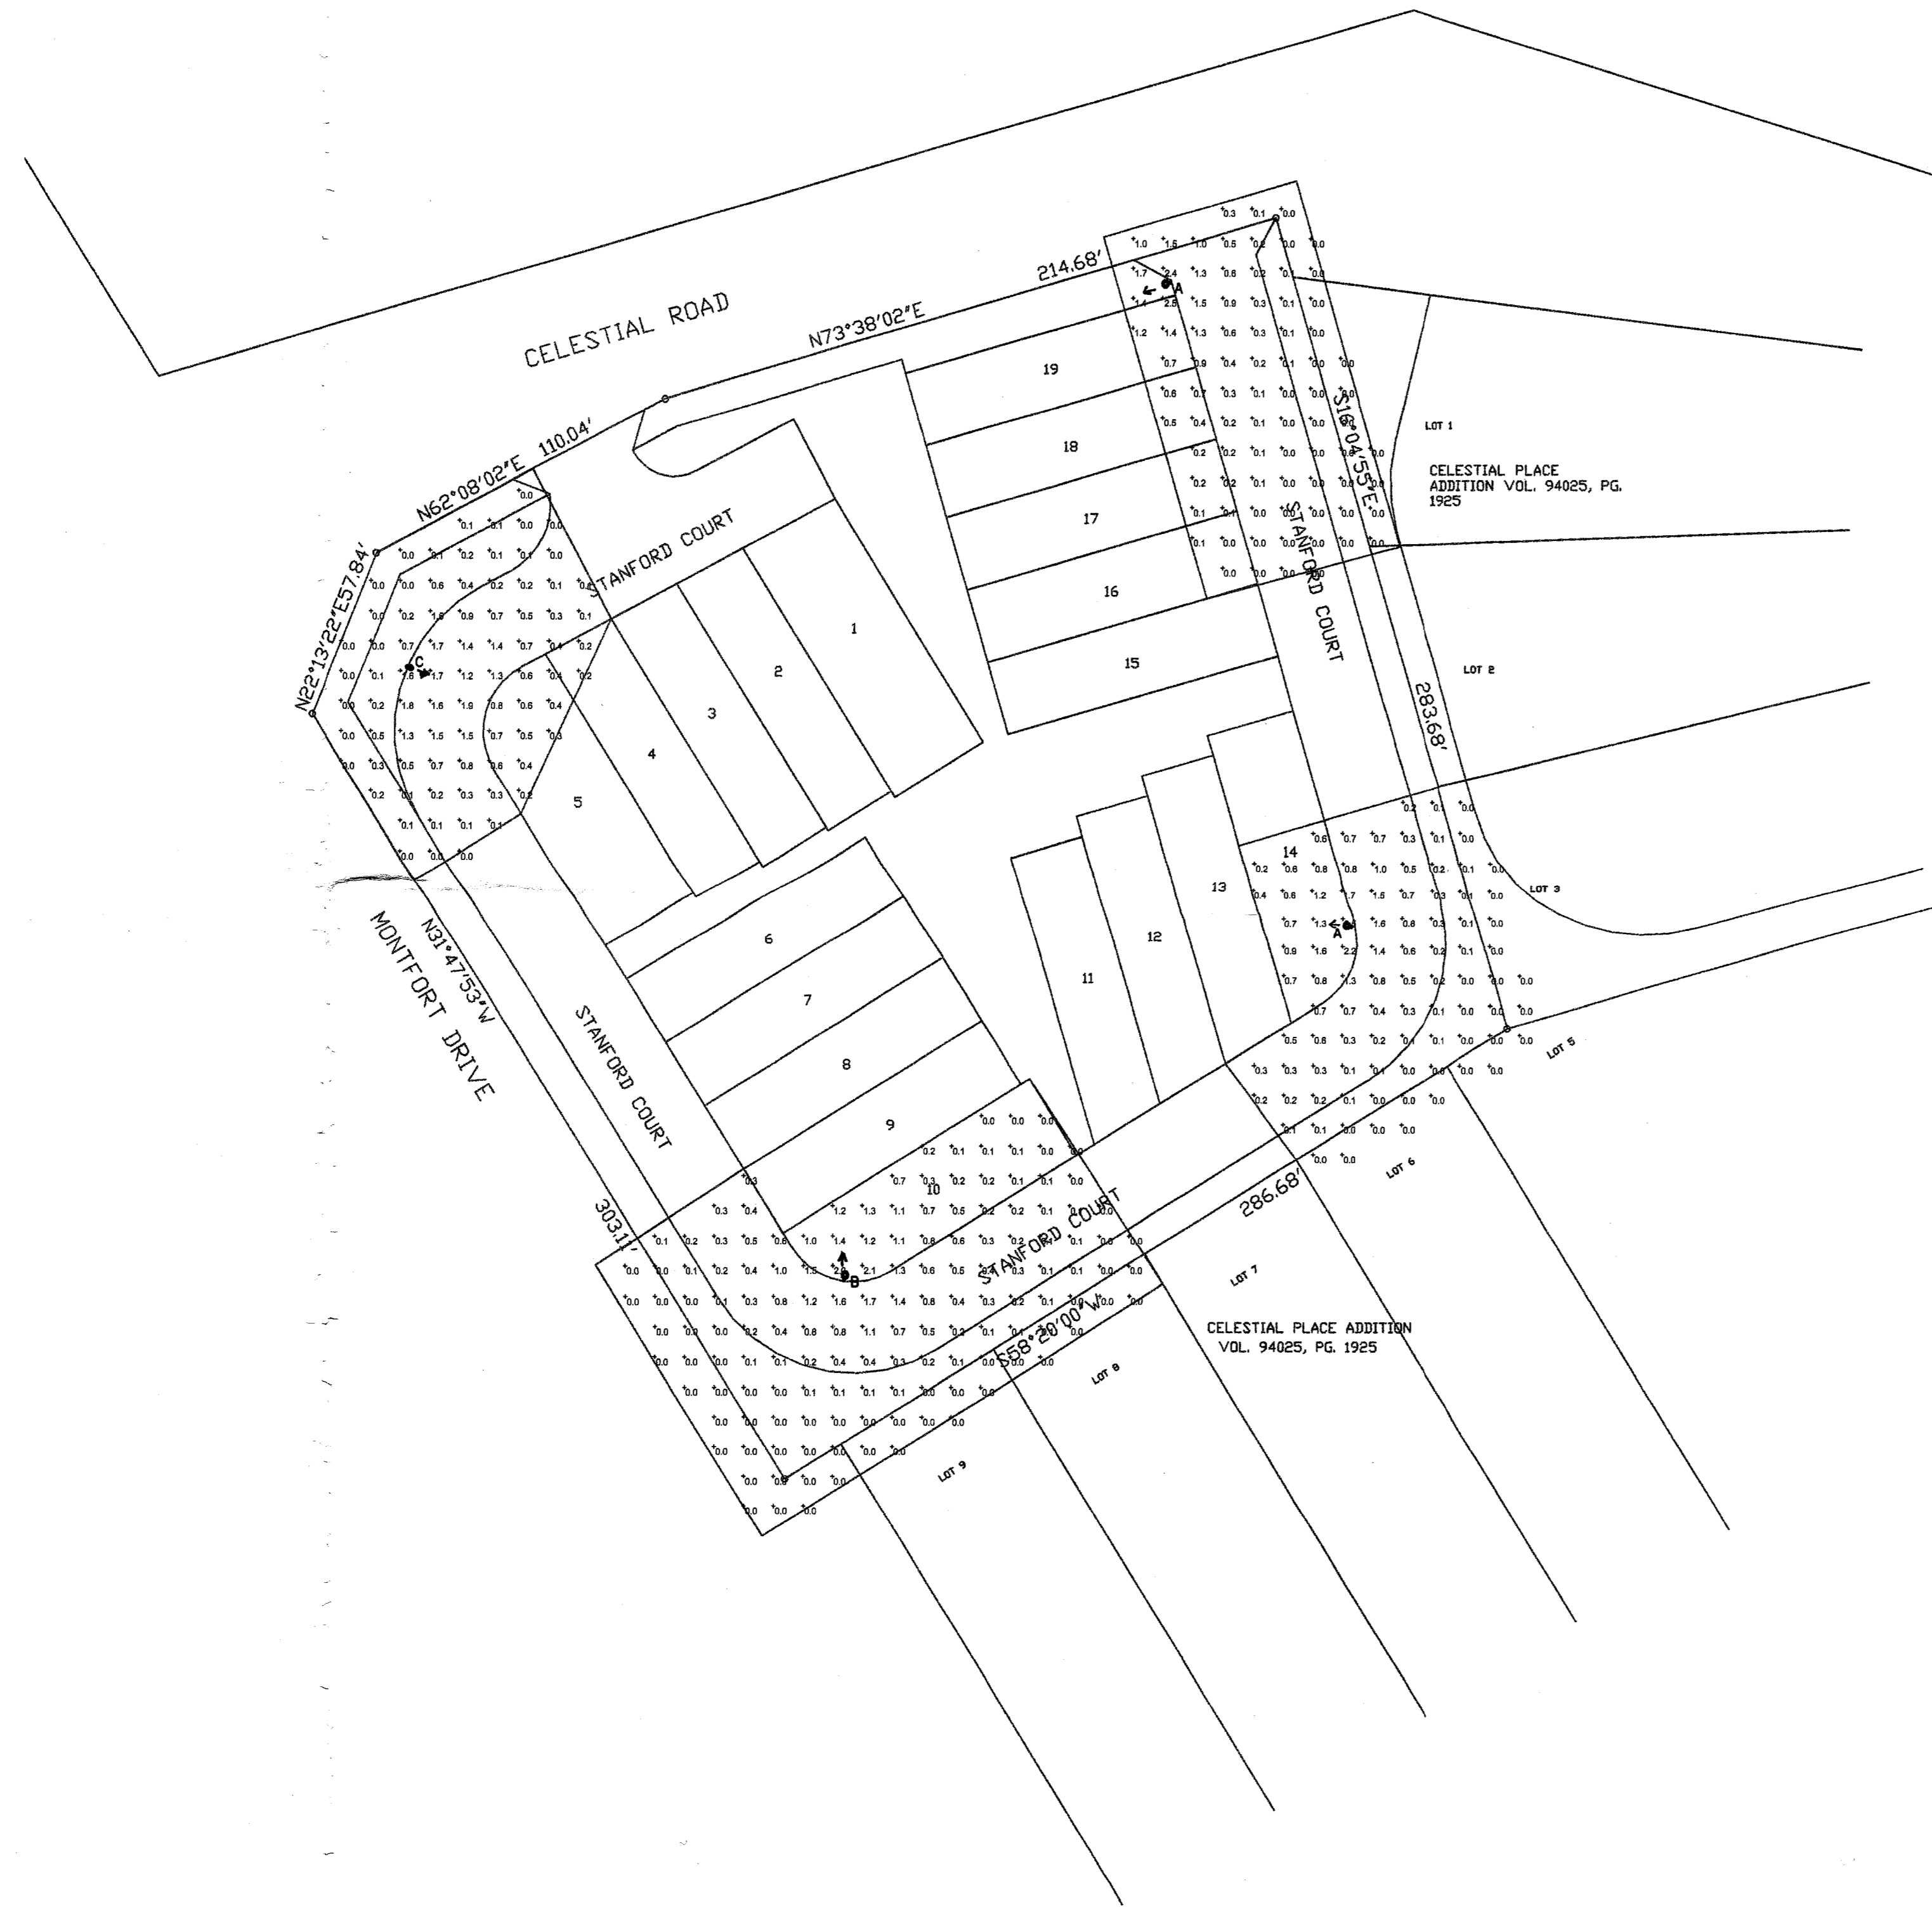

STATISTICS						
Description	Symbol	Avg	Max	Min	Max/Min	Avg/Min
Calc Zone #2	+	0.7 fc	2.8 fc	0.0 fc	N/A	N/A
Calc Zone #3	+	0.4 fc	2.9 fc	0.0 fc	N/A	N/A
Calc Zone #4	+	0.7 fc	2.8 fc	0.0 fc	N/A	N/A
Calc Zone #6	+	0.8 fc	2.8 fc	0.0 fc	N/A	N/A

Plan View
Scale 1" = 40'

STANFORD COURT
ADDISON, TEXAS

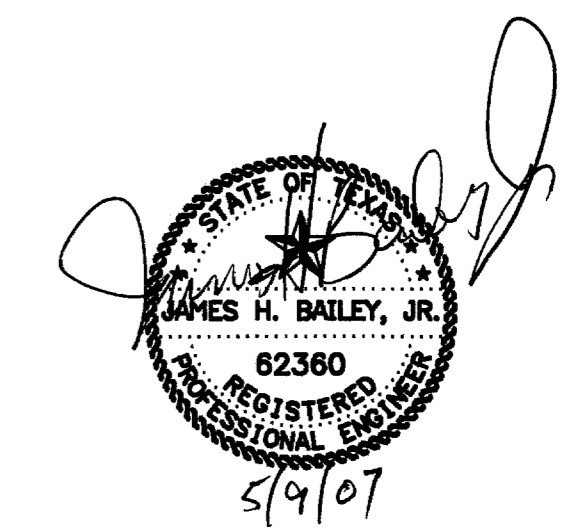

ARJO ENGINEERS, INC.
Consulting Engineers
4140 LEMMON AVE. SUITE 276, LB 110
DALLAS, TEXAS 75219-3768
PH. (214) 620-7799 FAX. (214) 620-7897

Designer
JTR
Date
Apr 12 2007
Scale
1" = 40'
Drawing No.
E1.0