



SLIP TRACK DETAIL


2 PARTITION TYPES
A1.1 SCALE: 1" = 1'-0"

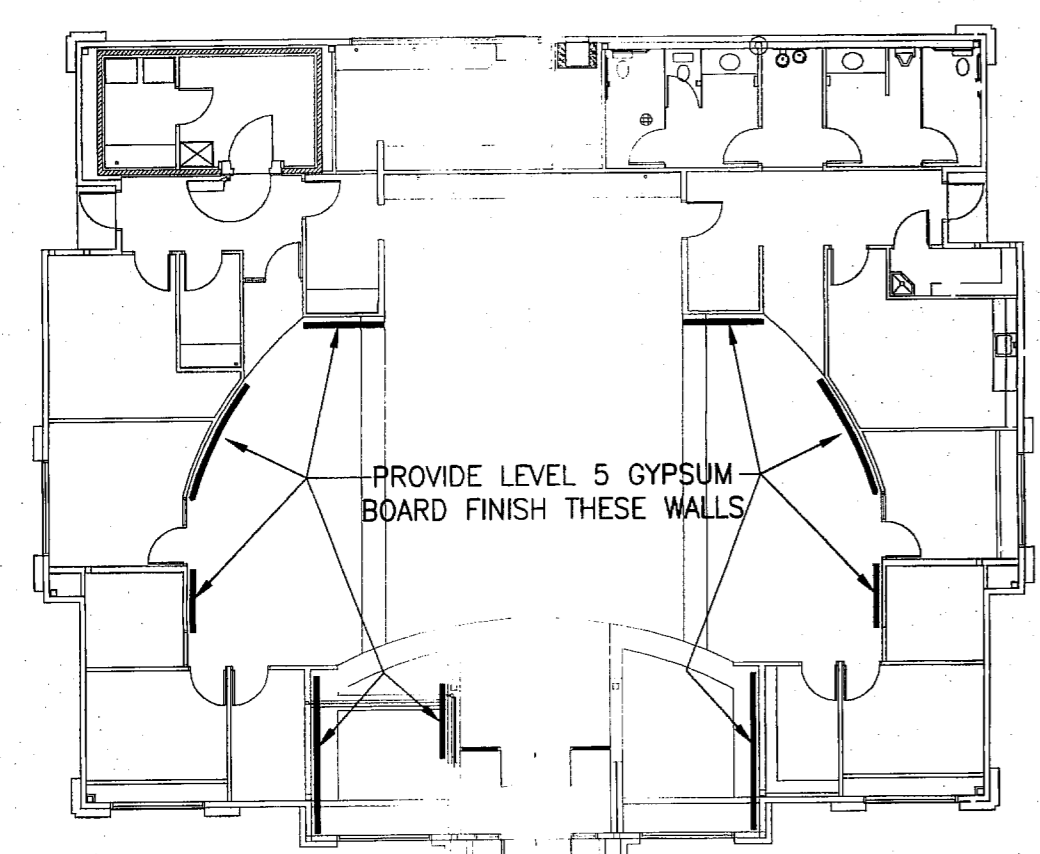

3 "LEVEL 5" GYPSUM BD. FINISH
A1.1 SCALE: no scale

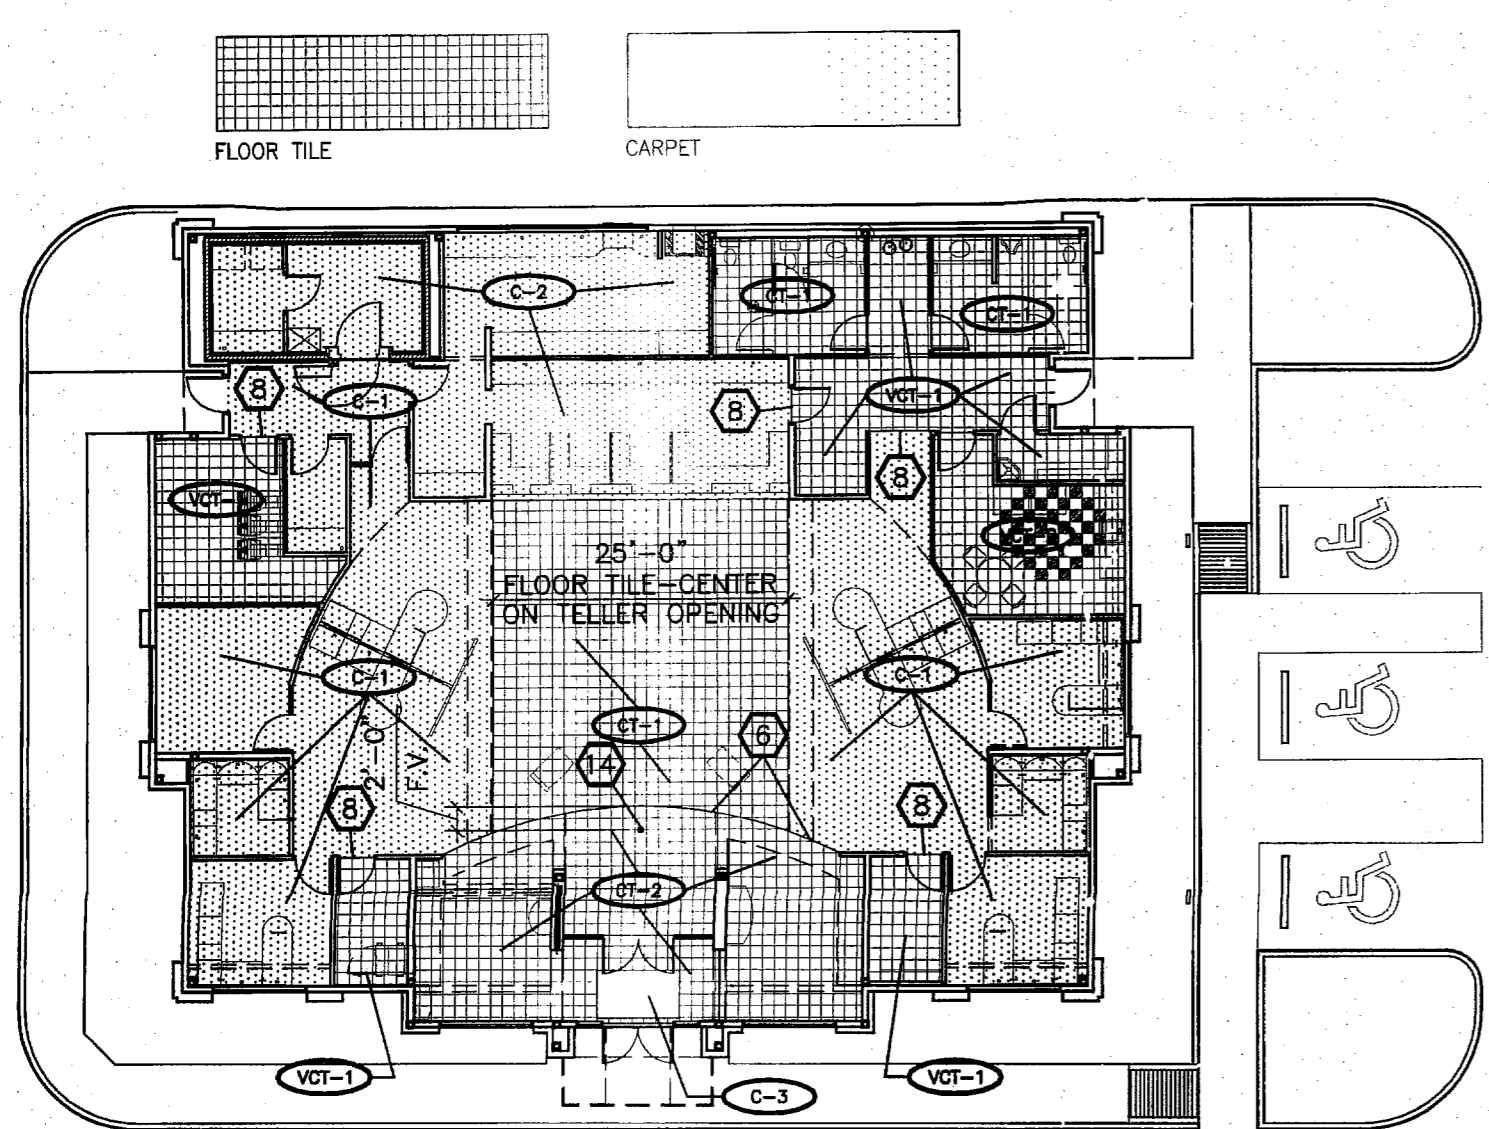

4 FLOOR FINISH & SIDEWALK PLAN
A1.1 SCALE: 1/16" = 1'-0"

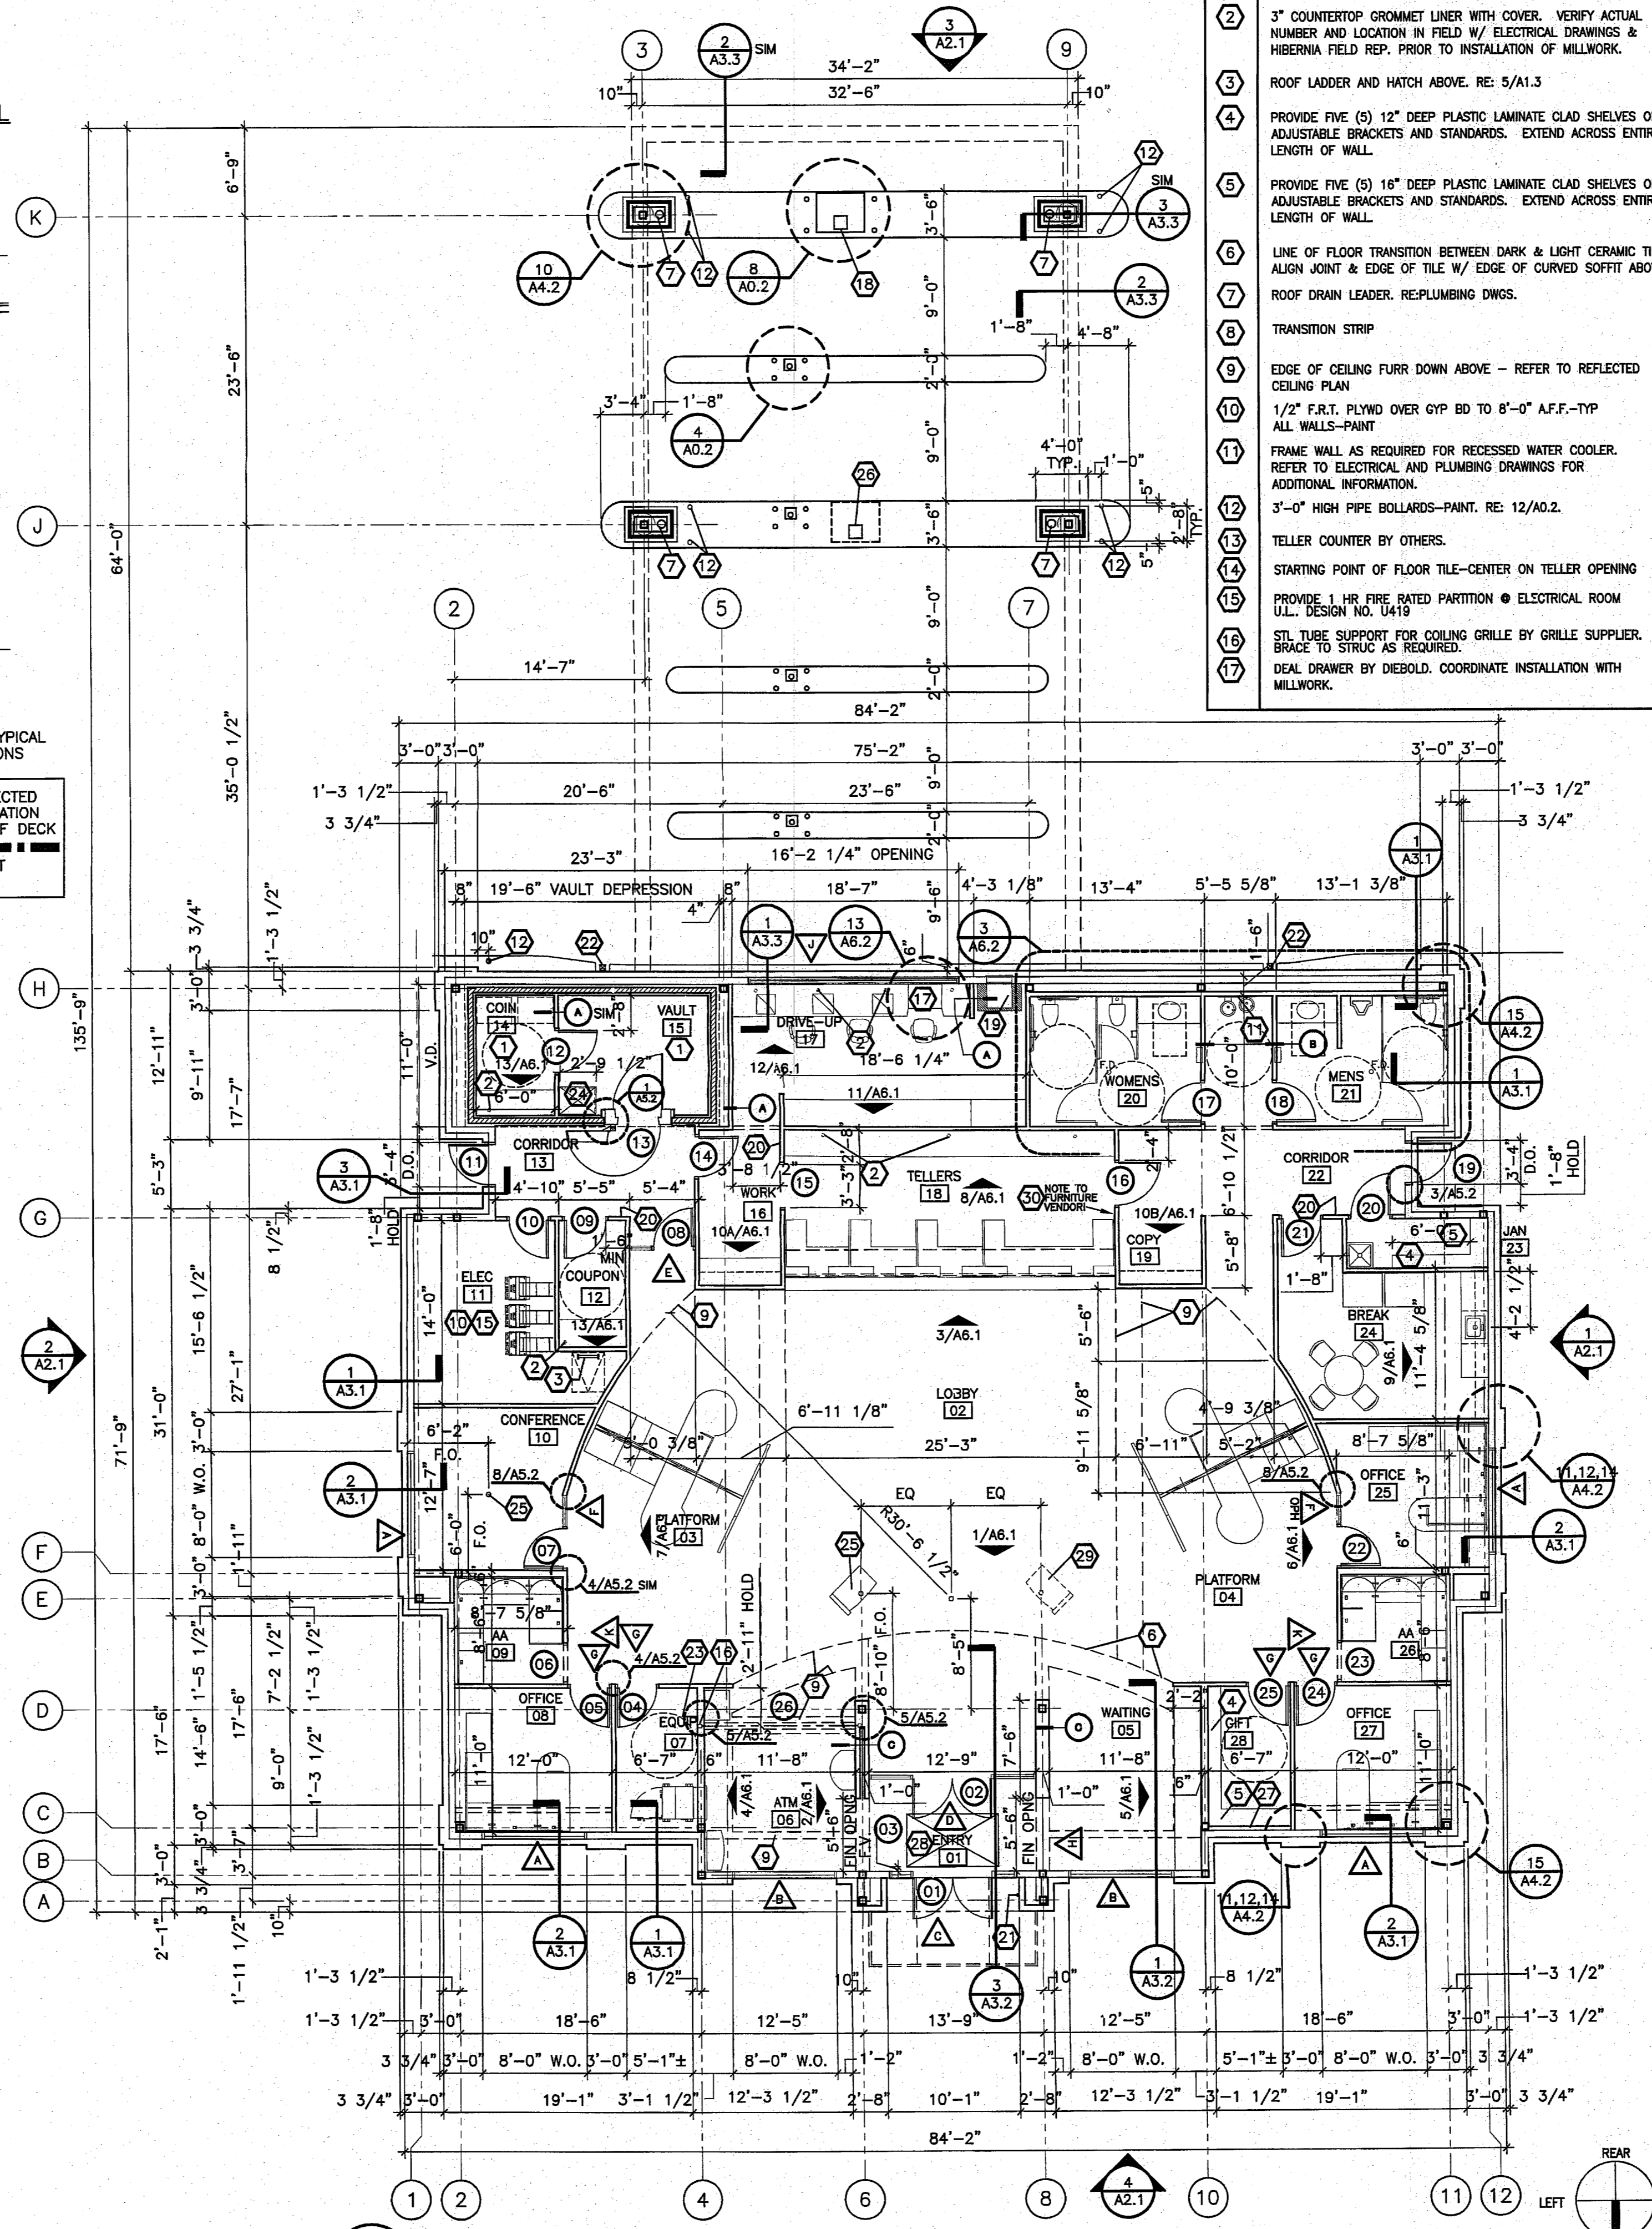

1 FLOOR PLAN
A1.1 SCALE: 1/8" = 1'-0"


GENERAL FLOOR PLAN KEYED NOTES

DESCRIPTION	GENERAL NOTES
1 CONCRETE MODULAR VAULT BY OTHERS. REFER TO STRUCTURAL FOR SLAB DEPRESSION. COORDINATE INSTALLATION OF VAULT WITH SUPPLIER. COMPLETE FINISH OF EXPOSED SURFACES OF VAULT W/ GYP BD ON 1 1/2" MTL STUDS @ 24" OC. MAX. REFER TO FINISH SCHEDULE.	18 DRIVE UP ATM BY DIEBOLD. CENTER UNDER CANOPY.
2 3" COUNTERTOP GROMMET LINER WITH COVER. VERIFY ACTUAL NUMBER AND LOCATION IN FIELD W/ ELECTRICAL DRAWINGS & HIBERNA FIELD REP. PRIOR TO INSTALLATION OF MILLWORK.	19 AFTER HOURS DEPOSIT. RE: 11/M.2.
3 ROOF LADDER AND HATCH ABOVE. RE: 5/A1.3	20 FIRE EXTINGUISHERS AS REQUIRED BY LOCAL GOVERNING AGENCY.
4 PROVIDE FIVE (5) 12" DEEP PLASTIC LAMINATE CLAD SHELVES ON H.D. ADJUSTABLE BRACKETS AND STANDARDS. EXTEND ACROSS ENTIRE LENGTH OF WALL.	21 AFTER HOURS ENTRANCE CARD READER. RE: ELEC DWGS. ON CAST STONE CAP OF WAINSCOT
5 PROVIDE FIVE (5) 16" DEEP PLASTIC LAMINATE CLAD SHELVES ON H.D. ADJUSTABLE BRACKETS AND STANDARDS. EXTEND ACROSS ENTIRE LENGTH OF WALL.	22 5" x 5" PREFINISHED DOWNSPOUT. CONNECT TO STORM. RE: 2/A0.3
6 LINE OF FLOOR TRANSITION BETWEEN DARK & LIGHT CERAMIC TILE. ALIGN JOINT & EDGE OF TILE W/ EDGE OF CURVED SOFFIT ABOVE.	23 EMERGENCY POWER OUTAGE RELEASE
7 ROOF DRAIN LEADER. REPLUMBING DWGS.	24 PROVIDE SOLID SURFACE COUNTER TOP ON LOWER DIEBOLD SAFETY DEPOSIT BOX. FIELD VERIFY. PROVIDE BULLNOSE EDGE ON (2) EXPOSED SIDES. NO BACKSLASH AT WALL. SHIM LEVEL AS REQUIRED. RE: 7/A&2 SIM
8 TRANSITION STRIP	25 FLOOR OUTLET. RE: ELECTRICAL DRAWINGS. FLOOR OUTLET LOCATIONS MIRRORRED ABOUT THE CENTER LINE OF THE LOBBY WHERE APPLICABLE. PROVIDE 2'x2' LEAVE OUT IN SLAB
9 EDGE OF CEILING FURR DOWN ABOVE - REFER TO REFLECTED CEILING PLAN	26 CONC KNOCK OUT FOR FUTURE ATM. CAP CONDUIT, FILL VOID W/ SAND & CAP WITH 4" CONC. REFER 8/A0.2 FOR LOCATION. REFER ELECTRICAL DWGS FOR CONDUIT.
10 1/2" F.R.T. PLYWD OVER GYP BD TO 8'-0" A.F.F.-TYP ALL WALLS-PAINT	27 FURR OUT WALL AS REQUIRED FOR INSTALLATION OF HOSE BIB.
11 FRAME WALL AS REQUIRED FOR RECESSED WATER COOLER. REFER TO ELECTRICAL AND PLUMBING DRAWINGS FOR ADDITIONAL INFORMATION.	28 ~4.5' LEAVE OUT IN FLOOR TILE FOR WALK OFF CARPET. CENTER ON DOOR
12 3'-0" HIGH PIPE BOLLARDS-PAINT. RE: 12/A0.2.	29 FLOOR OUTLET FOR FUTURE MEETER/GREETER. SET FLUSH W/ CONC SLAB & COVER W/ FLOOR TILE. RE: ELECTRICAL DWGS.
13 TELLER COUNTER BY OTHERS.	30 FURNITURE VENDOR TO VERIFY THAT CLEARANCE AT DOOR JAMB BE A MINIMUM OF 18" FOR ACCESSIBILITY.
14 STARTING POINT OF FLOOR TILE-CENTER ON TELLER OPENING	
15 PROVIDE 1 HR FIRE RATED PARTITION @ ELECTRICAL ROOM U.L. DESIGN NO. U419	
16 STL TUBE SUPPORT FOR COILING GRILLE BY GRILLE SUPPLIER. BRACE TO STRUC AS REQUIRED.	
17 DEAL DRAWER BY DIEBOLD. COORDINATE INSTALLATION WITH MILLWORK.	

CAPITAL ONE
DFW-35 ADDISON
BELT LINE RD. & MARSH LN.
ADDISON, TEXAS


CapitalOne

Capital One
Corp. Design & Construction
313 Carondelet 8th Floor
New Orleans, LA 70112

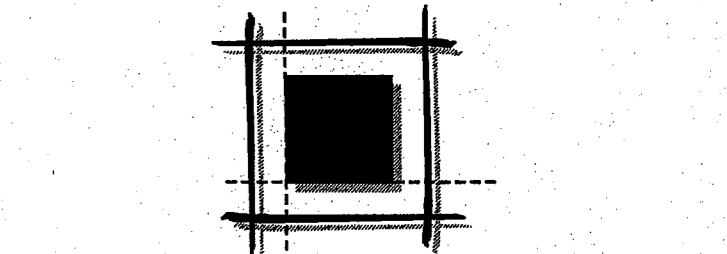

LEVINSON
ASSOCIATES, L.P.
6117 Richmond Ave., Suite 200 Houston, Texas 77057
tel 713.787.0000 fax 713.850.8250
ARCHITECTURE PLANNING INTERIOR DESIGN

DRAWN BY:	CHECKED BY:	REVISED BY:
REVISIONS		REV. BY:

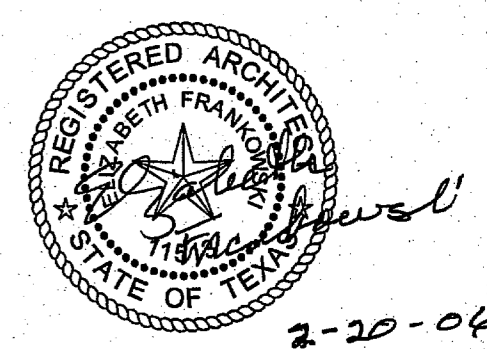

LALP Project Number: 25271.000
Issued For: PERMIT

A1.1

FLOOR PLAN
Issue Date: FEBRUARY 20, 2006